


Order Plans

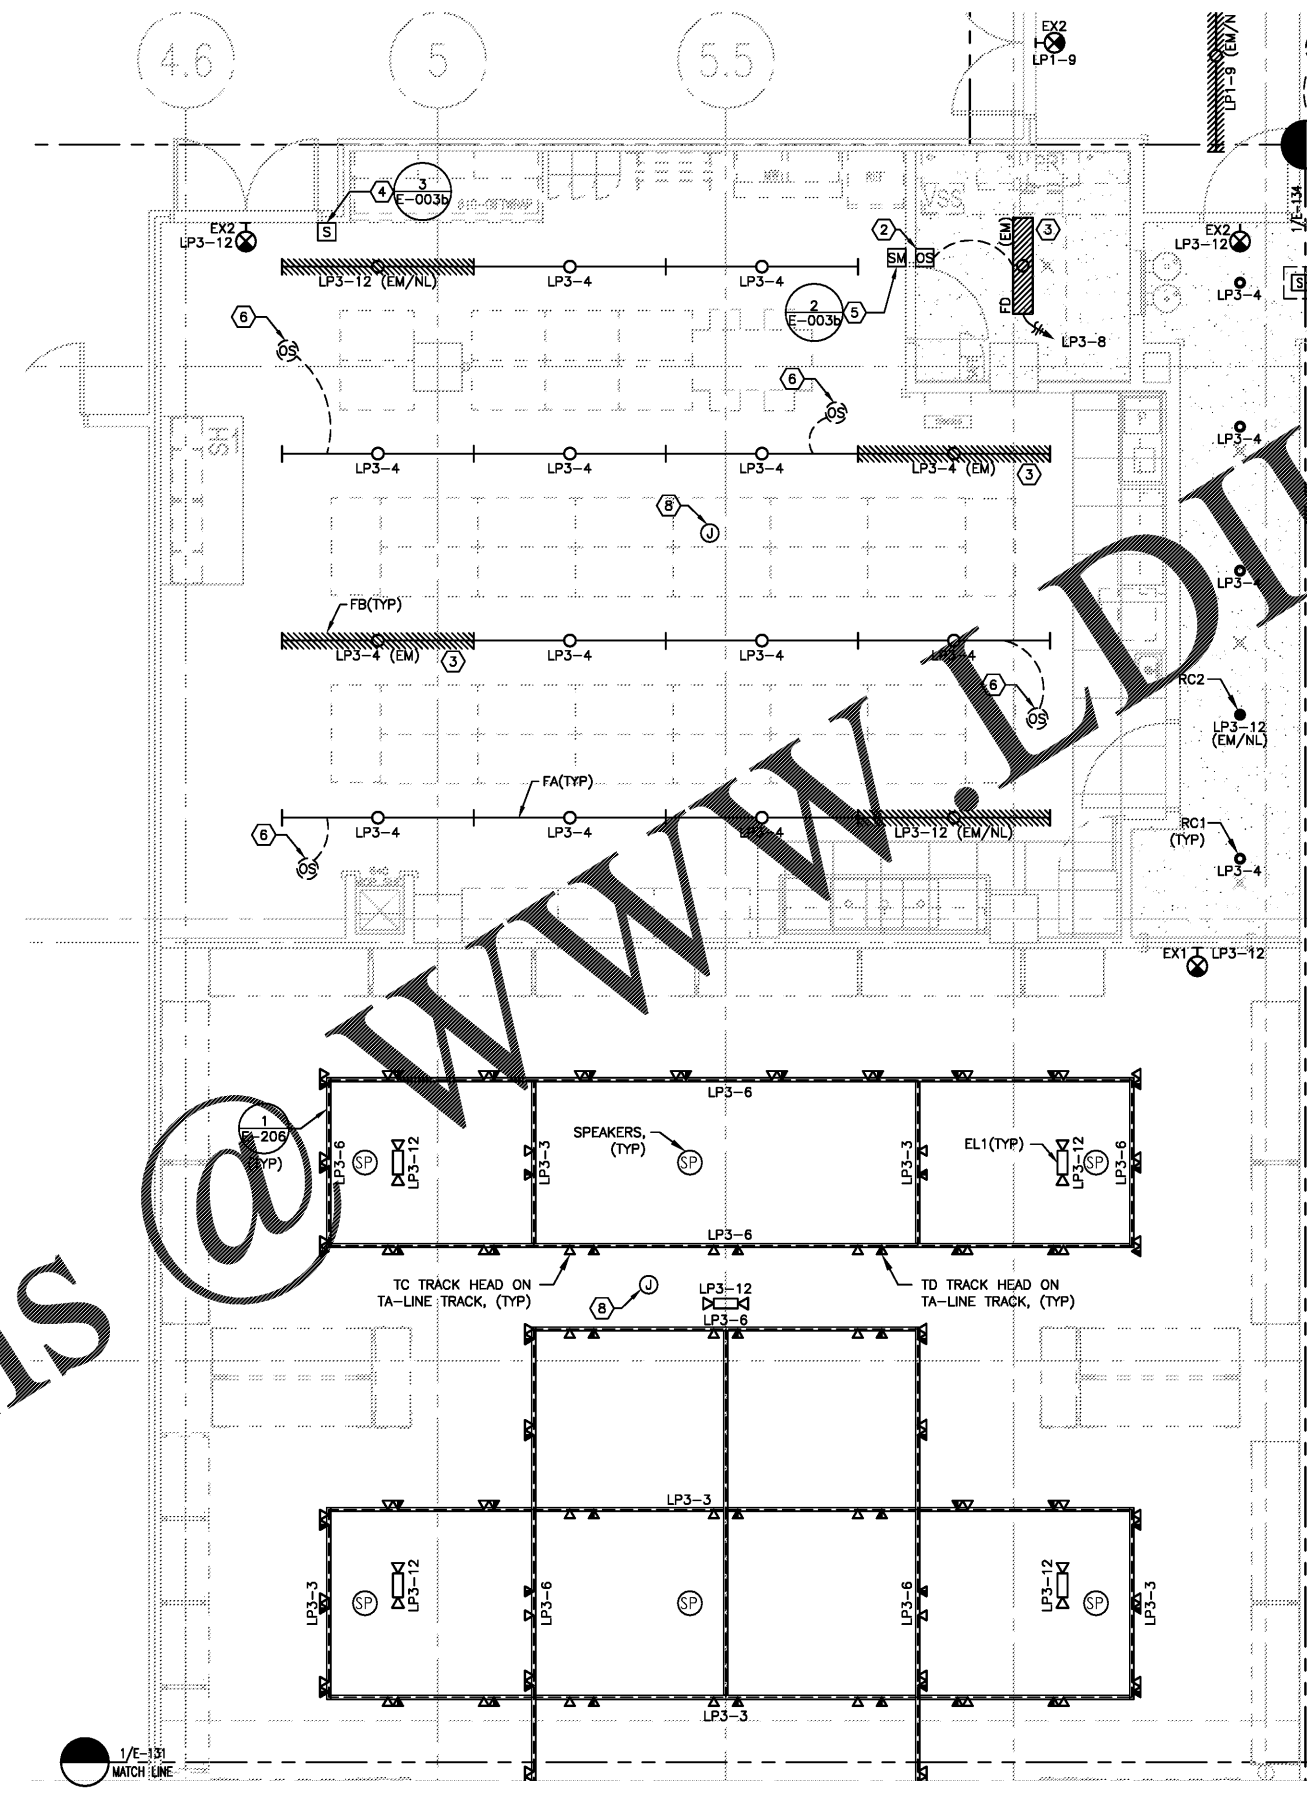

LIGHTING KEYED NOTES

- ① NOT USED.
- ② OCCUPANCY SENSOR SWITCH FOR CONTROL OF ROOM LIGHTING. OCCUPANCY SWITCH SHALL BE A WATT STOPPER PW100. SET SWITCH FOR MAXIMUM SENSITIVITY CONTROL AND ADJUST SWITCH TO MAINTAIN LIGHTS ON FOR 15 MINUTES AFTER LAST MOTION IS DETECTED. SWITCH SHALL BE ADJUSTED TO OVERRIDE THE LIGHT LEVEL ENERGY SAVING FEATURE. DIP SWITCH SETTING OF THE SWITCHES BENEATH THE COVER SHALL BE SET AS FOLLOWS:
ON - DIP 2,3,6,7
OFF - DIP 1,4,5,8
- ③ PROVIDE SEPARATE UN*SWITCHED HOT CIRCUIT TO EMERGENCY BALLAST IN FIXTURE FOR EMERGENCY OPERATION.
- ④ STOCK AREA LIGHTS LV OVERRIDE. REFER TO DETAIL.
- ⑤ MASTER LIGHTING LV OVERRIDE. REFER TO DETAIL.
- ⑥ CEILING MOUNTED OCCUPANCY SENSOR SWITCH FOR CONTROL OF ROOM LIGHTING. OCCUPANCY SWITCH SHALL BE A WATT STOPPER DT-300. SET SWITCH FOR MAXIMUM SENSITIVITY. CONTROL AND ADJUST SWITCH TO MAINTAIN LIGHTS ON FOR 15 MINUTES AFTER LAST MOTION IS DETECTED. SWITCH SHALL BE ADJUSTED TO OVERRIDE THE LIGHT LEVEL ENERGY SAVING FEATURE. DIP SWITCH SETTING OF THE SWITCHES BENEATH THE COVER SHALL BE SET AS FOLLOWS:
ON - DIP 7,8
OFF - DIP 1,2,3,5,6
- ⑦ NOT USED.
- ⑧ BOX FOR WIRELESS ACCESS POINT. SEE DETAILS ON SHEET E-202 AND E-205 FOR CONDUIT INFORMATION AND MOUNTING HEIGHTS.


LIGHTING GENERAL NOTES

1. REFER TO ARCHITECTURAL DRAWINGS FOR EXACT LOCATION OF ALL LIGHT FIXTURE.
2. ALL NIGHT LIGHTS AND EMERGENCY LIGHTS SHALL BE UNSWITCHED.
3. ALL LIGHTING CIRCUITS UP TO 100'-0" IN LENGTH SHALL UTILIZE #12 CONDUCTORS MINIMUM. ALL LIGHTING CIRCUITS FROM 101'-0" TO 150'-0" IN LENGTH SHALL UTILIZE #10 CONDUCTORS MINIMUM. ALL LIGHTING CIRCUITS 151'-0" UP TO 250'-0" IN LENGTH SHALL UTILIZE #8 CONDUCTORS MINIMUM. CIRCUITS ABOVE 251'-0" SHALL UTILIZE #6 CONDUCTORS MINIMUM.
4. ALL WIRING SHALL BE IN CONDUIT, EMT, OR RIGID, FLEXIBLE CONDUIT MAY BE USED FOR FINAL CONNECTIONS FROM OUTLET BOXES TO LIGHT FIXTURES, MOTORS, APPLIANCES, ETC. MAXIMUM LENGTH TO BE 6', NO BX, ROMEX, ARMORED CABLE, ETC. WILL BE ALLOWED.
5. ELECTRICAL CONTRACTOR MAY NEED TO CUT OUT DRYWALL SOFFIT FOR INSTALLATION OF LIGHT FIXTURES INTO MILLWORK.
6. CONTRACTOR TO REMOVE ALL EXISTING LIGHTING, EXIT SIGNS, AND LIGHTING CONTROL. REMOVE ALL CONDUIT AND CONDUCTOR BACK TO PANEL.
7. ALL ABANDONED AND/OR UNUSED COMPONENTS CREATED OR EXPOSED DURING CONSTRUCTION, INCLUDING BUT NOT LIMITED TO HVAC, CABLES, PIPING WIRING, AND ASSOCIATED SUPPORTS AND/OR ATTACHMENTS SHALL BE REMOVED.
8. JUNCTION BOX FOR PENDANTS TO BE MOUNTED TO CEILING DECK, NOT TO B-LINE.

G.C. TO SUBMIT SHOP DRAWINGS SHOWING THREADED ROD LOCATION FOR REVIEW AND APPROVAL PRIOR TO INSTALLATION.

IN SALES ALL BATTERY PACKS FOR EXIT AND EMERGENCY LIGHTS MUST BE REMOTE OR RECESSED. PAINT EXPOSED SURFACES TO MATCH ADJACENT FINISH.

FLEXIBLE CONDUIT ON ALLOWED FOR SHORT FINAL CONNECTIONS. ANY EXISTING FLEXIBLE CONDUIT TO BE REPLACED WITH RIGID CONDUIT.

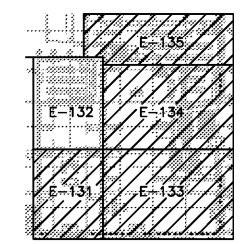

SCALE: 1/4" = 1'-0" @ FULL SIZE

OWNER:
WILLIAMS-SONOMA, INC.
3250 Van Ness Avenue
San Francisco, CA 94109
T 415 616 8602
F 415 439 8164
www.williams-sonoma.com

EEA
EEA Consulting Engineers
6615 Vaughn Ranch Road, Suite 100
Austin, Texas 78730-2314 USA
512.744.4400 main 512.744.4444 fax
www.eeace.com
State of Registration VIRGINIA
Firm Registration No. 0407 004734
EEA Project No. 20166524

BID DOCUMENT ONLY
Not Intended for Construction or Permit.
This document is released under the authority of:
Registrant's Name: SARA A. HAMILL
Serial No. 0402052431

POTTERY HALL
WILLIAMS-SONOMA
Town Center Virginia Beach
173/177 Central Park Avenue
Virginia Beach, VA 23462
PROJECT #006-151817-00/#006-151412-00

ISSUED / REVISED	DATE
FEASIBILITY SET	08/10/17
PRELIMINARY SET	09/28/17
LL CD SET	11/30/17
PERMIT SET	12/18/17
BID SET	01/04/18

KEYPLAN N.T.S.
PARTIAL LIGHTING PLAN

E-132