

D&E DOLLAR & FLOWERS
 ARCHITECTURE, INC.
 1100 Jackson Avenue, Suite 200
 Knoxville, TN 37915
 865-546-1111 • Fax: 865-673-9028
 www.dollarandflowers.com


REGISTERED PROFESSIONAL ENGINEER
 STATE OF TENNESSEE
 LICENSE NO. 77261
 JONATHAN G. CRIGG

17248 - Kroger 414, GA

NO.	REVISIONS

A With-in-the-Walls Remodel for:
KROGER STORE #GA-414
 4355 WASHINGTON ROAD, EVANS, GEORGIA 30809

SANITARY PLUMBING DEMO PLAN

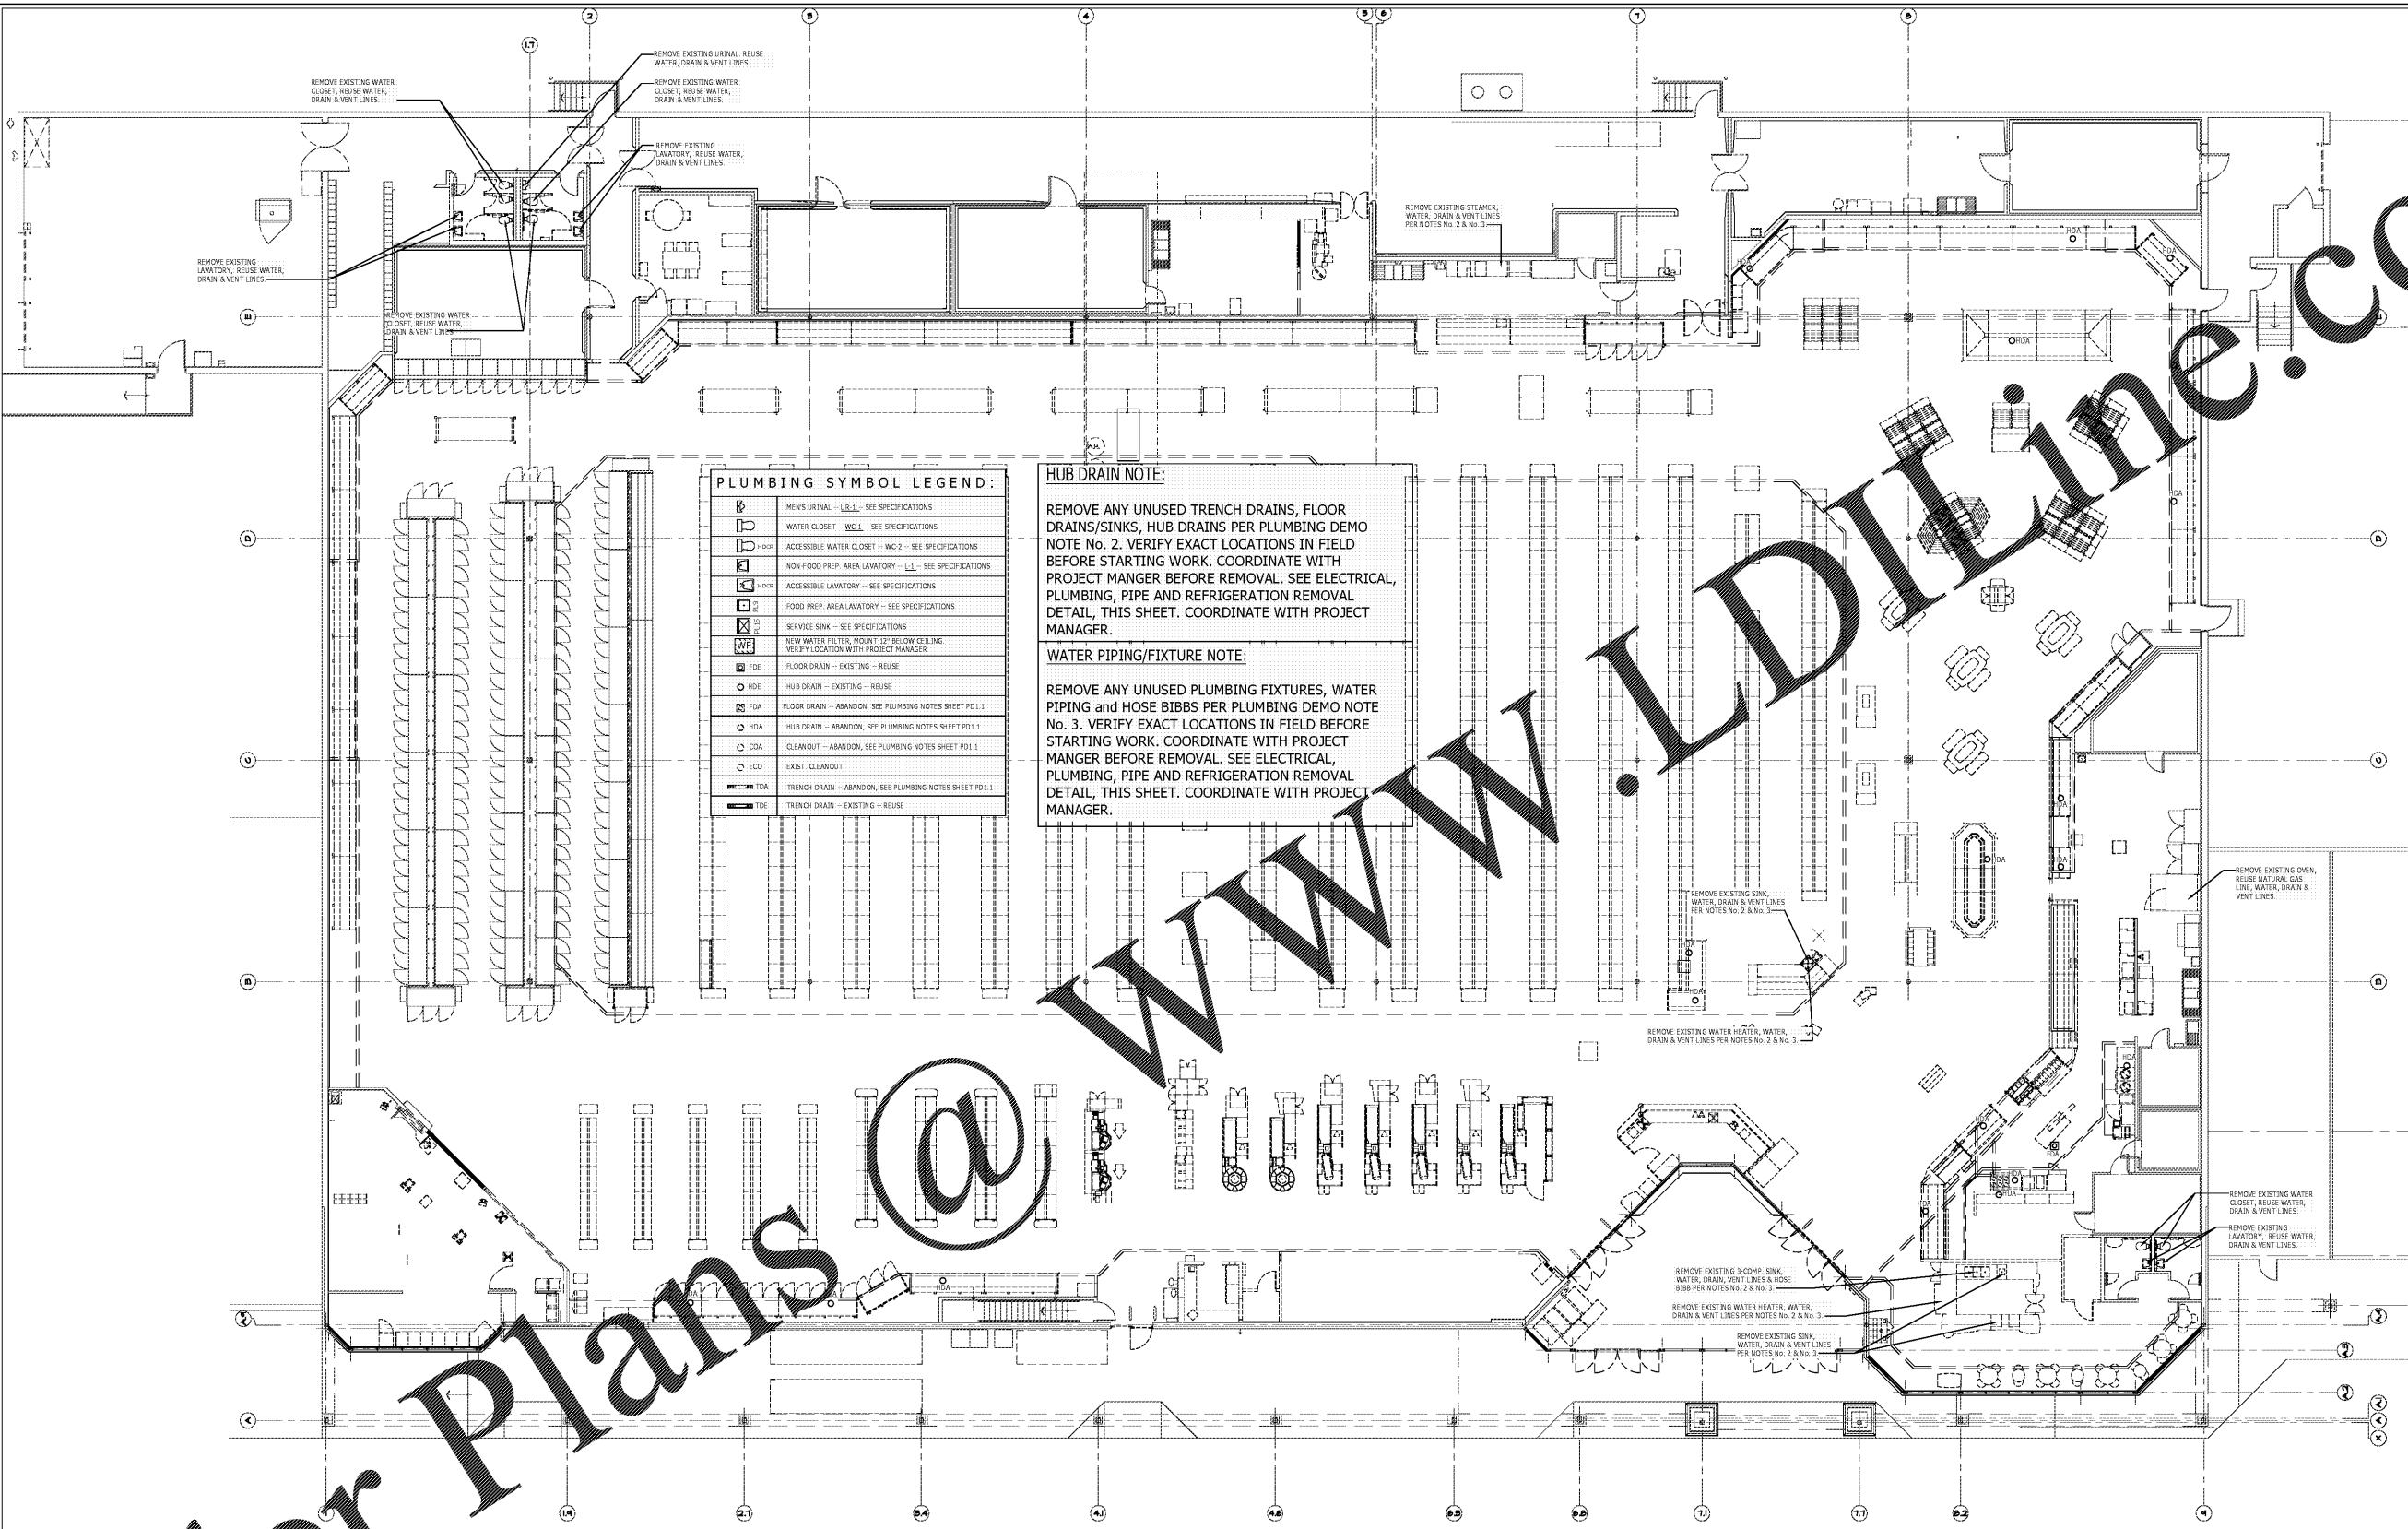

PLUMBING SYMBOL LEGEND:


MS	MEN'S URINAL - U.S. 1 - SEE SPECIFICATIONS
WC	WATER CLOSET - W.C. 1 - SEE SPECIFICATIONS
WC2	ACCESSIBLE WATER CLOSET - W.C. 2 - SEE SPECIFICATIONS
NFLA	NON-FOOD PREP. AREA LAVATORY - SEE SPECIFICATIONS
FLA	ACCESSIBLE LAVATORY - SEE SPECIFICATIONS
FLA2	FOOD PREP. AREA LAVATORY - SEE SPECIFICATIONS
SS	SERVICE SINK - SEE SPECIFICATIONS
NWF	NEW WATER FILTER, MOUNT 12" BELOW CEILING. VERIFY LOCATION WITH PROJECT MANAGER.
FDE	FLOOR DRAIN - EXISTING - REUSE
HDE	HUB DRAIN - EXISTING - REUSE
FDA	FLOOR DRAIN - ABANDON, SEE PLUMBING NOTES SHEET PD1.1
HDA	HUB DRAIN - ABANDON, SEE PLUMBING NOTES SHEET PD1.1
COA	CLEANOUT - ABANDON, SEE PLUMBING NOTES SHEET PD1.1
ECD	EXIST. CLEANOUT
TDA	TRENCH DRAIN - ABANDON, SEE PLUMBING NOTES SHEET PD1.1
TDE	TRENCH DRAIN - EXISTING - REUSE

HUB DRAIN NOTE:
 REMOVE ANY UNUSED TRENCH DRAINS, FLOOR DRAINS/SINKS, HUB DRAINS PER PLUMBING DEMO NOTE No. 2. VERIFY EXACT LOCATIONS IN FIELD BEFORE STARTING WORK. COORDINATE WITH PROJECT MANGER BEFORE REMOVAL. SEE ELECTRICAL, PLUMBING, PIPE AND REFRIGERATION REMOVAL DETAIL, THIS SHEET. COORDINATE WITH PROJECT MANAGER.

WATER PIPING/FIXTURE NOTE:
 REMOVE ANY UNUSED PLUMBING FIXTURES, WATER PIPING and HOSE BIBBS PER PLUMBING DEMO NOTE No. 3. VERIFY EXACT LOCATIONS IN FIELD BEFORE STARTING WORK. COORDINATE WITH PROJECT MANGER BEFORE REMOVAL. SEE ELECTRICAL, PLUMBING, PIPE AND REFRIGERATION REMOVAL DETAIL, THIS SHEET. COORDINATE WITH PROJECT MANAGER.

SANITARY PLUMBING DEMO PLAN
 SCALE: 3/32" = 1'-0"

- DEMOLITION NOTES:**
- EXISTING PLUMBING WORK NOT SHOWN ON THIS PLAN TO REMAIN UNCHANGED.
 - EXISTING DRAINS THAT ARE TO BE ABANDONED SHALL BE FILLED IN WITH CONCRETE FLUSH WITH SURROUNDING FLOOR. SEE HUB DRAIN/FLOOR DRAIN REMOVAL DETAIL THIS SHEET.
 - EXISTING WATER AND GAS LINES FOR EQUIPMENT NOT BEING REUSED ABOVE CEILING OR BELOW FLOOR, SHALL BE CAPPED OFF. EXISTING UNUSED WATER LINES SHALL BE TRACED THEN CAPPED OFF ABOVE FLOOR BEFORE PENETRATING FLOOR. NO PRESSURIZED LINES SHALL REMAIN BELOW FLOOR. REMOVE ALL UNUSED PIPING IN SALES AREA. EXISTING WATER AND GAS LINES FOR EQUIPMENT NOT BEING REUSED SHALL BE CAPPED OFF ABOVE CEILING WHEN POSSIBLE.
 - EXISTING VENT LINES FOR EQUIPMENT NOT BEING REUSED, SHALL BE CAPPED OFF ABOVE CEILING OR BELOW SLAB. EXISTING UNUSED VENT LINES SHALL BE TRACED THEN CAPPED OFF ABOVE FLOOR BEFORE PENETRATING FLOOR. REMOVE ALL UNUSED PIPING IN SALES AREA.
 - REMOVE AS FIELD CONDITIONS WARRANT EXISTING PLUMBING WORK NOT SHOWN.
 - ALL EXISTING EQUIPMENT NOT REUSED WILL REMAIN THE PROPERTY OF THE OWNER AND BE DISPOSED OF AS DIRECTED.
 - COORDINATE DRAINS WITH ARCHITECTURAL PLANS. DRAINS NOT BEING REUSED SHALL BE CORED AND FILLED UNLESS PART OF LARGER CONCRETE REPLACEMENT AREA.

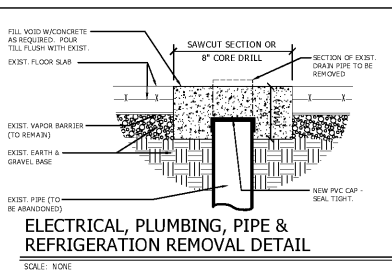

PIPING LEGEND:

GW	NEW GREASE PIPING
SW	NEW SEWER PIPING
ES	EXIST. SEWER PIPING
EW	EXIST. TEMPERED WATER PIPING
EWG	EXIST. GREASE WASTE PIPING
EWHR	EXIST. HOT WATER RETURN
ECW	EXIST. COLD WATER PIPING
EHW	EXIST. HOT WATER PIPING
NG	NEW NATURAL GAS PIPING
ENG	EXIST. N.G. PIPING
VPE	EXIST. VENT PIPING
X	PIPING TO BE ABANDONED. SEE DEMOLITION NOTES, SHEET PD1.1

COPYRIGHT

ISSUE DATE: JANUARY 29, 2017
 PROJECT NO: 217156
 SHEET NUMBER: PD1.1

JGC
 Jonathan G. Crigg
 Consulting Engineer
 225 BRIDLE LANE, SUITE 111
 KNOXVILLE, TENNESSEE 37912
 PHONE: (865) 598-5248 FAX: (865) 247-0210
 CELL: (865) 598-5248

Order Plans @