


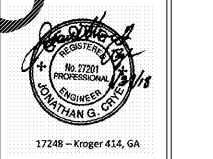

17248 - Kroger 414, GA




NO.	REVISIONS

STARBUCKS WASTE AND VENT PLAN

KROGER STORE #GA-414
4355 WASHINGTON ROAD, EVANS, GEORGIA 30809

REFERENCE ONLY, SEE SHEET P1.1 FOR SCOPE OF WORK

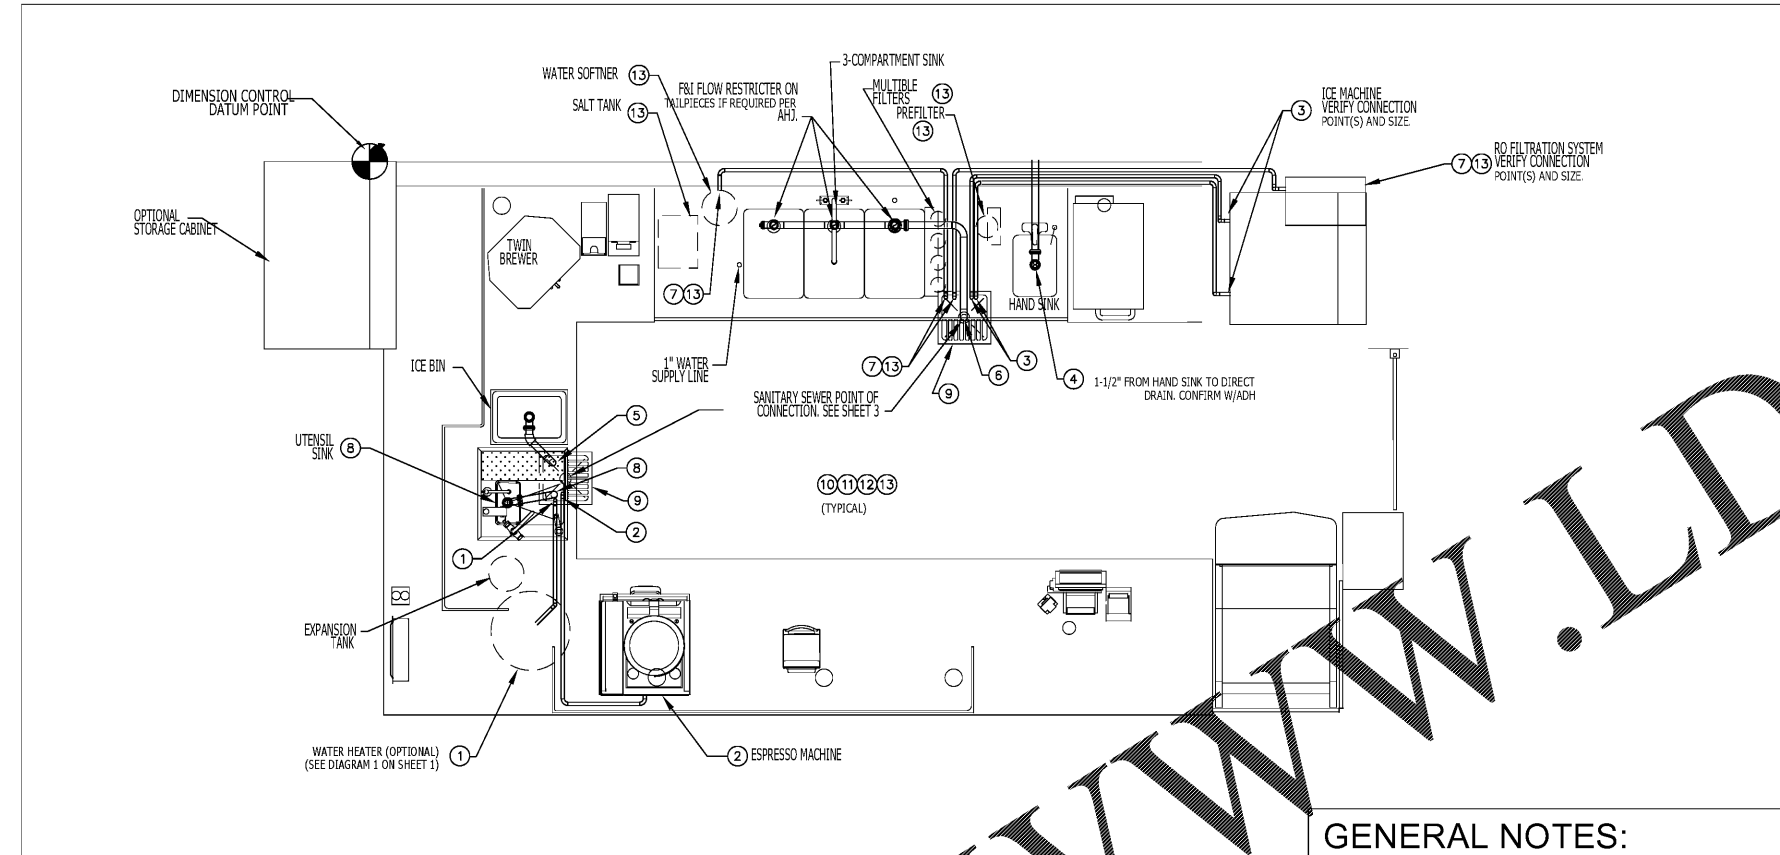

- KEY NOTES:**
- 1 WATER HEATER (OPTIONAL): FURNISH AND INSTALL (F&I) 3/4" PRESSURE RELIEF DRAIN PIPE INDIRECT TO FLOOR SINK.
 - 2 ESPRESSO MACHINE(S): F&I 1" PIPE FROM DRAIN TRAY(S) INDIRECT TO FLOOR SINK. PROVIDE TREADED DRAIN TRAY PIPE COUPLING.
 - 3 ICE MACHINE: F&I (2) SEPERATE 3/4" INSULATED DRAINS INDIRECT TO FLOOR SINK. DO NOT INTERCONNECT LINES.
 - 4 HAND SINK: F&I 1-1/2" DIRECT DRAIN.
 - 5 ICE BIN: F&I 1-1/2" INSULATED DRAIN PIPE INDIRECT TO FLOOR SINK.
 - 6 3-COMPARTMENT SINK: F&I 1-1/2" DRAIN PIPE ASSEMBLY INDIRECT TO FLOOR SINK.
 - 7 WATER FILTER/CONDITIONER EQUIPMENT: F&I 3/8" TEEING INDIRECT TO FLOOR SINK.
 - 8 UTENSIL SINK: F&I 1-1/2" DRAIN PIPE INDIRECT TO FLOOR SINK.
 - 9 FLOOR SINK: CONTRACTOR SHALL F&I 3" FLOOR SINK (AND ALL ASSOCIATED PIPING, INCLUDING P-TRAP, VENT & WASTE PIPING) AND CONNECT TO SANITARY & VENT PIPING PER AHJ.
 - 10 BACKFLOW PREVENTERS: F&I WHEN REQUIRED BY AHJ. F&I ANY NEEDED PIPING FROM BACKFLOW DEVICE DRAINS INDIRECT TO FLOOR SINKS (TYP)(NOT SHOWN).
 - 11 ALL SINK TAIL PIECES TO BE TYPE ABS UP TO AND INCLUDING THREADED COUPLING TO BASKET STRAINERS AT ALL SINKS.
 - 12 F&I ADDITIONAL PIPING INDIRECT TO DRAINS AS NEEDED (NOT SHOWN).
 - 13 CONFIRM PIPING WITH LAURENCE.PINKERTON@PENTAIR.COM CONTACT# 310-292-9080

- GENERAL NOTES:**
- A F&I A COMPLETE AND OPERATING SYSTEM. ALL ITEMS ARE NOT NECESSARILY SHOWN.
 - B FOR FULL SCHEDULES AND COMPLETE LISTING SEE SCHEDULES. CONFIRM ALL QUANTITIES WITH PLAN.
 - C PLUMBING CONTRACTOR RESPONSIBLE FOR SITE INVESTIGATION PRIOR TO START OF WORK TO REVEAL FULL SCOPE OF WORK.
 - D COORDINATE WITH ELECTRICAL CONTRACTOR FOR POWER CONNECTION TO ALL PLUMBING EQUIPMENT.
 - E DIMENSIONS ARE TO FACE UNLESS OTHERWISE NOTED.
 - F ALL INDIRECT DRAIN LINES SHALL BE ROUTED WITHOUT DIPS OR SAGS TO TERMINATE WITH AN AIR GAP INTO AN APPROVED INDIRECT WASTE RECEPTOR.
 - G REFER TO DETAILS FOR FURTHER REQUIREMENTS.

SHORT LEFT HAND BASE - SANITARY PLAN

NOTE:
ALL PLUMBING MUST BE DONE IN ACCORDANCE WITH LOCAL CODES.

WHERE "COORDINATE", "VERIFY" OR "CONFIRM" ARE NOTED, IT SHALL BE DONE BEFORE BID.

NO.	REV. NO.	REVISION	DATE:	BY:

PROPRIETARY INFORMATION DO NOT DUPLICATE ALL RIGHTS RESERVED DIMENSIONS ARE IN INCHES TOLERANCES UNLESS NOTED
FRAC. TOL. ± 1/32
DEC. TOL. ± .01
ANGULAR TOL. ± .5°
DO NOT SCALE DRAWING

PLK INDUSTRIES 1357 WEST BEAVER STREET P.O. BOX 40606 JACKSONVILLE, FL 32203-0606A DIVISION OF LOAD KING MFG.

PLUMBING SANITARY, LH, SHORT, CUSTOM, V3

SIZE: B DRN. BY: AC DATE: 11/05/15 SCALE: 1/2"=1'

PART NO. SBX-902-500-0001-A
SHT: 2 of 3 REV. 0
DOCUMENT NO. SBX-902-501-0000-A

ALL INFORMATION CONTAINED IN OR DISCLOSED BY THIS DOCUMENT IS CONSIDERED CONFIDENTIAL AND PROPRIETARY BY LOAD KING MFG. COMPANY. ALL DESIGN, MANUFACTURING, USE, REPRODUCTION, AND ALL SALES RIGHTS, ARE EXPRESSLY RESERVED BY AND TO LOAD KING MFG. COMPANY AND COMMUNICATION OF THIS INFORMATION TO OTHERS IS PROHIBITED WITHOUT THE PRIOR WRITTEN CONSENT OF LOAD KING MFG. COMPANY.

Order Plans

DATE:	DESIGN BY:	DATE:	DATE:	DATE:

JGC
Jon G. Cray
Consulting Engineer

201 SHILOH LANE, SUITE 111
SPRING LAKE, NC 27982
PHONE: (800) 588-5246
FAX: (800) 247-0270
EMAIL: jgc@jgc-engineering.com

COPYRIGHT
ALL DRAWINGS, SPECIFICATIONS AND OTHER INFORMATION CONTAINED HEREIN ARE THE PROPERTY OF JGC AND SHALL REMAIN THE PROPERTY OF JGC AND NOT BE REPRODUCED OR TRANSMITTED IN ANY FORM OR BY ANY MEANS, ELECTRONIC OR MECHANICAL, INCLUDING PHOTOCOPYING, RECORDING, OR BY ANY INFORMATION STORAGE AND RETRIEVAL SYSTEM, WITHOUT THE EXPRESS WRITTEN PERMISSION OF JGC. THIS AGREEMENT SHALL BE GOVERNED BY THE LAWS OF THE STATE OF NORTH CAROLINA. ANY DISPUTE ARISING FROM THIS AGREEMENT SHALL BE REFERRED TO THE JURISDICTION OF THE COURTS OF THE STATE OF NORTH CAROLINA. THIS AGREEMENT SHALL BE GOVERNED BY THE LAWS OF THE STATE OF NORTH CAROLINA. ANY DISPUTE ARISING FROM THIS AGREEMENT SHALL BE REFERRED TO THE JURISDICTION OF THE COURTS OF THE STATE OF NORTH CAROLINA.

COPYRIGHT

ISSUE DATE: JANUARY 29, 2017
PROJECT NO: 217156
SHEET NUMBER: P 1.1.1