


Order Plans @

WWW.LDILine.com

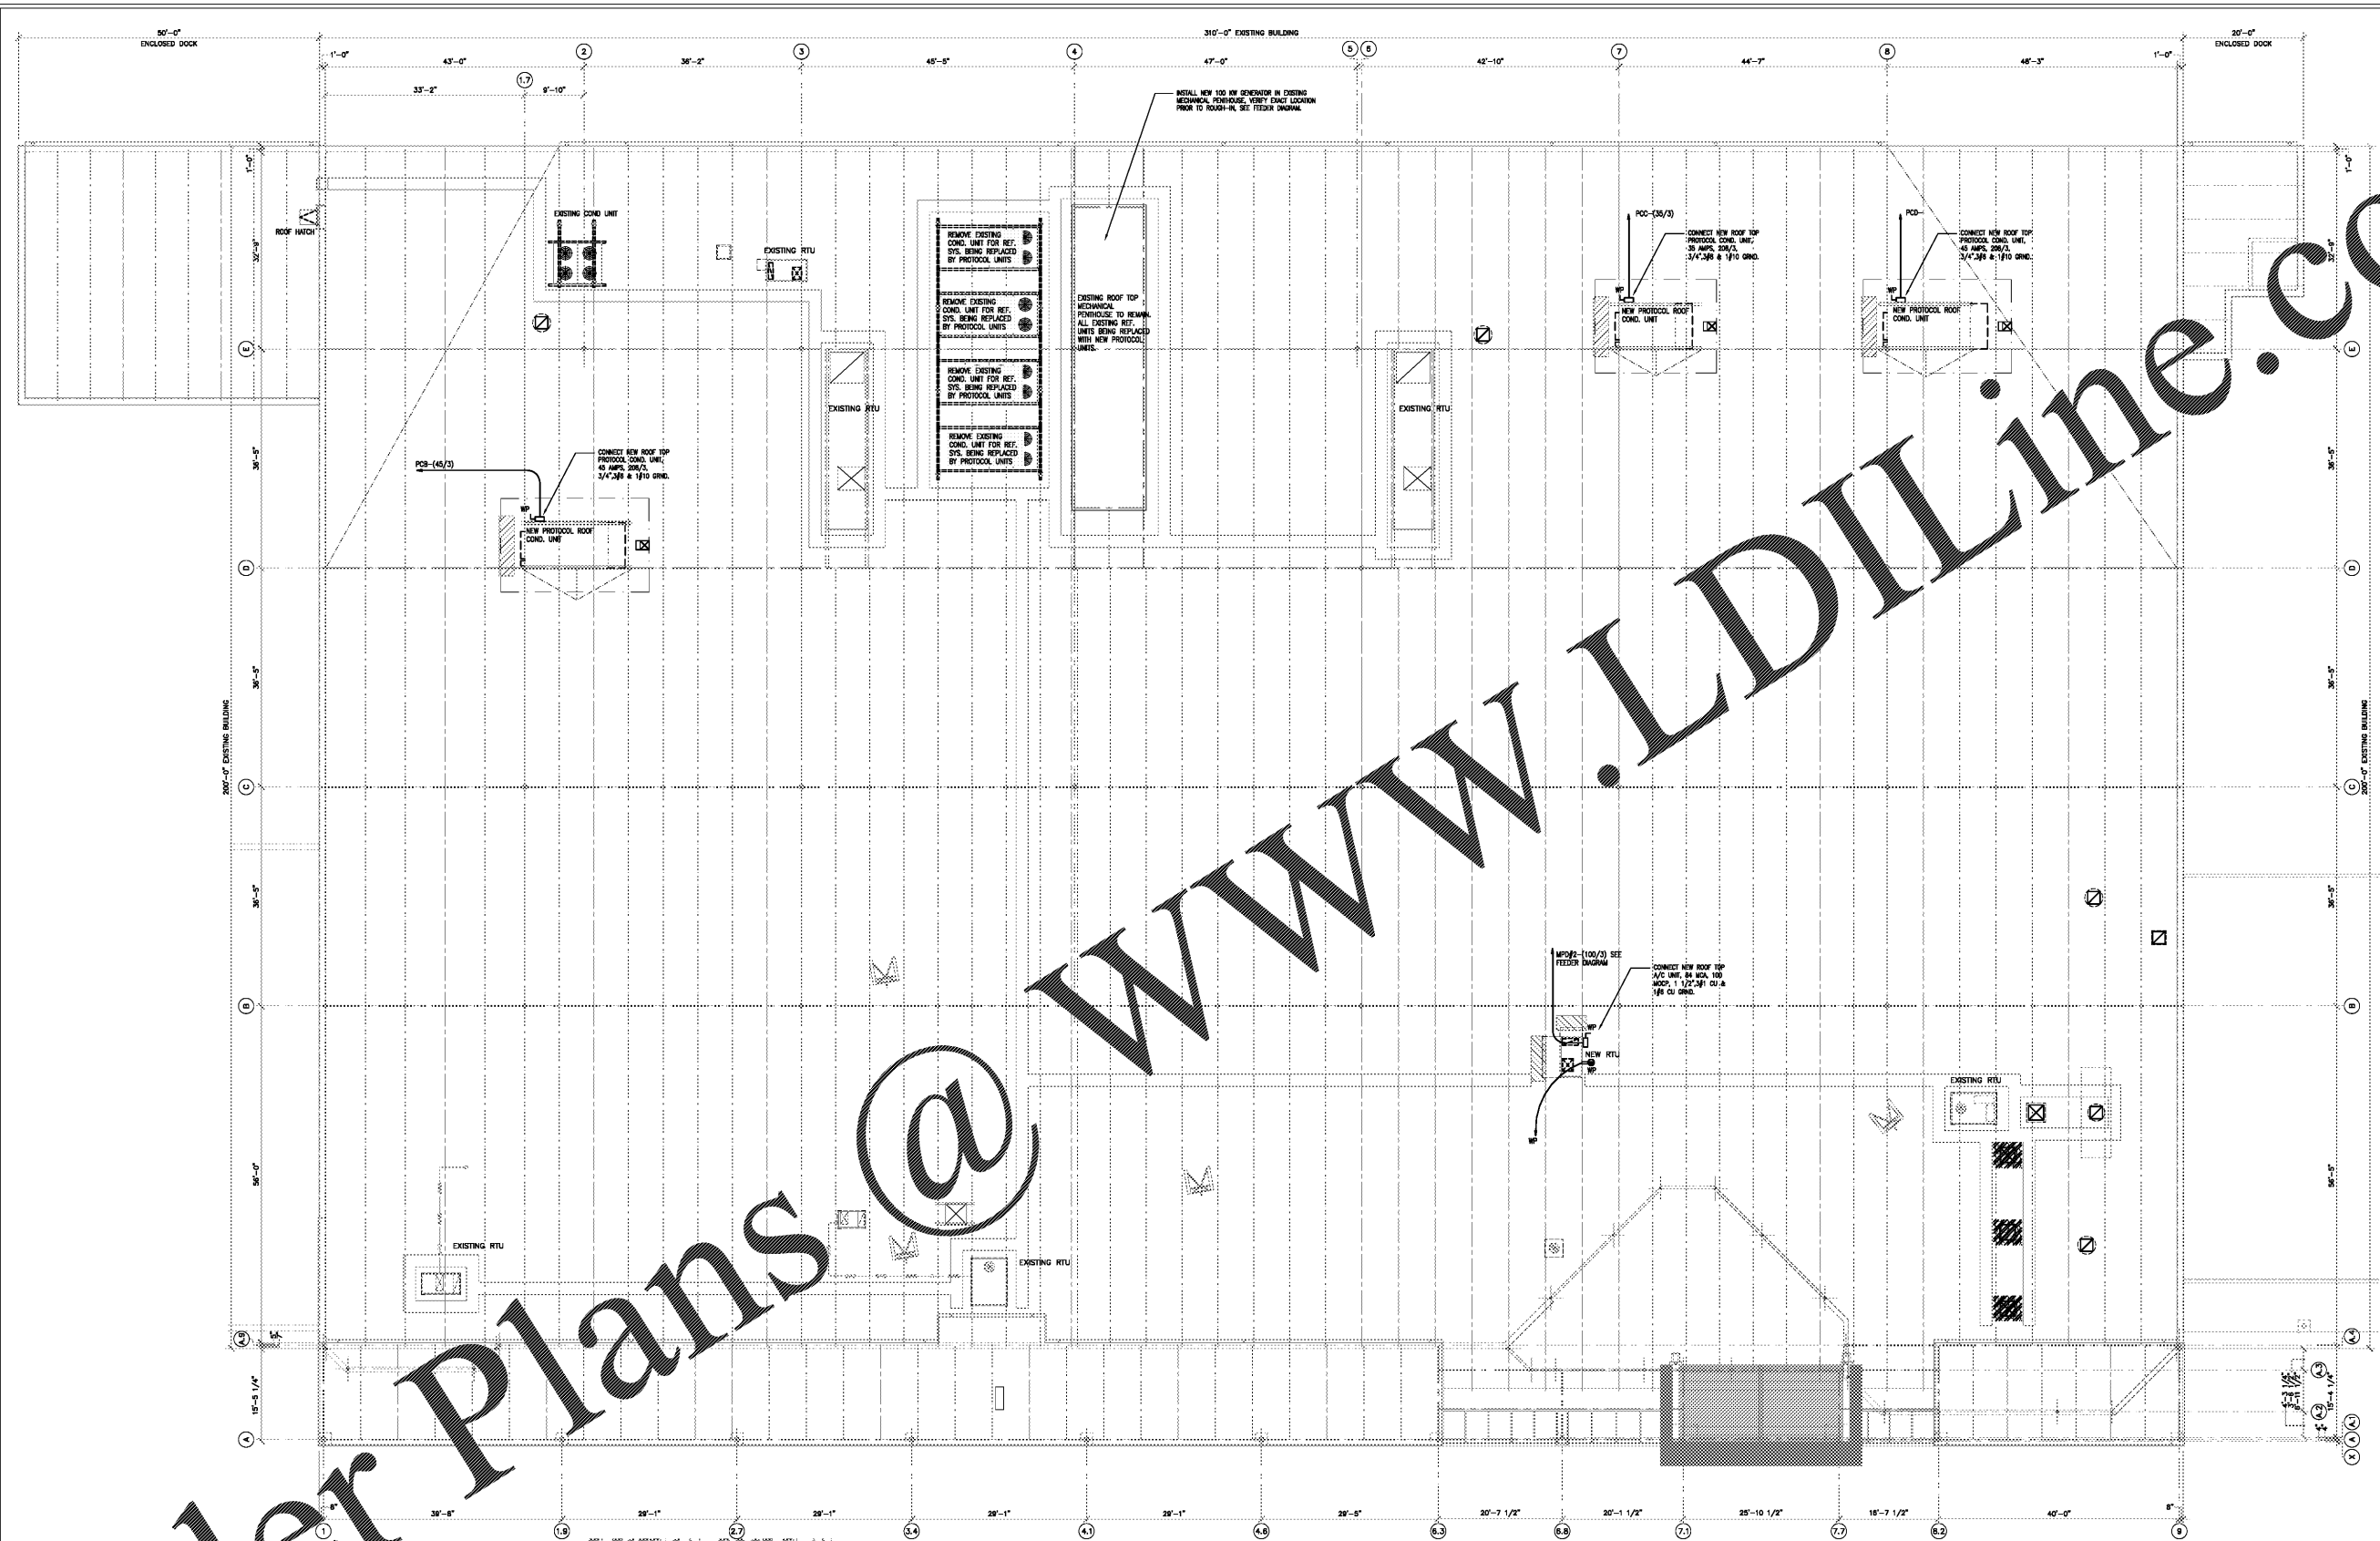

ELECTRICAL ROOF PLAN
SCALE: 5/8" = 1'-0"



ARCHITECTURE, INC.
101 E. Jackson Avenue, Suite 101
Knoxville, Tennessee 37915
Phone: 615-546-1111 • Fax: 615-673-9028
e-mail: info@dollarandfewers.com



NO.	REVISIONS

A With-in-the-Walls Remodel for:
KROGER STORE #GA-414
4355 WASHINGTON ROAD, EVANS, GEORGIA 30809
ELECTRICAL ROOF PLAN

COPYRIGHT
All copyright and other notices and legends herein of the original owner of the drawings are hereby acknowledged and the same are not to be removed, altered or in any way obscured by the reproduction of these drawings. The reproduction of these drawings without the express written consent of the original owner is prohibited. The reproduction of these drawings for any other purpose than that for which they were originally prepared is prohibited. The reproduction of these drawings for any other purpose than that for which they were originally prepared is prohibited.
COPYRIGHT

ISSUE DATE: JANUARY 29, 2018
PROJECT NO: 217156 / 17098
SHEET NUMBER: E1.4

KEVIN E. NORRIS
ELECTRICAL ENGINEER
3815 WALLWOOD ROAD
KNOXVILLE, TN 37918
PHONE: 615-546-1111