


KEY NOTES

① FIRE PROTECTION AREA OF WORK.

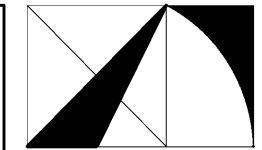


THE ARCHITECTURE GROUP, INC.

377 Peachtree St. N.E.
Atlanta, GA 30303
Phone: (678) 222-0375
Fax: (678) 222-0384
tag@architecturegroup.com

COPYRIGHT © 2018 BY THE ARCHITECTURE GROUP, INC. ALL RIGHTS RESERVED.

THIS DRAWING MAY NOT BE USED IN ANY MANNER NOR REPRODUCED IN ANY FORM WITHOUT PRIOR WRITTEN CONSENT FROM THE ARCHITECTURE GROUP INC.

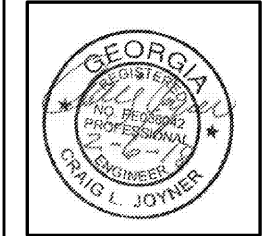


2018 MRRF CAMPUS-WIDE
ADA IMPROVEMENTS
PROJECT No. IGSU-026-18
TAG PROJECT No. 1706
GEORGIA STATE UNIVERSITY
ATLANTA, GEORGIA

| | |
|----------------|----------|
| 100% CDs | 2/5/2017 |
| REVISIONS | |
| DATE | 2/5/2017 |
| DRAWN BY | |
| CHECKED | |
| APPROVED | |
| SCALE | AS NOTED |
| PROJECT NUMBER | 1706 |
| DRAWING TITLE | |

FIRE PROTECTION - HAAS HOWELL BLDG - 7TH FLOOR

DRAWING NUMBER

HH FP1.2

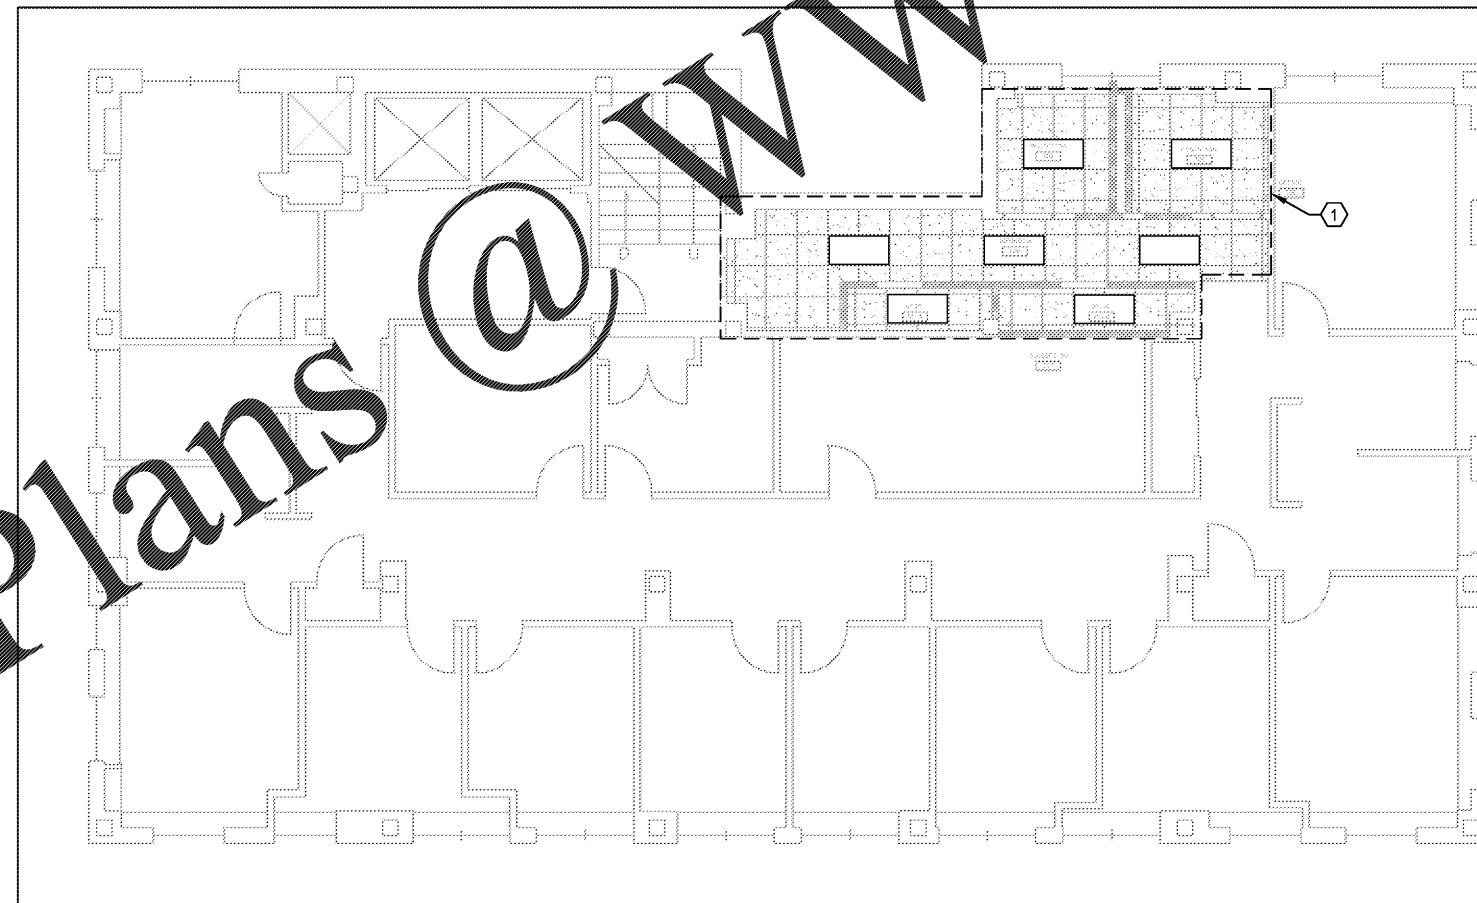

① FIRE PROTECTION PLAN - 7TH FL
SCALE: 1/8"=1'-0"



SPENCER BRISTOL ENGINEERING, INC.
A Gray Company
3577 PARKWAY LANE, SUITE 250
PEACHTREE CORNERS, GEORGIA 30092
TEL. 770.414.1628 FAX 770.414.6024
SBE Project No. 1744

Order Plans @ WWW.LDILine.com