


KEY NOTES

① FIRE PROTECTION AREA OF WORK.

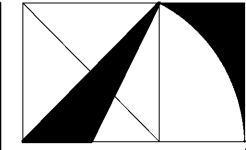


THE ARCHITECTURE GROUP INC.

380 Venable St.  
Atlanta, GA 30303  
Phone: (678) 222-0375  
Fax: (678) 222-0384  
tag@thearchitecturegroup.com

© 2018 BY THE ARCHITECTURE GROUP, INC. ALL RIGHTS RESERVED.

THIS DRAWING MAY NOT BE USED IN ANY MANNER NOR REPRODUCED IN ANY FORM WITHOUT PRIOR WRITTEN CONSENT FROM THE ARCHITECTURE GROUP INC.

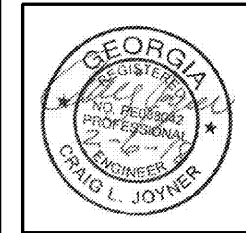

2018 MRRF CAMPUS-WIDE ADA IMPROVEMENTS

PROJECT No. IGSU-026-18


TAG PROJECT No. 1706

GEORGIA STATE UNIVERSITY  
ATLANTA, GEORGIA

100% CDs	2/5/2017
REVISIONS	
DATE	2/5/2017
DRAWN BY	
CHECKED	
APPROVED	
SCALE	AS NOTED
PROJECT NUMBER	1706
DRAWING TITLE	

**FIRE PROTECTION PLAN - NORTH LIBRARY**

DRAWING NUMBER  
**LN FP1.1**

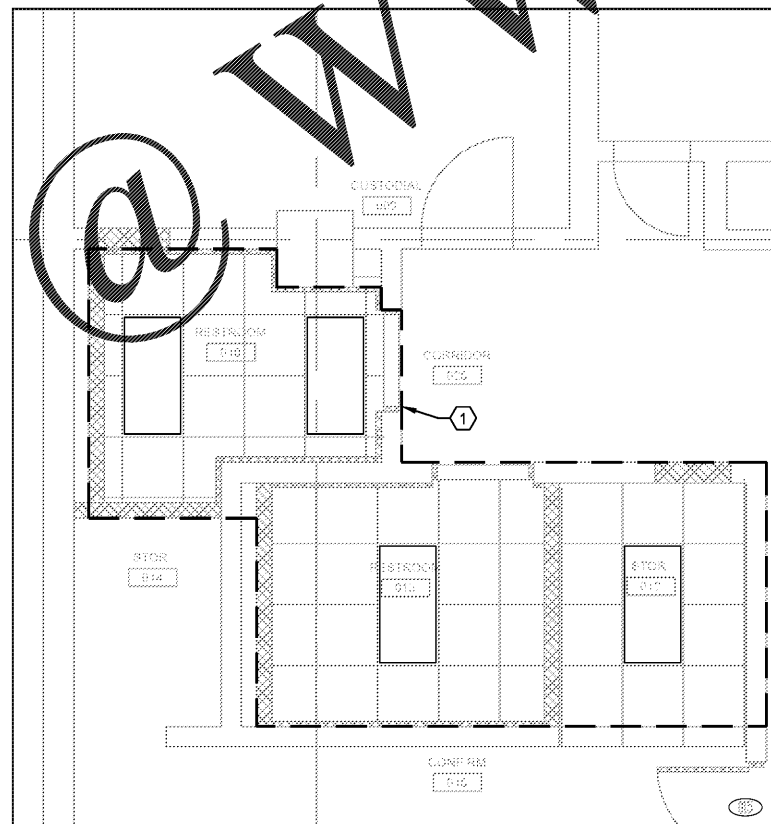

① FIRE PROTECTION PLAN  
SCALE: 1/4"=1'-0"

**Spencer Bristol Engineering, Inc.**  
A Gray Company  
3577 PARKWAY LANE, SUITE 250  
PEACHTREE CORNERS, GEORGIA 30092  
TEL. 770.414.1628 FAX 770.414.6024  
SBE Project No. 1714

Order Plans

@

WWW.LDILine.com