
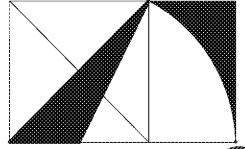


GENERAL NOTES:

1. FIRE ALARM DEVICES SHOWN IN LIGHT PENWEIGHT ARE EXISTING TO REMAIN. ELECTRICAL DEVICES SHOWN IN HEAVY PENWEIGHT ARE NEW UNLESS OTHERWISE NOTED.
2. CONNECT NEW FIRE ALARM DEVICES TO EXISTING BUILDING FIRE ALARM SYSTEM. NEW FIRE ALARM DEVICES SHALL BE MANUFACTURED BY SIMPLEX. FIELD VERIFY EXISTING SYSTEM LOCATION AND THAT IT IS ADEQUATE FOR NEW FIRE ALARM DEVICES.

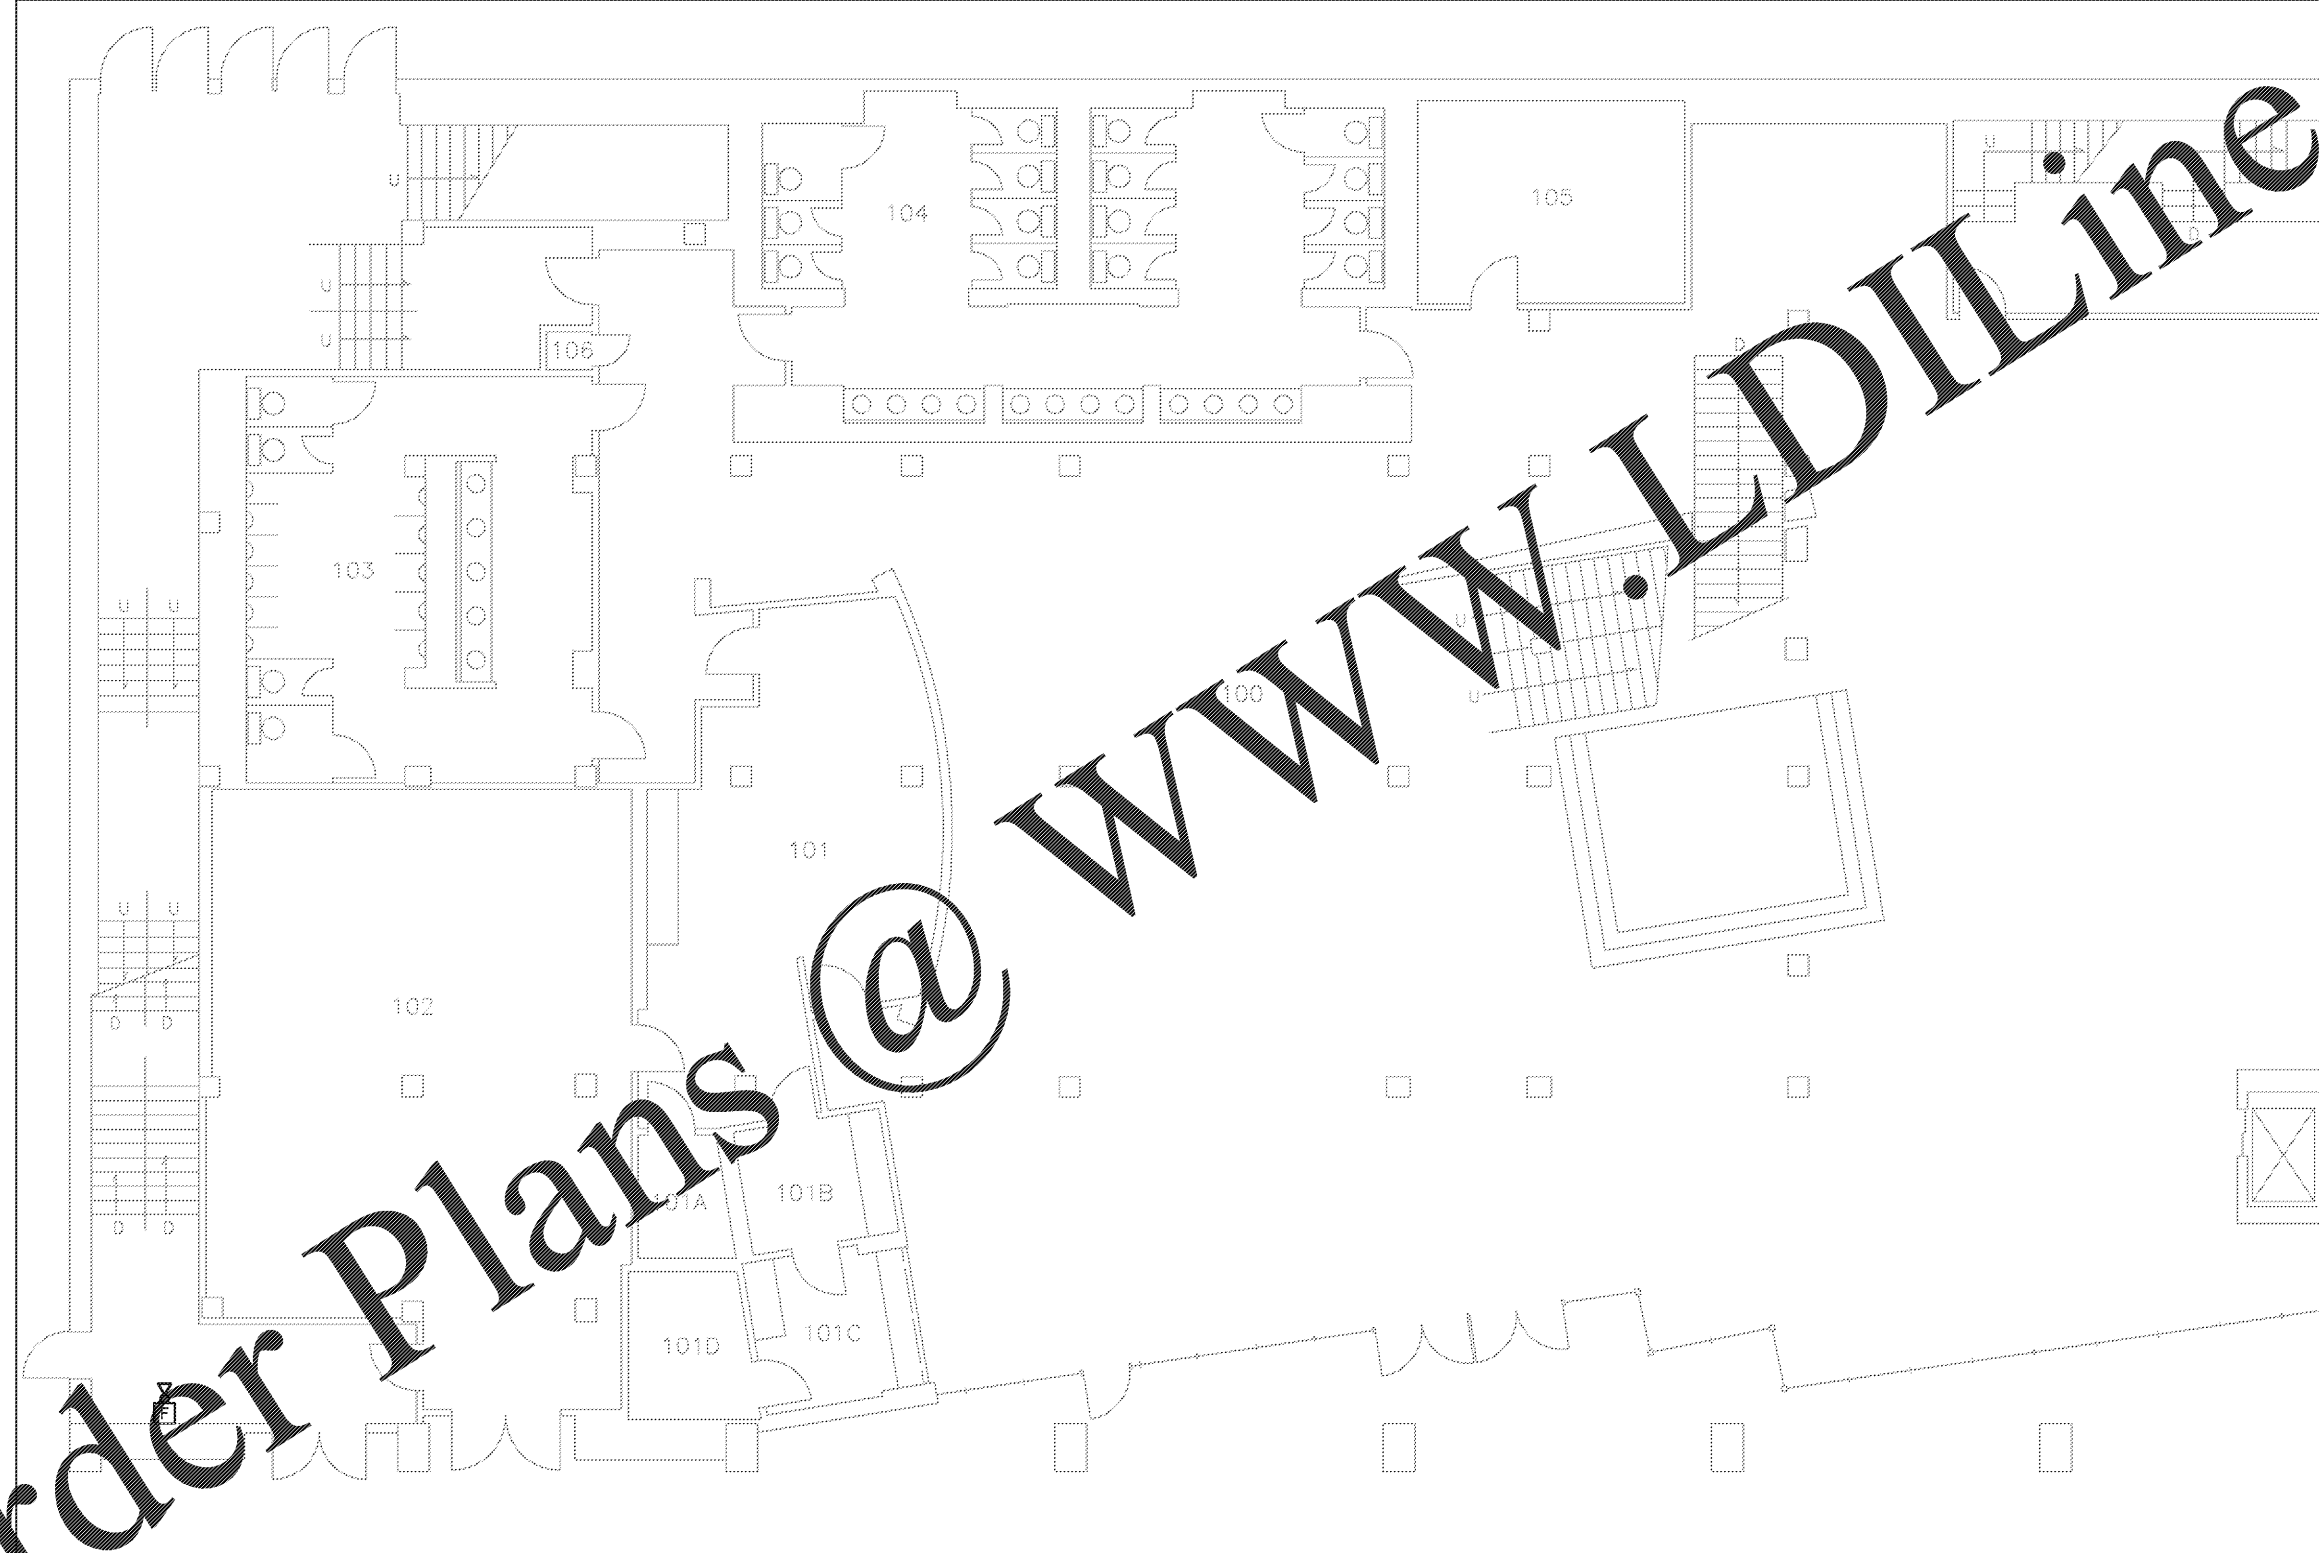


THE ARCHITECTURE GROUP, INC.

375 Peachtree St.
Atlanta, GA 30303
Phone: (678) 222-0375
Fax: (678) 222-0384
tag@architecturegroup.com

COPYRIGHT © 2018 BY THE ARCHITECTURE GROUP, INC. ALL RIGHTS RESERVED.

THIS DRAWING MAY NOT BE USED IN ANY MANNER NOR REPRODUCED IN ANY FORM WITHOUT PRIOR WRITTEN CONSENT FROM THE ARCHITECTURE GROUP INC.

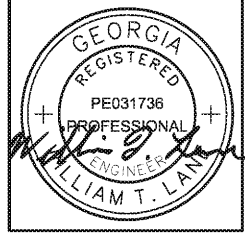

**2018 MRRF CAMPUS-WIDE
ADA IMPROVEMENTS**
PROJECT No. IGSU-026-18
TAG PROJECT No. 1706
GEORGIA STATE UNIVERSITY
ATLANTA, GEORGIA

| | |
|----------------|----------|
| 100% CD# | 2/5/2017 |
| REVISIONS | |
| DATE | 2/5/2017 |
| DRAWN BY | |
| CHECKED | |
| APPROVED | |
| SCALE | AS NOTED |
| PROJECT NUMBER | 1706 |
| DRAWING TITLE | |

ELECTRICAL SYSTEMS - RIALTO BLDG

DRAWING NUMBER
RO E1.1

Order Plans @ www.LDILine.com

1 ELECTRICAL SYSTEMS PLAN - 1ST FL
SCALE: 1/8"=1'-0"

SPENCER BRISTOL ENGINEERING, INC.
A Gray Company
3577 Parkway Lane, Suite 250
Peachtree Corners, Georgia 30092
Tel. 770.414.1628 Fax 770.414.6024
SBE Project No. 1744