


KEY NOTES

① FIRE PROTECTION AREA OF WORK.

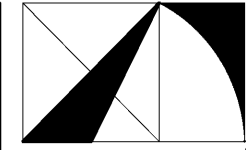


THE ARCHITECTURE GROUP INC.

380 Venable St.
Atlanta, GA 30303
Phone: (678) 222-0375
Fax: (678) 222-0384
tag@thearchitecturegroup.com

© COPYRIGHT © 2015 BY THE ARCHITECTURE GROUP, INC. ALL RIGHTS RESERVED.

THIS DRAWING MAY NOT BE USED IN ANY MANNER NOR REPRODUCED IN ANY FORM WITHOUT PRIOR WRITTEN CONSENT FROM THE ARCHITECTURE GROUP INC.

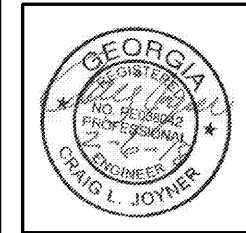

2018 MRRF CAMPUS-WIDE
ADA IMPROVEMENTS
PROJECT No. IGSU-026-18
TAG PROJECT No. 1706
GEORGIA STATE UNIVERSITY
ATLANTA, GEORGIA

100% CDs	2/5/2017
REVISIONS	
DATE	2/5/2017
DRAWN BY	
CHECKED	
APPROVED	
SCALE	AS NOTED
PROJECT NUMBER	1706
DRAWING TITLE	


**FIRE PROTECTION PLAN - SC BLDG
DECATUR CAMPUS**

DRAWING NUMBER


SC FP1.1



Spencer Bristol
ENGINEERING, Inc.
A Gray Company
3577 PARKWAY LANE, SUITE 250
PEACHTREE CORNERS, GEORGIA 30092
TEL. 770.414.1628 FAX 770.414.6024
SBE Project No. 17144

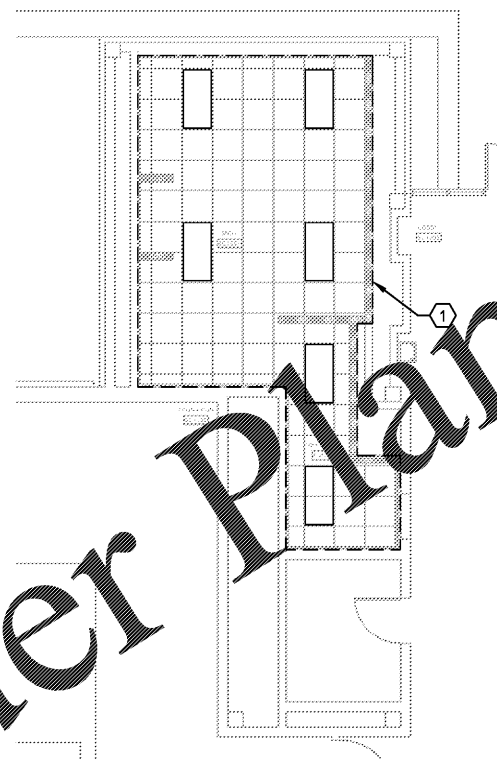

① FIRE PROTECTION PLAN
SCALE: 1/8"=1'-0"

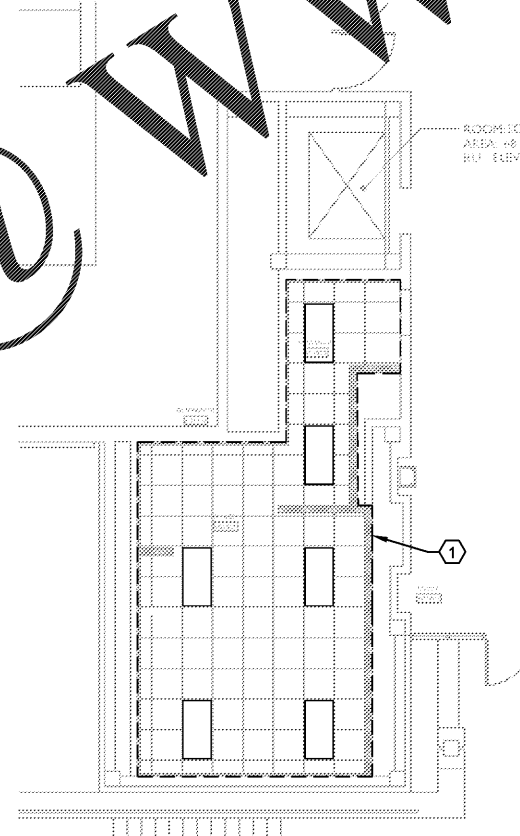

② FIRE PROTECTION PLAN
SCALE: 1/8"=1'-0"

Order Plans @

www.LDILine.com