


**KEY NOTES (FOR 1/UL M1.1 ONLY):**


- ① SA DIFFUSER SHALL BE RELOCATED. REFERENCE 2/UL M1.1 FOR NEW LOCATION.
- ② EA GRILLE SHALL BE RELOCATED. REFERENCE 2/UL M1.1 FOR NEW LOCATION.
- ③ EXISTING EXHAUST GRILLE AND DUCT TO REMAIN.

**KEY NOTES (FOR 2/UL M1.1 ONLY):**


- ① RE-INSTALL SUPPLY AIR DIFFUSER AS SHOWN.
- ② RE-INSTALL EXHAUST AIR GRILLE AS SHOWN.

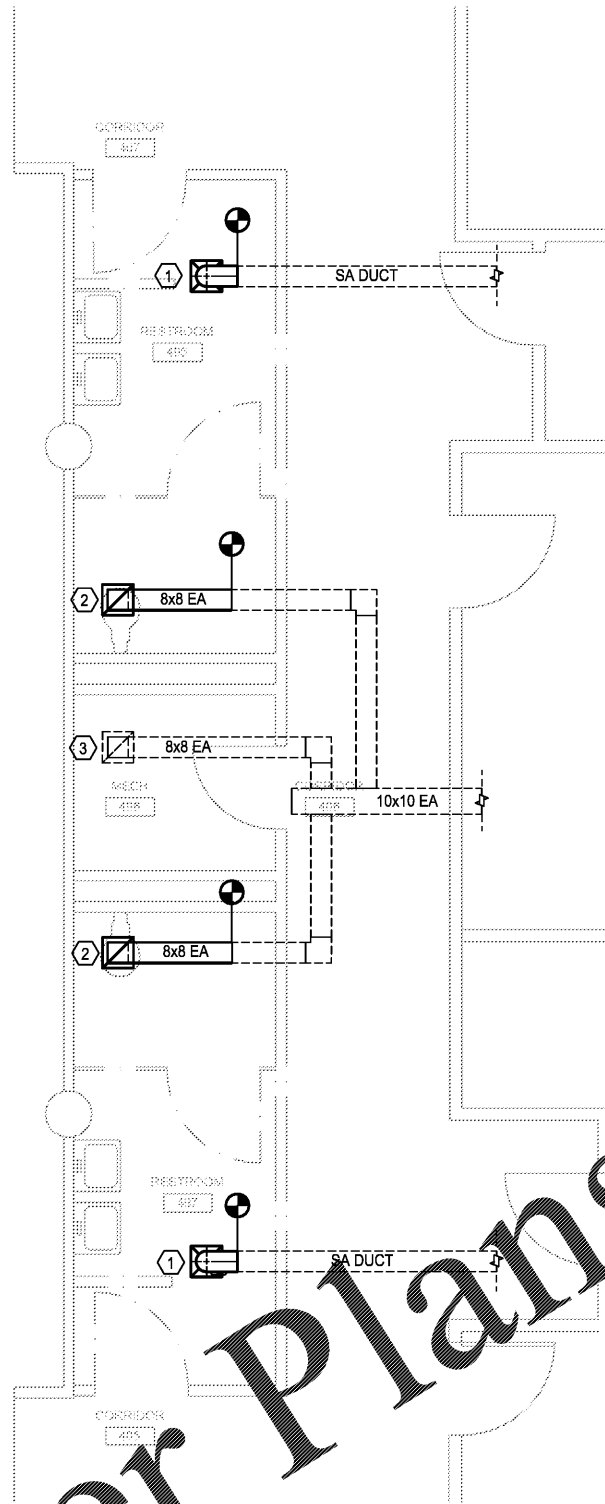

① MECHANICAL DEMO PLAN - 4TH FL  
SCALE: 1/4"=1'-0"

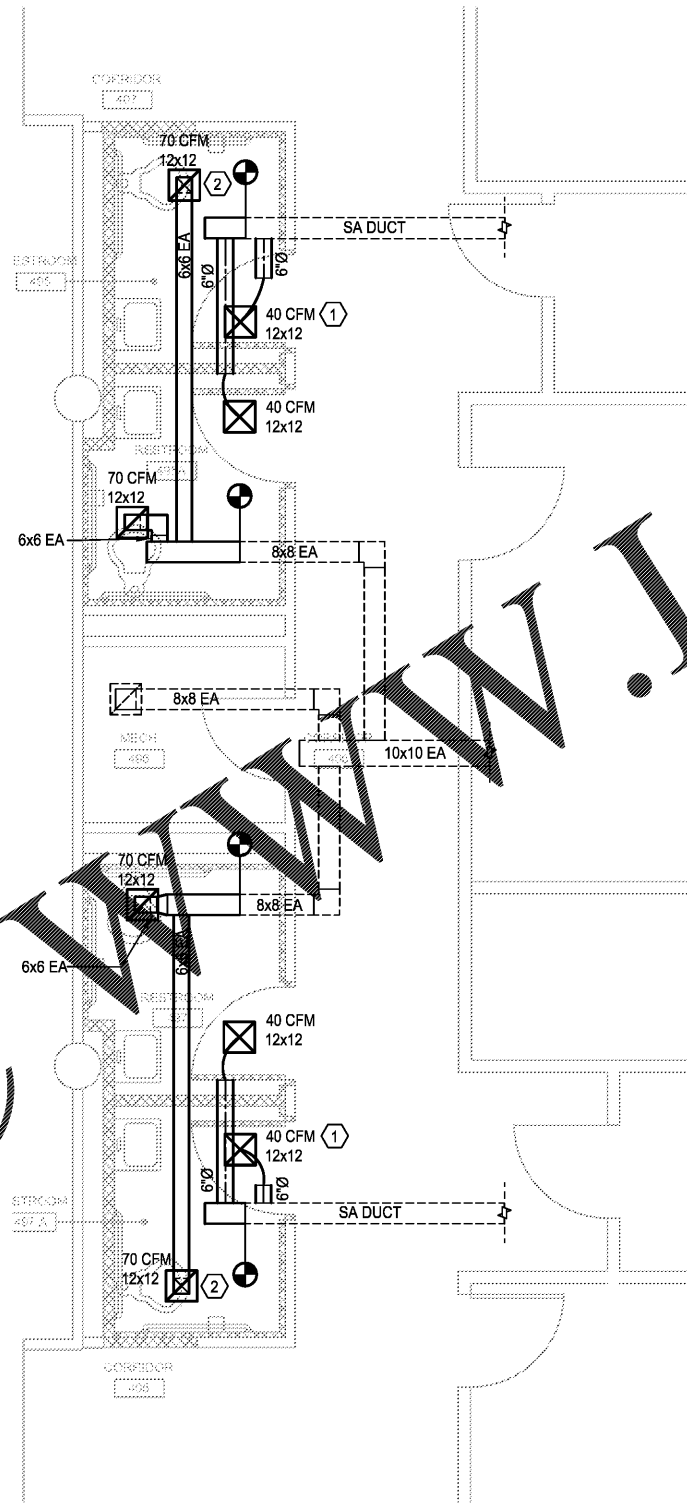

② MECHANICAL NEW PLAN - 4TH FL  
SCALE: 1/4"=1'-0"

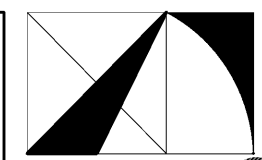

**THE ARCHITECTURE GROUP, INC.**

377 Peachtree St.  
Atlanta, GA 30303  
Phone: (678) 222-0375  
Fax: (678) 222-0384  
tag@architecturegroup.com

COPYRIGHT © 2018 BY THE ARCHITECTURE GROUP, INC. ALL RIGHTS RESERVED.

THIS DRAWING MAY NOT BE USED IN ANY MANNER NOR REPRODUCED IN ANY FORM WITHOUT PRIOR WRITTEN CONSENT FROM THE ARCHITECTURE GROUP, INC.



2018 MRRF CAMPUS-WIDE  
ADA IMPROVEMENTS  
PROJECT No. IGSU-026-18  
TAG PROJECT No. 1706  
GEORGIA STATE UNIVERSITY  
ATLANTA, GEORGIA

100% CDs	2/5/2017
REVISIONS	
DATE	2/5/2017
DRAWN BY	
CHECKED	
APPROVED	
SCALE	AS NOTED
PROJECT NUMBER	1706
DRAWING TITLE	

**MECHANICAL PLAN - URBAN LIFE**

DRAWING NUMBER

**UL M1.1**

**SPENCER BRISTOL ENGINEERING, INC.**  
A Gray Company  
3777 PARKWAY LANE, SUITE 250  
PEACHTREE CORNERS, GEORGIA 30092  
TEL. 770.414.1628 FAX 770.414.6024  
SBE Project No. 1744

Order Plans @ WWW.LDOnline.com