


1 ELECTRICAL DEMO PLAN - 4TH FL
SCALE: 1/4"=1'-0"

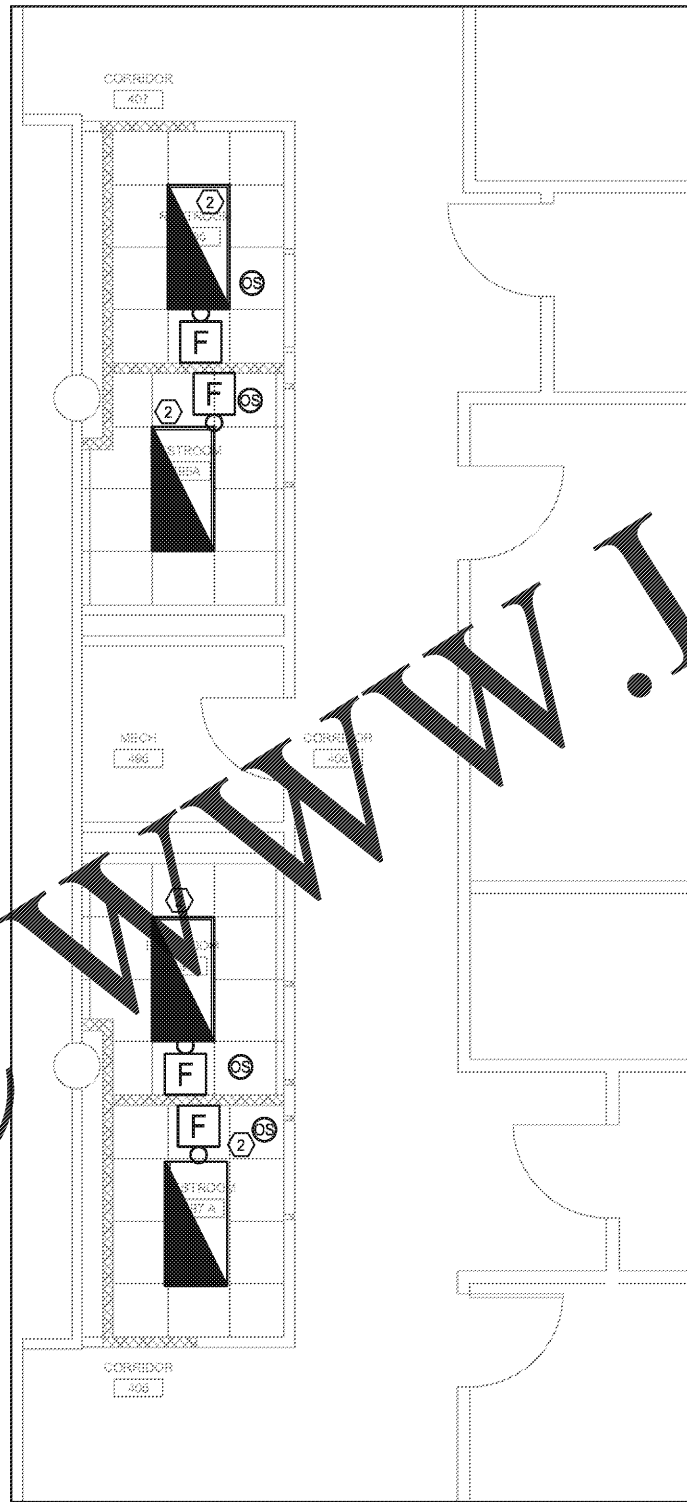


2 ELECTRICAL NEW PLAN - 4TH FL
SCALE: 1/4"=1'-0"

KEY NOTES:

- ① REMOVE LIGHT FIXTURES AND CONTROLS SERVING SPACE. EXISTING LIGHTING CIRCUIT TO REMAIN AND BE RE-USED WITH NEW LIGHT FIXTURE. REFER TO 2/E1.4 FOR NEW LIGHTING LAYOUT.
- ② NEW EMERGENCY LIGHT FIXTURE, MANUFACTURED BY COOPER, CAT# 24EN-LD2-45-UNV-LB40-CD1-U. CONTRACTOR TO UTILIZE EXISTING LIGHTING CIRCUIT SERVING SPACE. PROVIDE BATTERY BACKUP.

GENERAL NOTES:

- 1. ELECTRICAL DEVICES SHOWN IN LIGHT PENWEIGHT ARE EXISTING TO REMAIN. ELECTRICAL DEVICES SHOWN IN HEAVY PENWEIGHT ARE NEW UNLESS OTHERWISE NOTED.
- 2. EMERGENCY/EXIT/EGRESS LIGHTING FIXTURES ARE SPECIFIED WITH BATTERY BACKUP. CONNECT TRICKLE CHARGE INPUTS TO UNSWITCHED CIRCUIT CONDUCTORS OF LIGHTING CIRCUITS SERVING THE NORMAL LIGHTING IN THE SAME ROOM.
- 3. OCCUPANCY SENSORS SHALL PROVIDE 100% COVERAGE PER MANUFACTURERS RECOMMENDATIONS.
- 4. CONNECT NEW FIRE ALARM DEVICES TO EXISTING BUILDING FIRE ALARM SYSTEM. NEW FIRE ALARM DEVICES SHALL BE MANUFACTURED BY SIMPLEX. FIELD VERIFY EXISTING SYSTEM LOCATION AND THAT IT IS ADEQUATE FOR NEW FIRE ALARM DEVICES.

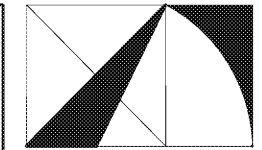


THE ARCHITECTURE GROUP, INC.

377 Peachtree St.
Atlanta, GA 30303
Phone: (678) 222-0375
Fax: (678) 222-0384
tag@architecturegroup.com

COPYRIGHT © 2018 BY THE ARCHITECTURE GROUP, INC. ALL RIGHTS RESERVED.

THIS DRAWING MAY NOT BE USED IN ANY MANNER NOR REPRODUCED IN ANY FORM WITHOUT PRIOR WRITTEN CONSENT FROM THE ARCHITECTURE GROUP, INC.

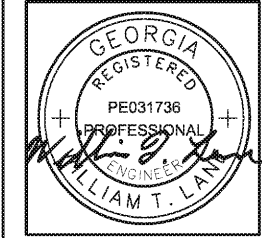

2018 MRRF CAMPUS-WIDE
ADA IMPROVEMENTS
PROJECT No. IGSU-026-18
TAG PROJECT No. 1706
GEORGIA STATE UNIVERSITY
ATLANTA, GEORGIA

100% CD#	2/5/2017
REVISIONS	
DATE	2/5/2017
DRAWN BY	
CHECKED	
APPROVED	
SCALE	AS NOTED
PROJECT NUMBER	1706
DRAWING TITLE	

ELECTRICAL LIGHTING PLAN - URBAN LIFE

DRAWING NUMBER

UL E1.1



SPENCER BRISTOL ENGINEERING, INC.
A Gray Company
3577 Parkway Lane, Suite 250
Peachtree Corners, Georgia 30092
Tel. 770.414.1628 Fax 770.414.6024
SBE Project No. 1744

Order Plans @ WWW.LDILine.com