


① REFLECTED CEILING PLAN (SCALE: 1/4" = 1'-0")

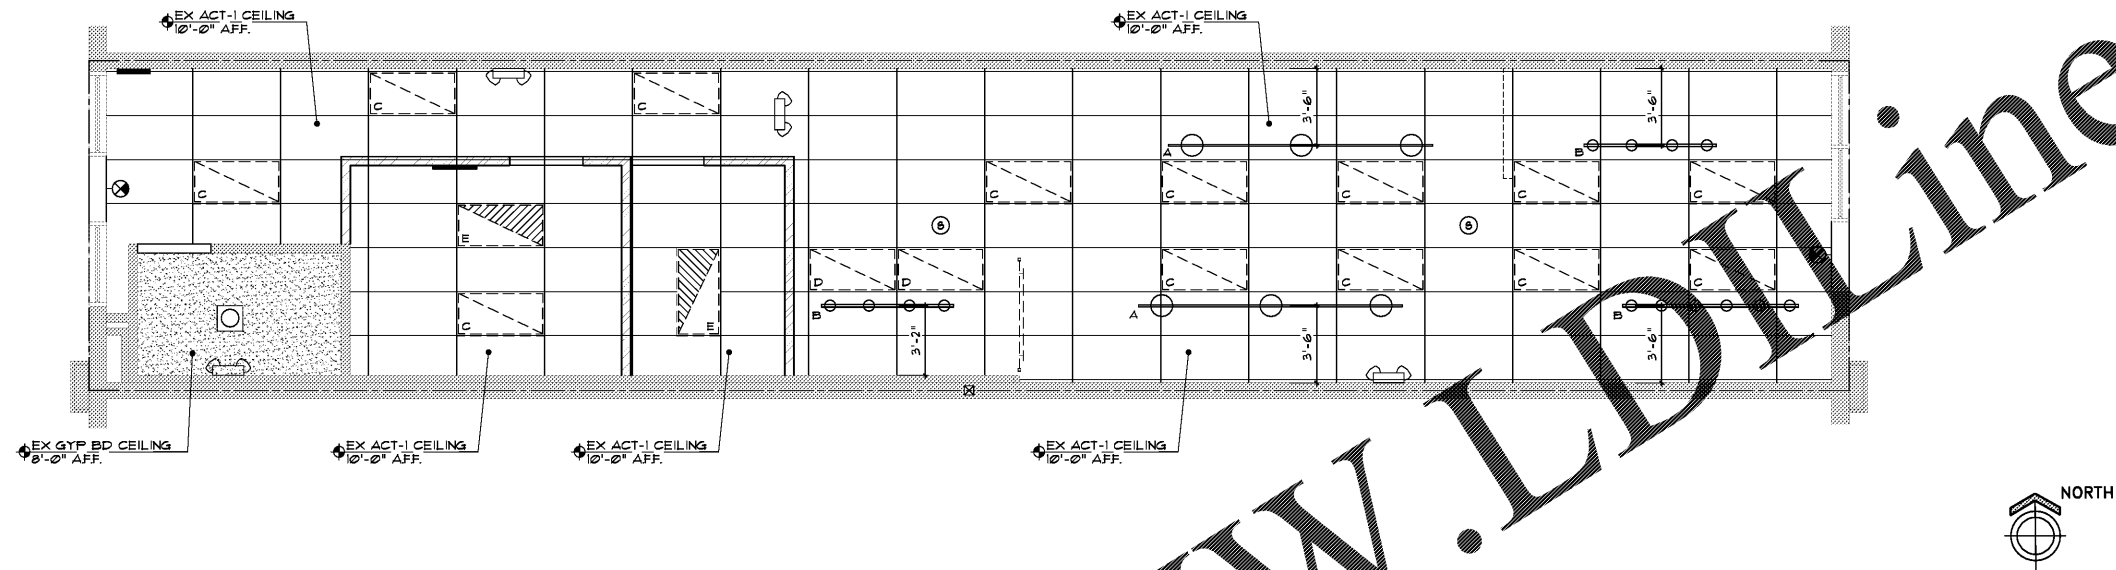

REFLECTED CEILING PLAN LEGEND

SYMBOL	FIXTURE TYPE	MOUNTING
	STATION PENDANTS ON TRACK FIXTURE	SURFACE MOUNT
	TRACK LIGHT FIXTURE	SURFACE MOUNT
	EXISTING (NON-DIMMABLE) 2x4 LED LIGHT FIXTURE SEE SHEET E-100 FOR LIGHT FIXTURE SCHEDULE	RECESSED
	EXISTING (DIMMABLE) 2x4 LED LIGHT FIXTURE SEE SHEET E-100 FOR LIGHT FIXTURE SCHEDULE	RECESSED
	EXISTING 2' X 4' LED EMERGENCY LIGHT FIXTURE - SEE SHEET E-100 FOR LIGHT FIXTURE SCHEDULE	RECESSED
	SPEAKERS (2)	RECESSED
	EXISTING EXIT SIGN	SURFACE MOUNT
	EXISTING COMBINATION EXHAUST FAN/LIGHT	RECESSED
	EXISTING EMERGENCY LIGHT	SURFACE MOUNT

GENERAL NOTES

- SEE SHEET A-500 FOR ROOM FINISH SCHEDULE AND MATERIAL NOTES.
- ALL GYPSUM BOARD CEILINGS AND SOFFITS TO HAVE A SMOOTH FINISH AND TO BE PAINTED PT-1.
- SEE ELECTRICAL SHEET E-100 FOR ALL EMERGENCY LIGHTING LOCATIONS.
- CONTRACTOR TO RELOCATE LIGHT FIXTURES PER PLANS. VERIFY ALL 2'x4' EMERGENCY LIGHTS ARE IN PROPER WORKING CONDITION.
- CONTRACTOR IS RESPONSIBLE TO REPLACE ANY DAMAGED CEILING TILE.
- GENERAL CONTRACTOR TO REFER TO ELECTRICAL PLANS FOR ADDITIONAL EQUIPMENT AND INFORMATION.
- CENTER TRACK LIGHTS OVER STYLING CHAIRS AND RETAIL UNITS AS SHOWN ON PLAN. DO NOT LINE UP WITH END OF STATIONS OR RETAIL UNITS OR SCALE LOCATIONS OFF OF PLAN.
- 3'-6" +/- FROM CENTERLINE OF TRACK TO FACE OF WALL (TYPICAL) U.N.C.
- PENDANT LIGHT FIXTURES ARRIVE WITH 10' CORDS, ETC. TO CUT CORD IN FIELD AS REQUIRED AND REREW TO NEW CONNECTOR. BOTTOM OF STATION HUNG PENDANT TO BE AT 7'-0" A.F.F. (SEE DETAIL ON PAGE 2/A-301)

CEILING MATERIAL LEGEND

	EXISTING A.C.I. CEILING SEE SHEET A-500 FOR FINISH MATERIAL LEGEND
	EXISTING CEILING GRID - TYPICAL SEE SHEET A-500 FOR FINISH MATERIAL LEGEND
	EXISTING GYP BOARD CEILING. PAINT PT-1, SEE SHEET A-500 FOR FINISH MATERIAL LEGEND

ALEXANDR IATIS INCARB
10755 SANDHILL ROAD
DALLAS, TEXAS 75238
214.343.1000

12/13/2017

#81973

SUPERCUTS
TENANT BUILD-OUT
LAKESIDE VILLAGE
7790 WINTER GARDEN VINELAND RD, SUITE 300
WINDERMERE, FL 34786

REFLECTED CEILING PLAN
& DETAILS

SUPERCUTS

DATE ISSUED
TENANT REVIEW 12.08.17
LANDLORD REVIEW 12.13.17
PERMIT 12.13.17

DRAWN BY BB
CHECKED BY AM
JOB NO. 17-678

A-200