


PLUMBING LEGEND			
SYMBOLS & ABBREVS	LEGEND	SYMBOLS & ABBREVS	LEGEND
SAN	SOIL OR WASTE PIPING ABOVE FLOOR	C.V.	CHECK VALVE
FA	FRESH AIR PIPING	PRV	PRESSURE REDUCING VALVE
GW	GREASE WASTE LINE	UNION	UNION
SOL	SOIL OR WASTE PIPING BELOW FLOOR	SA	SHOCK ABSORBER
VP	VENT PIPING	N.F.W.H.	NON-FREEZE WALL HYDRANT
ST	STORM SEWER PIPING	CO	FLOOR CLEANOUT
RL	RAIN LEADER	F.S.	FLOOR SINK PSD-18B
G	GAS PIPING	F.D.	FLOOR DRAIN
F	FIRE LINE OR STANDPIPE	B.F.	BELOW FLOOR
SP	SPRINKLER LINE	YVR	VENT THRU ROOF
A	AIR PIPING	AFI	ABOVE FINISHED FLOOR
FW	FILTERED WATER	INV	INVERT
TW	TEMPERED WATER	BFP	BACK FLOW PREVENTER
C.W.	COLD WATER SUPPLY		FLOOR DRAIN - SEE PSD-1
H.W.	HOT WATER SUPPLY		FLOOR DRAIN NO. 3S - SEE PSD-16
H.W.R.	HOT WATER RECIRCULATING LINE		FLOOR DRAIN NO. 1S - SEE PSD-3
	PIPE RISING - PIPE TURNING DOWN		FLOOR DRAIN NO. 2 - SEE PSD-3
B.V.	BALL VALVE		TRENCH DRAIN - SEE PSD-34
G.V.	GATE VALVE	OC	HUB DRAIN - SEE PSD-1

SANITARY NOTES:

1. EXACT SIZE AND LOCATION OF EXISTING SANITARY, WATER LINES AND EXISTING EQUIPMENT TO BE DETERMINED BY THE CONTRACTOR ON THE JOB. FIELD VERIFY ALL CONNECTING INVERTS PRIOR TO BEGINNING CONSTRUCTION.
2. CONTRACTOR SHALL DETERMINE DIRECTION OF FLOW IN EXISTING LINES AND THE NEW PIPES IN THE PROPER DIRECTION.
3. DISPOSE OF ALL MATERIALS REMOVED AND NOT REUSED, AS DIRECTED BY KROGER ENGINEER.
4. ALL EXISTING DRAINS TO BE ABANDONED SHALL BE PLUGGED OR CAPPED, FILLED WITH CONCRETE BELOW FLOOR. FLOOR OVER IN ALL AREAS AS FIELD CONDITIONS INDICATE.
5. ALL PIPING FROM FIXTURES TO BE REMOVED SHALL BE PROPERLY PLUGGED OR CAPPED SO THAT UPON COMPLETION OF ALL NEW WORK, ALL ABANDONED PIPING SHALL BE CONCEALED IN FINISHED AREAS.
6. NO DEAD ENDS SHALL BE LEFT ON ANY DRAINAGE PIPING UPON COMPLETION OF THE JOB.
7. CONCEALED ABANDONED PIPING NEED NOT BE REMOVED IF IT DOES NOT INTERFERE WITH THE NEW WORK.
8. THE EXISTING SYSTEM(S) TO BE REUSED SHALL BE LEFT IN PERFECT WORKING ORDER UPON COMPLETION OF THE JOB. VERIFY INVERT OF EXISTING SANITARY PIPING PRIOR TO STARTING WORK. IF INVERT IS NOT LOW ENOUGH TO CONNECT NEW WORK, CONTACT ARCHITECT.
9. PLUMBING CONTRACTOR SHALL PERMANENTLY CAP ALL EXISTING CASE DRAINS OR HUB DRAINS NO LONGER IN USE. FOR DEMOLITION AND RELOCATED FIXTURES, PLUMBING CONTRACTOR SHALL PROVIDE TEMPORARY CONNECTIONS FOR THE FIXTURE DURING PHASING OF REMODEL.
10. CONTRACTOR SHALL COORDINATE WITH KROGER ENGINEER THE DEMOLITION OF ALL PIPING AND DRAINS PER THE PHASING PLANS.
11. PROVIDE NEW DRAIN SHOWN AS REQUIRED, ROUTE NEW RETROFITTED CASE CONDENSATE LINE FOR PSD-1/P1.1. RE-USE EXISTING DRAIN IF APPROVED BY KROGER FACILITY ENGINEER.
12. ROUTE NEW VENT AND MAKE CONNECTION TO EXISTING VENT THRU ROOF, SEE NOTE #1.
13. PROVIDE A MANFOLDED DRAIN LINE FROM WARMER WITH SHUT OFF VALVE 1/2" WPI CONNECTION.
14. CONTRACTOR SHALL DISCONNECT ALL PLUMBING FIXTURES FOR INSTALLATION ON NEW FLOOR AND WALL TILES AND REINSTALL (PROVIDING ALL NEW SUPPLIES, SINK WAGES, ETC. REQUIRED) AND REINSTALL AFTER COMPLETION OF NEW TILE WORK. COORDINATE PHASING WITH KROGER FACILITY ENGINEER.

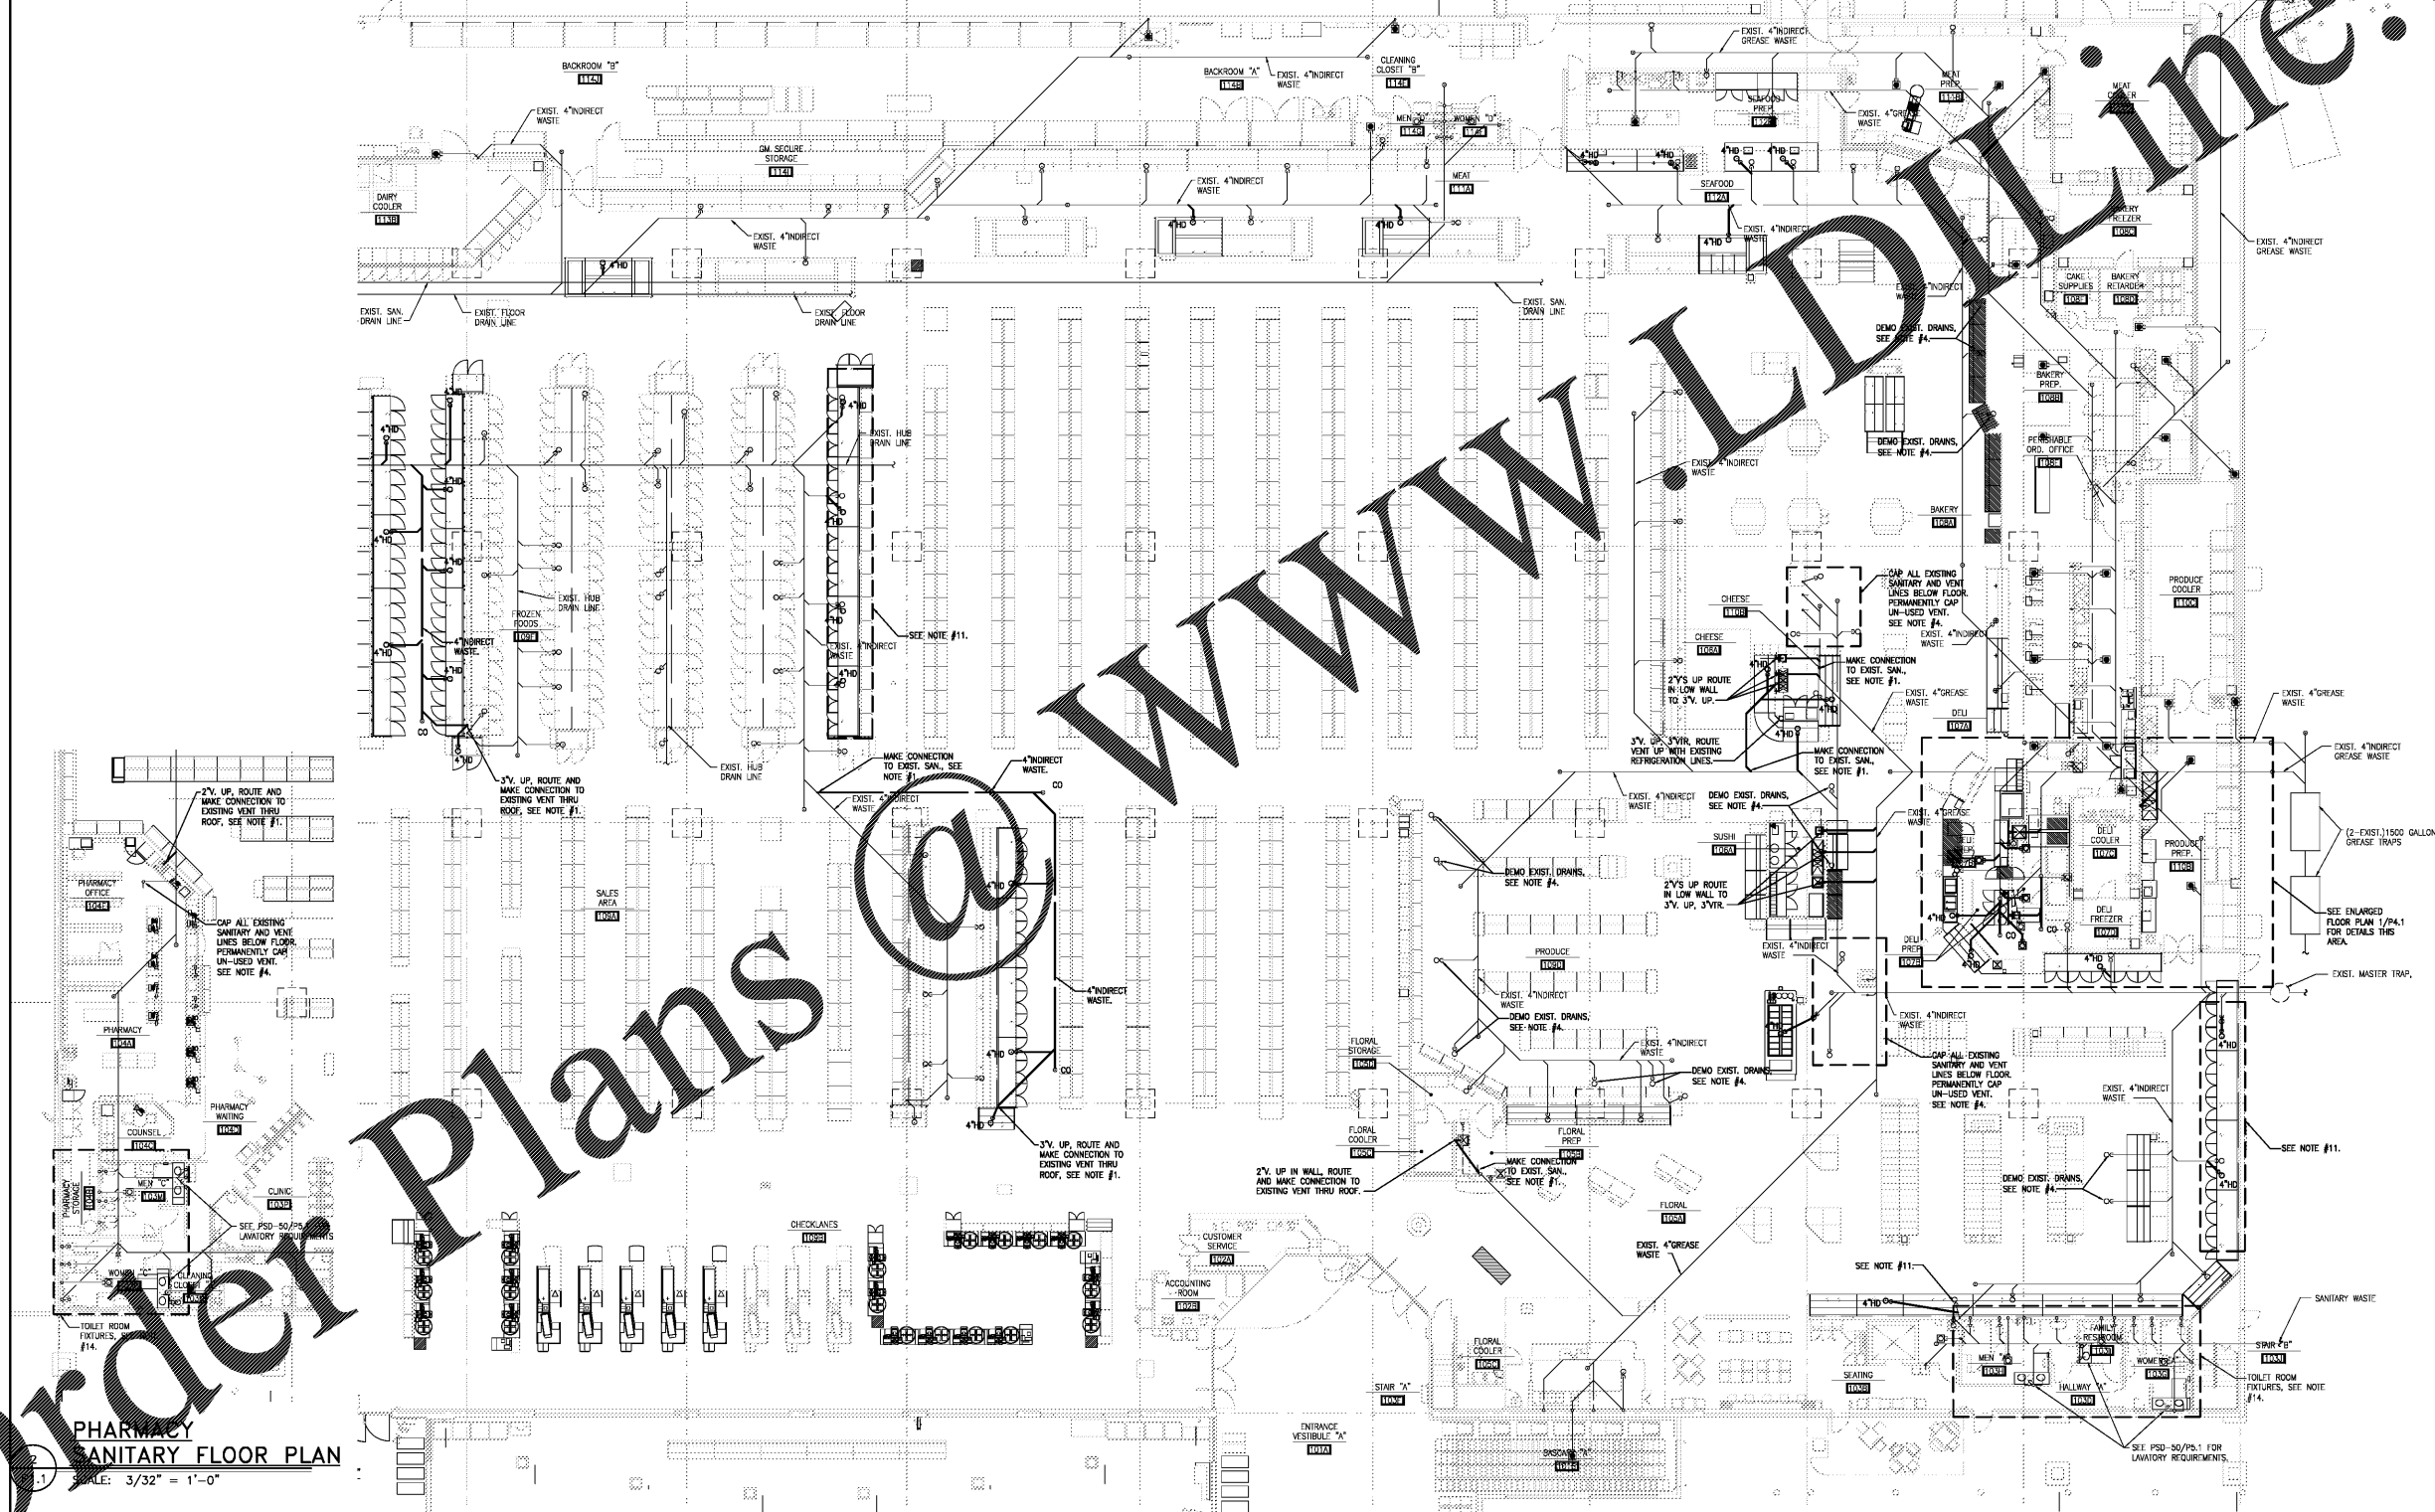

PHARMACY SANITARY FLOOR PLAN
SCALE: 3/32" = 1'-0"

NOTE:
THIS PROJECT IS A RENOVATION OF AN EXISTING FACILITY AND OF NECESSITY, PREVIOUS RECORD DRAWINGS FORM THE BASIS FOR MANY OF THESE DRAWINGS. IT IS THEREFORE EVEN MORE IMPORTANT THAN IN NEW CONSTRUCTION THAT ALL DIMENSIONS SHALL BE FIELD VERIFIED BEFORE FABRICATION OR PURCHASE OF DIMENSION CRITICAL EQUIPMENT, MATERIALS AND ASSEMBLIES. THESE ANY EXIST FIELD CONDITIONS NOT ACCESSIBLE DURING DESIGN WHICH DIFFER FROM THOSE SHOWN ON THE DRAWINGS. ANY SUCH DEVIATIONS SHALL BE BROUGHT TO THE ATTENTION OF THE ARCHITECT AND KROGER ENGINEER FOR RESOLUTION BEFORE PROCEEDING WITH ANY CONSTRUCTION, FABRICATION, OR MATERIAL/EQUIPMENT PURCHASES WHICH WOULD BE UNUSABLE UNDER THESE CIRCUMSTANCES

1 SANITARY FLOOR PLAN - PLUMBING
SCALE: 3/32" = 1'-0"

ROBERTSON LOIA ROOF ARCHITECTS & ENGINEERS
3460 Phoenix Ridge Road, Suite 2000, Louisville, KY 40220
502-261-5000
502-261-5005

THIS REPRODUCTION IS NOT A CERTIFIED DOCUMENT



Kroger L-407 - Remodel
2101 RICHMOND ROAD
LEXINGTON, KY

The Kroger Company
1600 Ormsby Station Court, Louisville, KY 40223

REVISIONS

NO.	DATE	DESCRIPTION

SANITARY FLOOR PLAN

DATE: 01-25-18

PROJECT NUMBER: 17-125

SHEET NUMBER: **P1.1**

Order Plans @ www.plumbline.com