
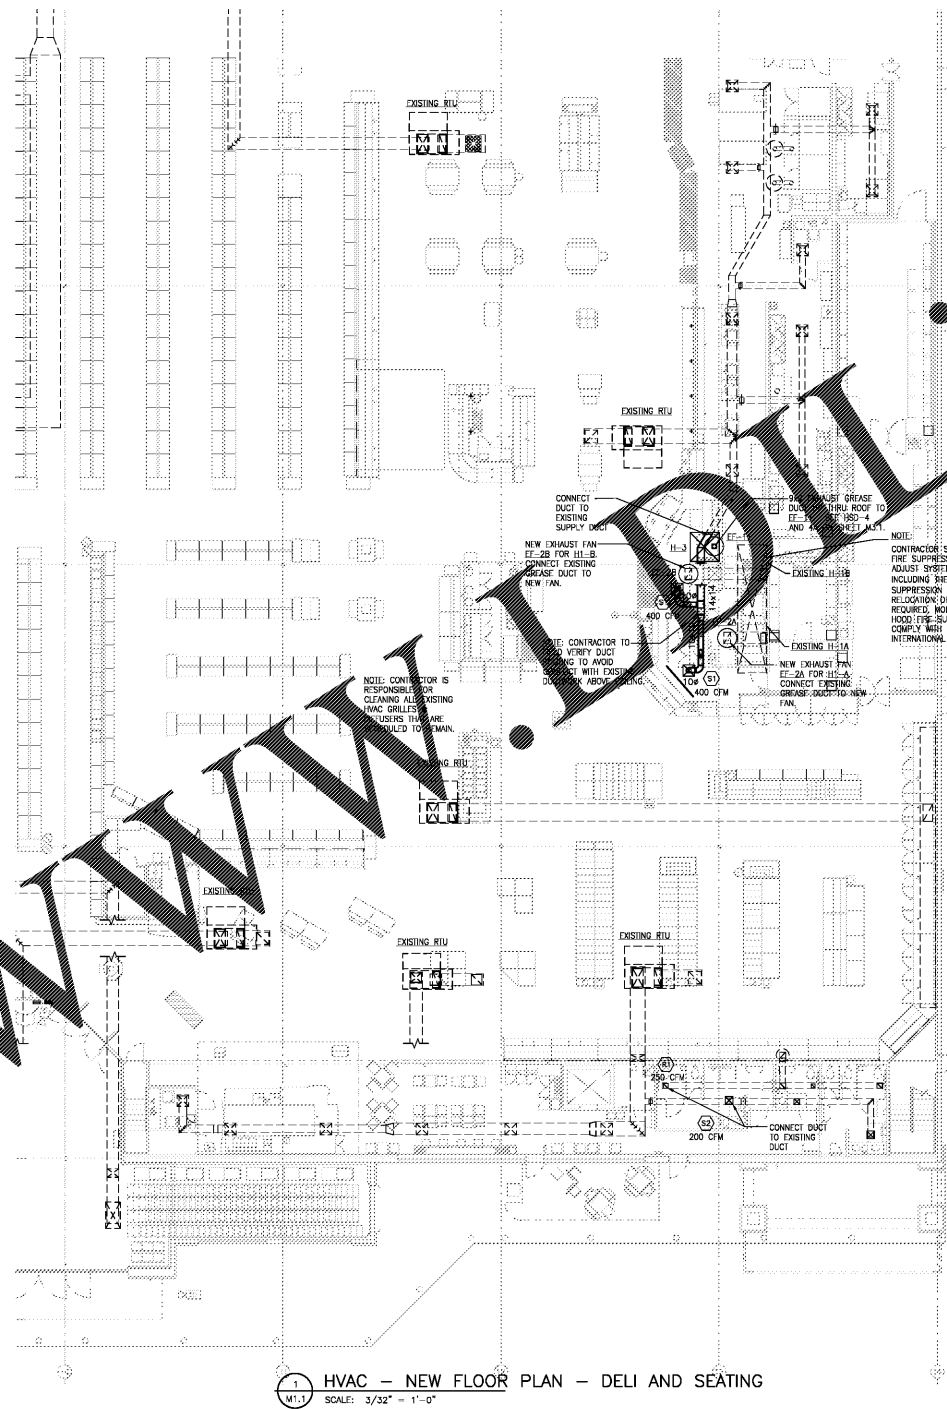


Order Plans @

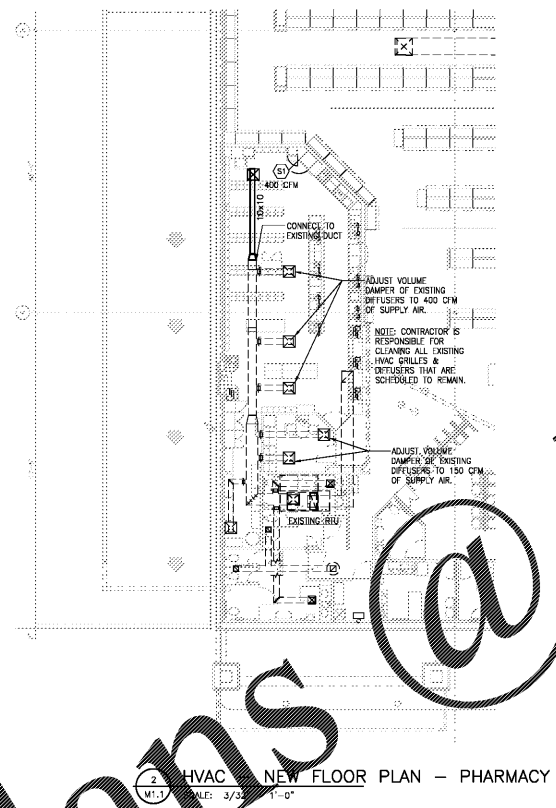

HVAC LEGEND & ABBREVIATIONS	
☒	SUPPLY DIFFUSER
☒	RETURN GRILLE
○	AIR DISTRIBUTION TAG
⊕	TEMPERATURE SENSOR
⊖	HUMIDITY SENSOR
⊞	MANUAL VOLUME DAMPER
⊞	SPLITTER DAMPER
⊞	FIRE DAMPER
⊞	DOUBLE THICK TURNING WARE
⊞	DOOR LOUVER
RTU	ROOFTOP UNIT
FCU	FAN COIL UNIT
EE	ELECTRIC FAN
GHU	GAS UNIT HEATER
H	HEATER
CU	CONDENSING UNIT

DUCTWORK LEGEND	
SYMBOLS & ABBREV	LEGEND
---	EXISTING DUCT WORK, REMOVE AND DISCARD.
- - -	EXISTING DUCT WORK TO REMAIN AND BE REUSED.
---	NEW, INSTALLED DUCTWORK

NOTE:
THIS PROJECT IS A RENOVATION OF AN EXISTING FACILITY AND OF NECESSITY, PREVIOUS RECORD DRAWINGS FORM THE BASIS FOR MANY OF THESE DRAWINGS. IT IS THEREFORE EVEN MORE IMPORTANT THAN IN NEW CONSTRUCTION THAT ALL DIMENSIONS SHALL BE FIELD VERIFIED BEFORE FABRICATION OR PURCHASE OF DIMENSION CRITICAL EQUIPMENT, MATERIALS, AND ASSEMBLIES. THERE MAY EXIST FIELD CONDITIONS NOT ACCESSIBLE DURING DESIGN WHICH DIFFER FROM THOSE SHOWN ON THE DRAWINGS. ANY SUCH DEVIATIONS SHALL BE BROUGHT TO THE ATTENTION OF THE ARCHITECT AND KROGER ENGINEER FOR RESOLUTION BEFORE PROCEEDING WITH ANY CONSTRUCTION, FABRICATION, OR MATERIAL/EQUIPMENT PURCHASES WHICH WOULD BE UNSAFE UNDER THESE CIRCUMSTANCES.

WWW.DLINE.COM

ROBERTSON LOIA ROOF ARCHITECTS & ENGINEERS
3480 Preston Highway, Suite 200, Alpharetta, Georgia 30005
770-674-7700 Fax: 770-674-7701

THIS REPRODUCTION IS NOT A CERTIFIED DOCUMENT



Kroger L-407 - Remodel
3101 RICHMOND ROAD
LEXINGTON, KY

The Kroger Company
1680 Ombaby Station Court, Louisville, KY 40223

REVISIONS

HVAC NEW FLOOR PLAN

DATE: 01-25-18
PROJECT NUMBER: 17-125

SHEET NUMBER: M1.1