
 


Order Plans

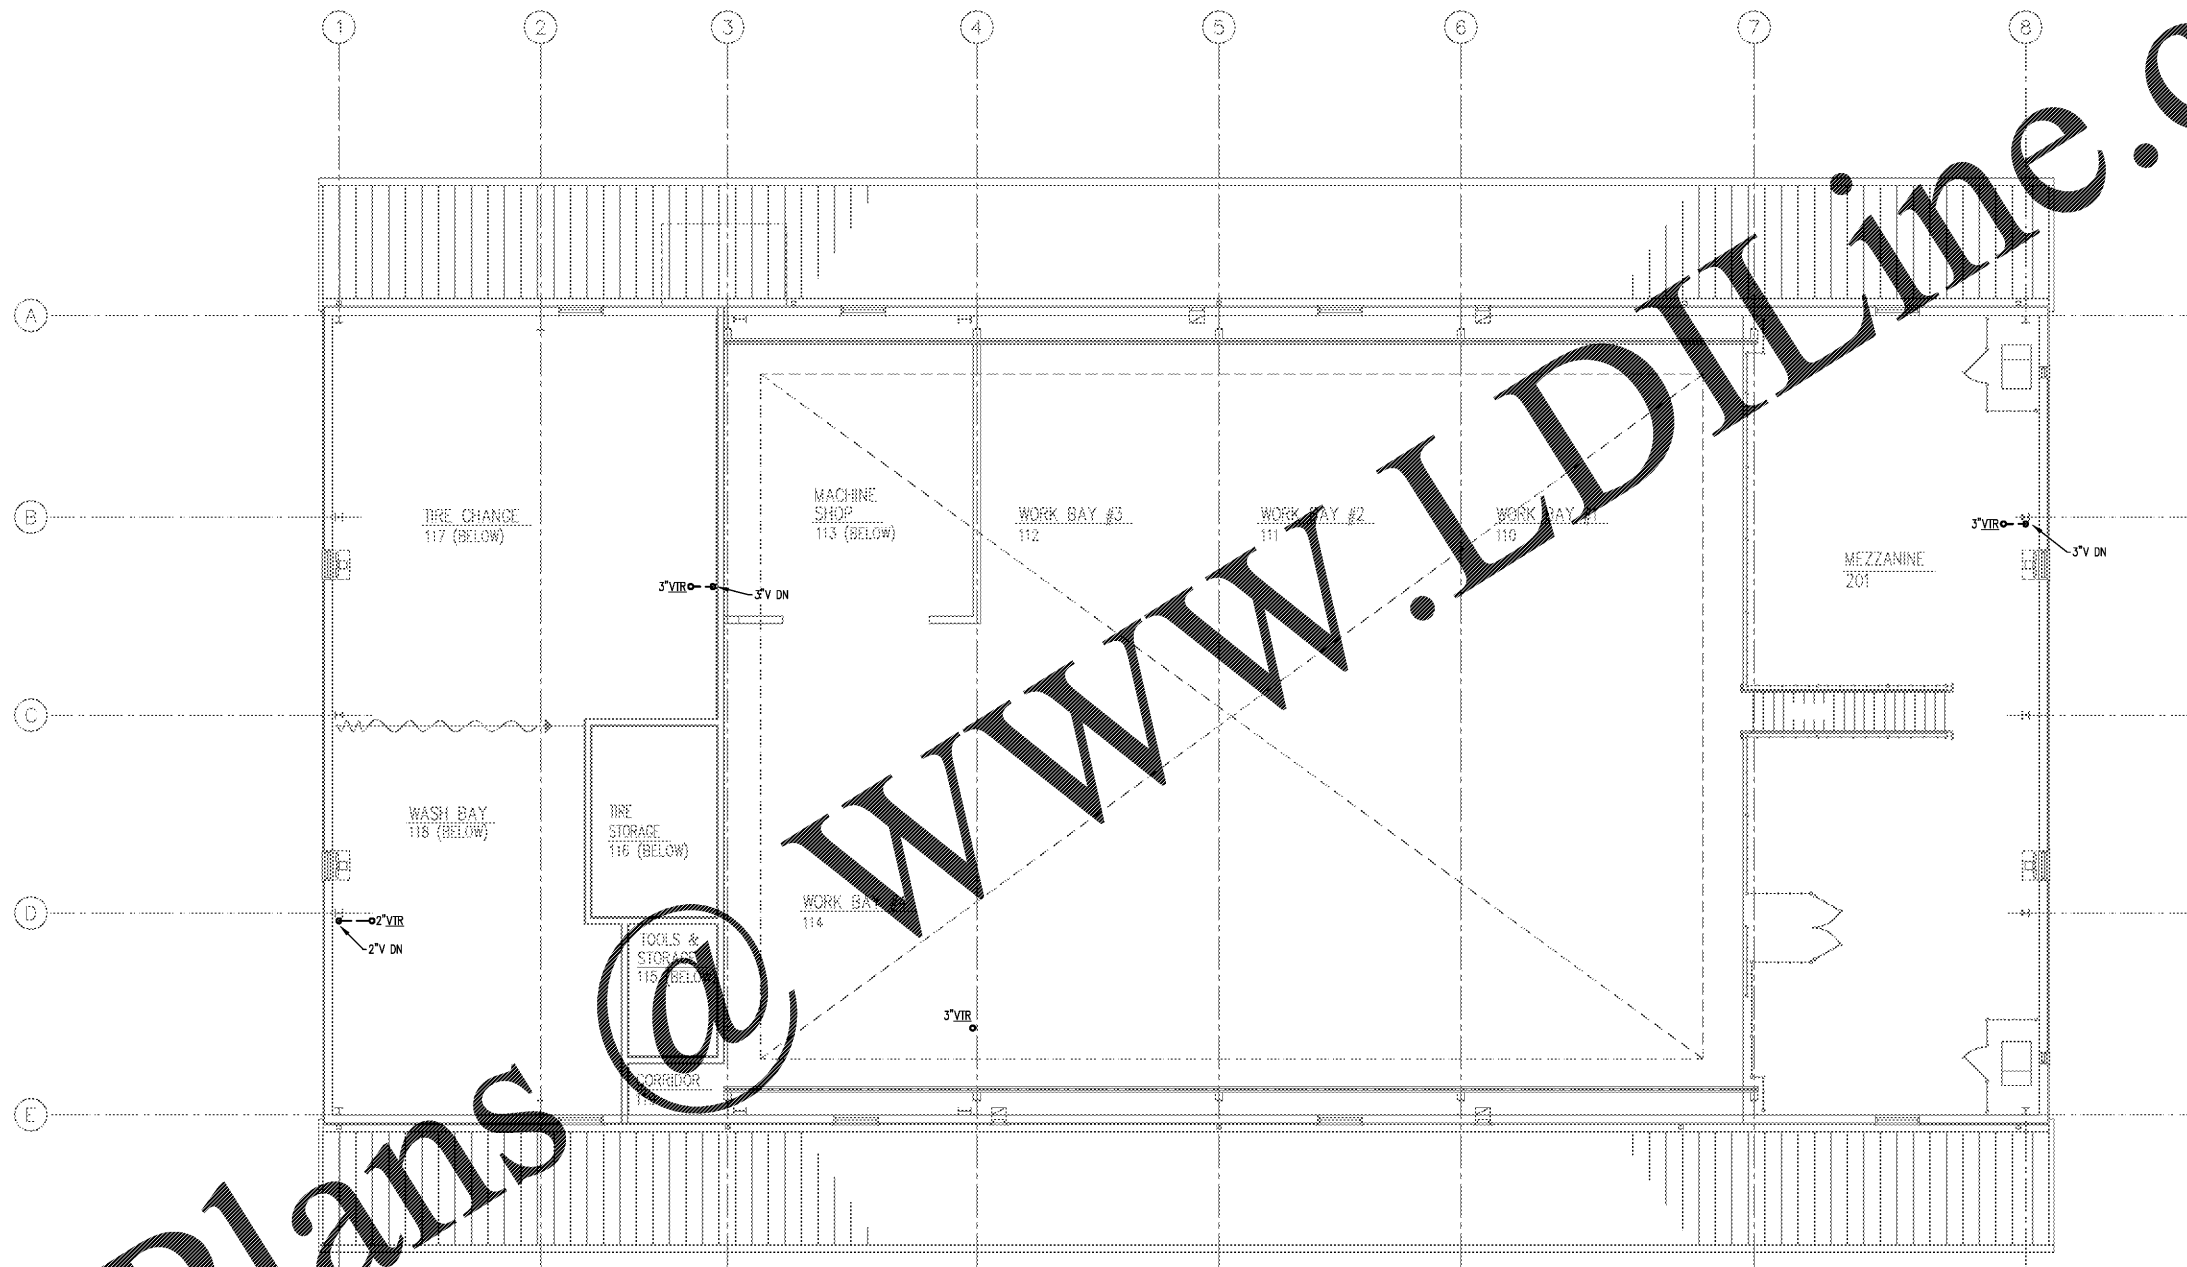

1 MEZZANINE LEVEL WASTE FLOOR PLAN - PLUMBING
 SCALE: 1/8" = 1'-0"



VTR - VENT THRU ROOF
 NOTE:
 REFER TO ARCHITECTURAL SHEET A4 DETAIL #3 FOR INSTALLATION OF
 VENT THRU ROOF. COORDINATE INSTALLATION WITH ROOFING
 CONTRACTOR AND GENERAL CONTRACTOR.

BIDDING DOCUMENTS

DESIGNED BY:
FACILITIES DESIGN
 ARCHITECTS & ENGINEERS
 FACILITIES MANAGEMENT DIVISION
 1. 800121 200-3000000 0700007
 2. 800121 200-3000000 0700007
 3. 800121 200-3000000 0700007
 4. 800121 200-3000000 0700007
 5. 800121 200-3000000 0700007
 6. 800121 200-3000000 0700007
 7. 800121 200-3000000 0700007
 8. 800121 200-3000000 0700007
 9. 800121 200-3000000 0700007
 10. 800121 200-3000000 0700007
 11. 800121 200-3000000 0700007
 12. 800121 200-3000000 0700007
 13. 800121 200-3000000 0700007
 14. 800121 200-3000000 0700007
 15. 800121 200-3000000 0700007
 16. 800121 200-3000000 0700007
 17. 800121 200-3000000 0700007
 18. 800121 200-3000000 0700007
 19. 800121 200-3000000 0700007
 20. 800121 200-3000000 0700007

CONSULTANT:
DEVTA
 DEVELOPMENT & CONSTRUCTION MANAGEMENT
 10000 W. HUNTER STREET, SUITE 100
 FAYETTEVILLE, NC 28404
 TEL: 704.782.4444
 FAX: 704.782.4444

DRAWING TITLE / DESCRIPTION:
**MEZZANINE LEVEL
 WASTE FLOOR PLAN -
 PLUMBING**

PROJECT TITLE:
**LUMBERTON EQUIPMENT SHOP
 NCDOT HIGHWAY DIVISION 6
 872 NC 711 HIGHWAY
 LUMBERTON, NORTH CAROLINA 28380**

STATE CONSTRUCTION
 ID.# 16-12916-01A
 ASSET NUMBER:
 CO.# SITE.# BLDG.#
 78 - 06 - 00
 REVISIONS
 NO. DATE

DATE ISSUED: 12/15/2017
 DRAWN BY: DRB
 CHECKED BY: WLA
 SHEET NO.

P1.1