

ELECTRICAL SITE PLAN

PROJECT TITLE: LUMBERTON EQUIPMENT SHOP  
 LUMBERTON EQUIPMENT DIVISION 6  
 NCDOT HIGHWAY DIVISION 6

872 NC 711 HIGHWAY  
 LUMBERTON, NORTH CAROLINA 28380


STATE CONSTRUCTION ID.# 16-12916-01A

ASSET NUMBER:  
 CO.# SITE.# BLDG.#  
 78-06-00

REVISIONS NO.	DATE

DATE ISSUED: 12/15/2017  
 DRAWN BY: MKT  
 CHECKED BY: MWH  
 SHEET NO.

E0.3

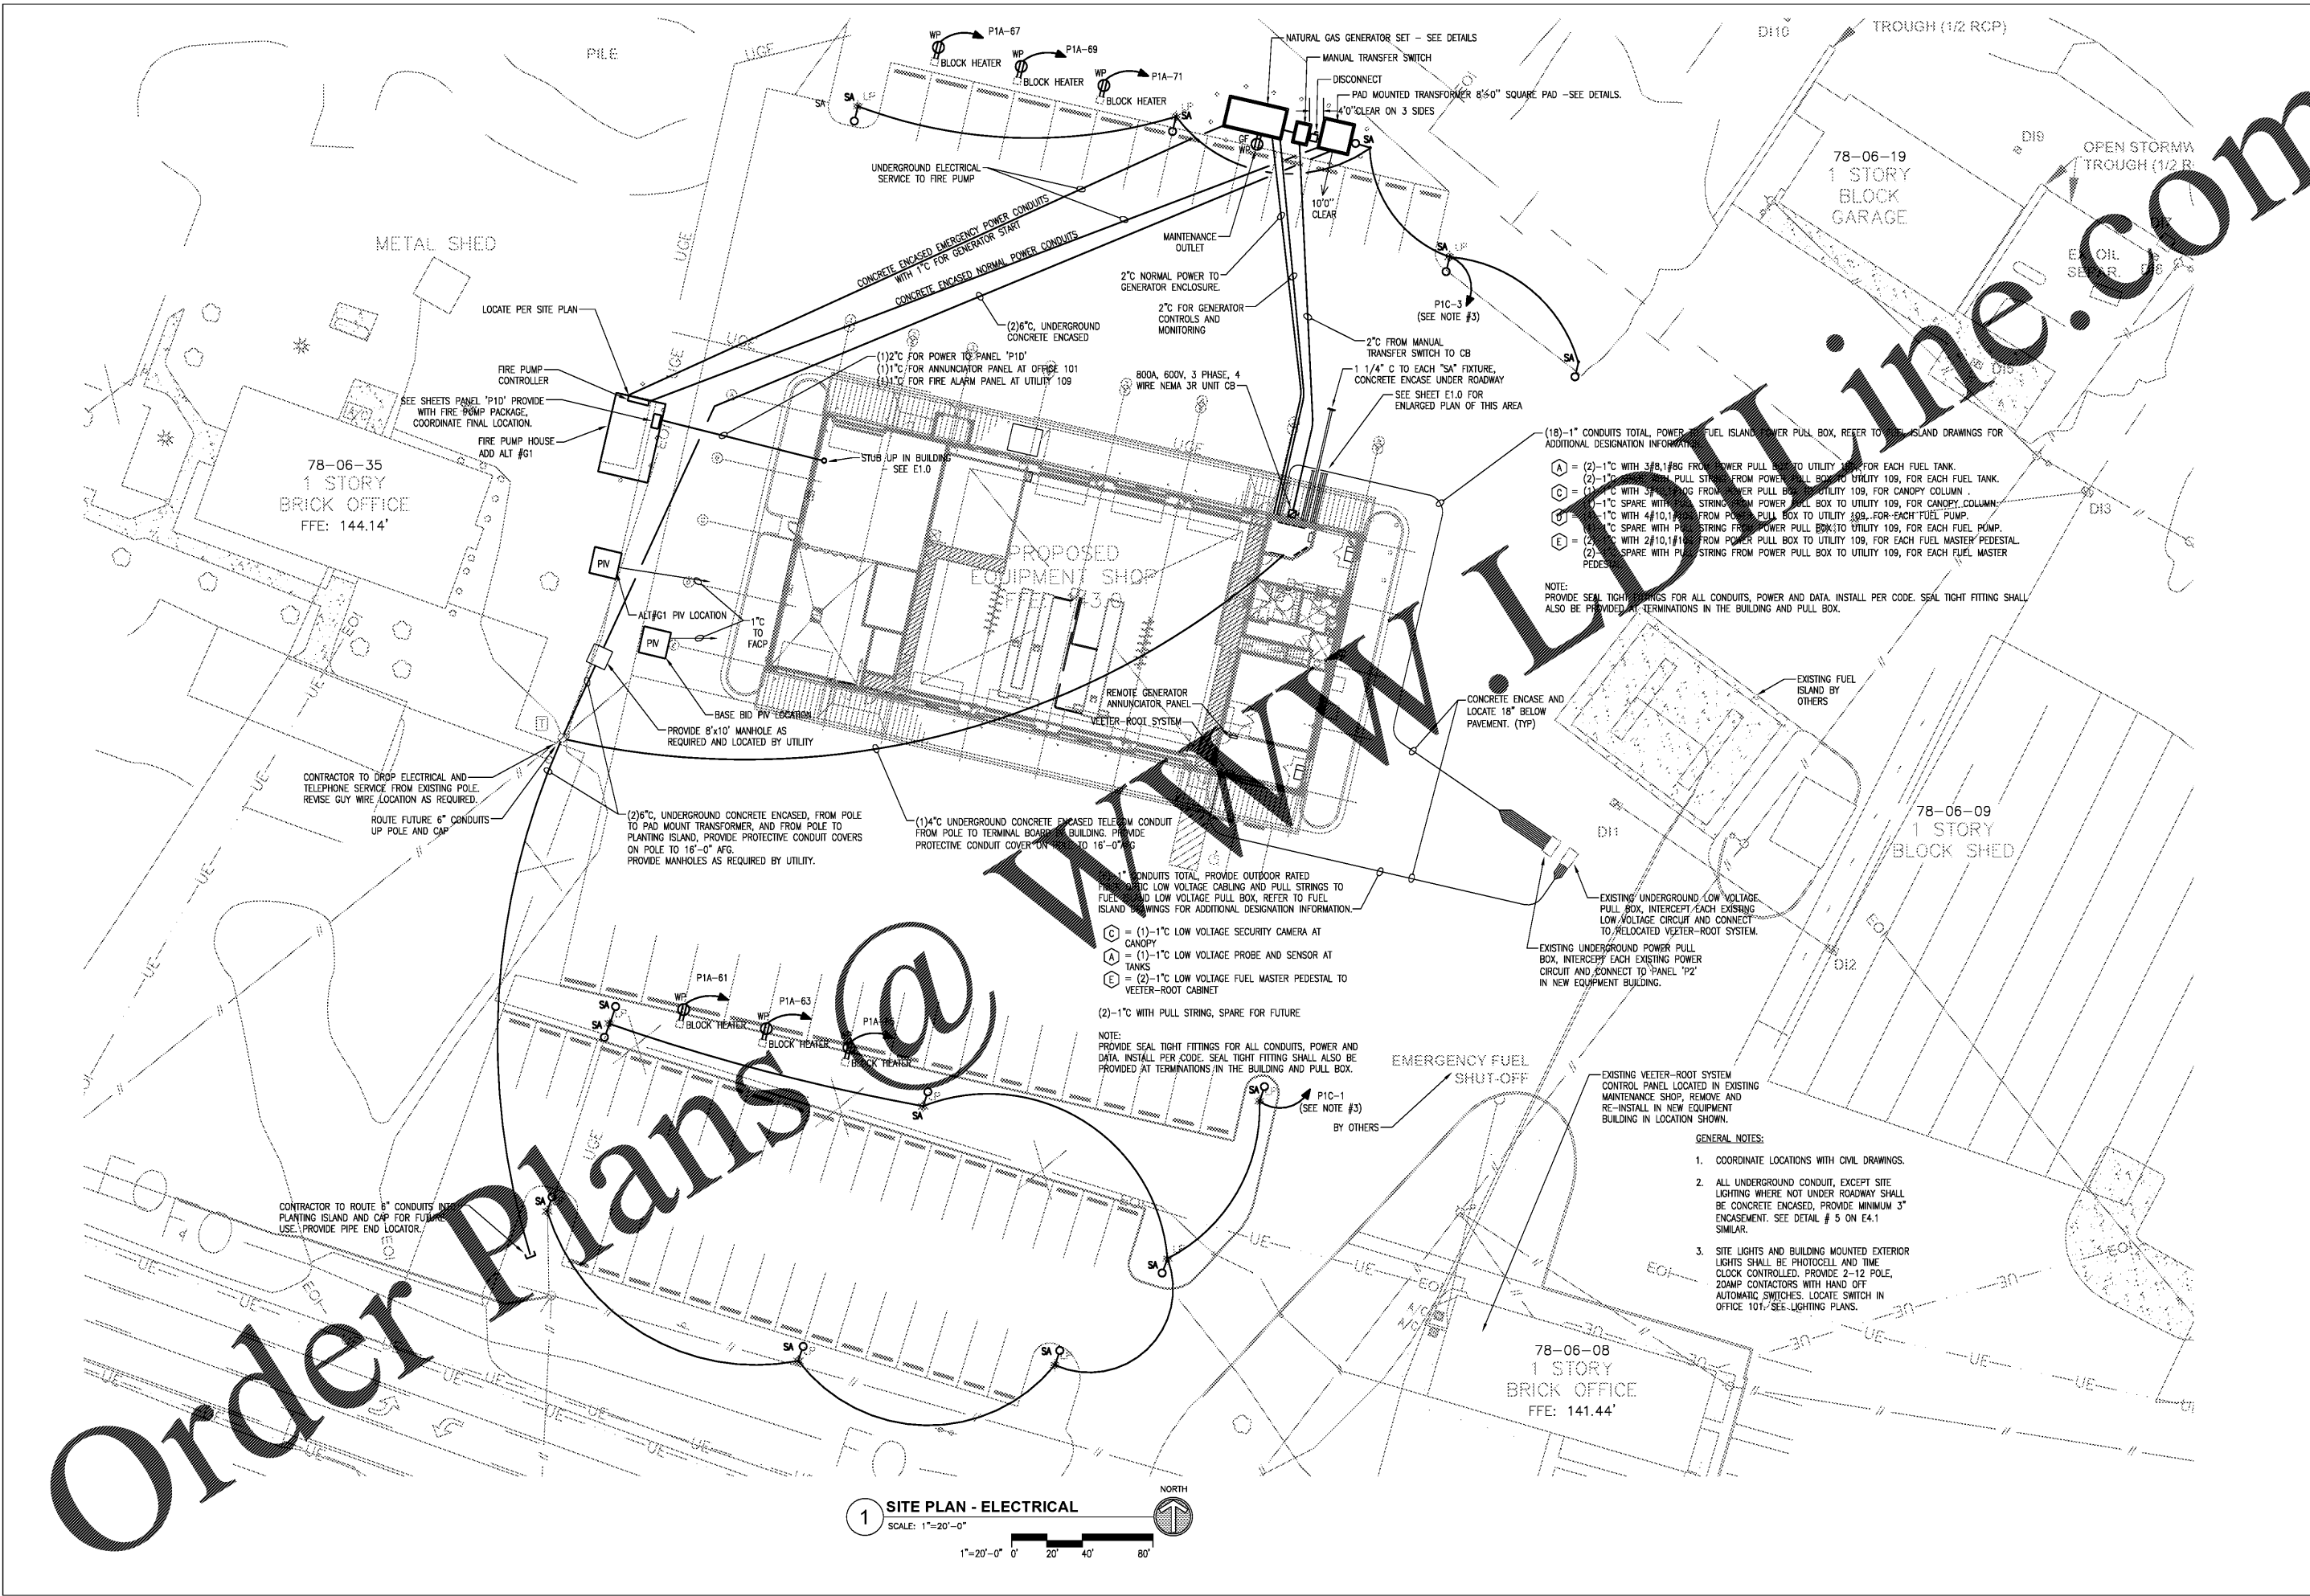

1 SITE PLAN - ELECTRICAL  
 SCALE: 1"=20'-0"

Order Plans @