
 


Order Plans @ www.LDOnline.com

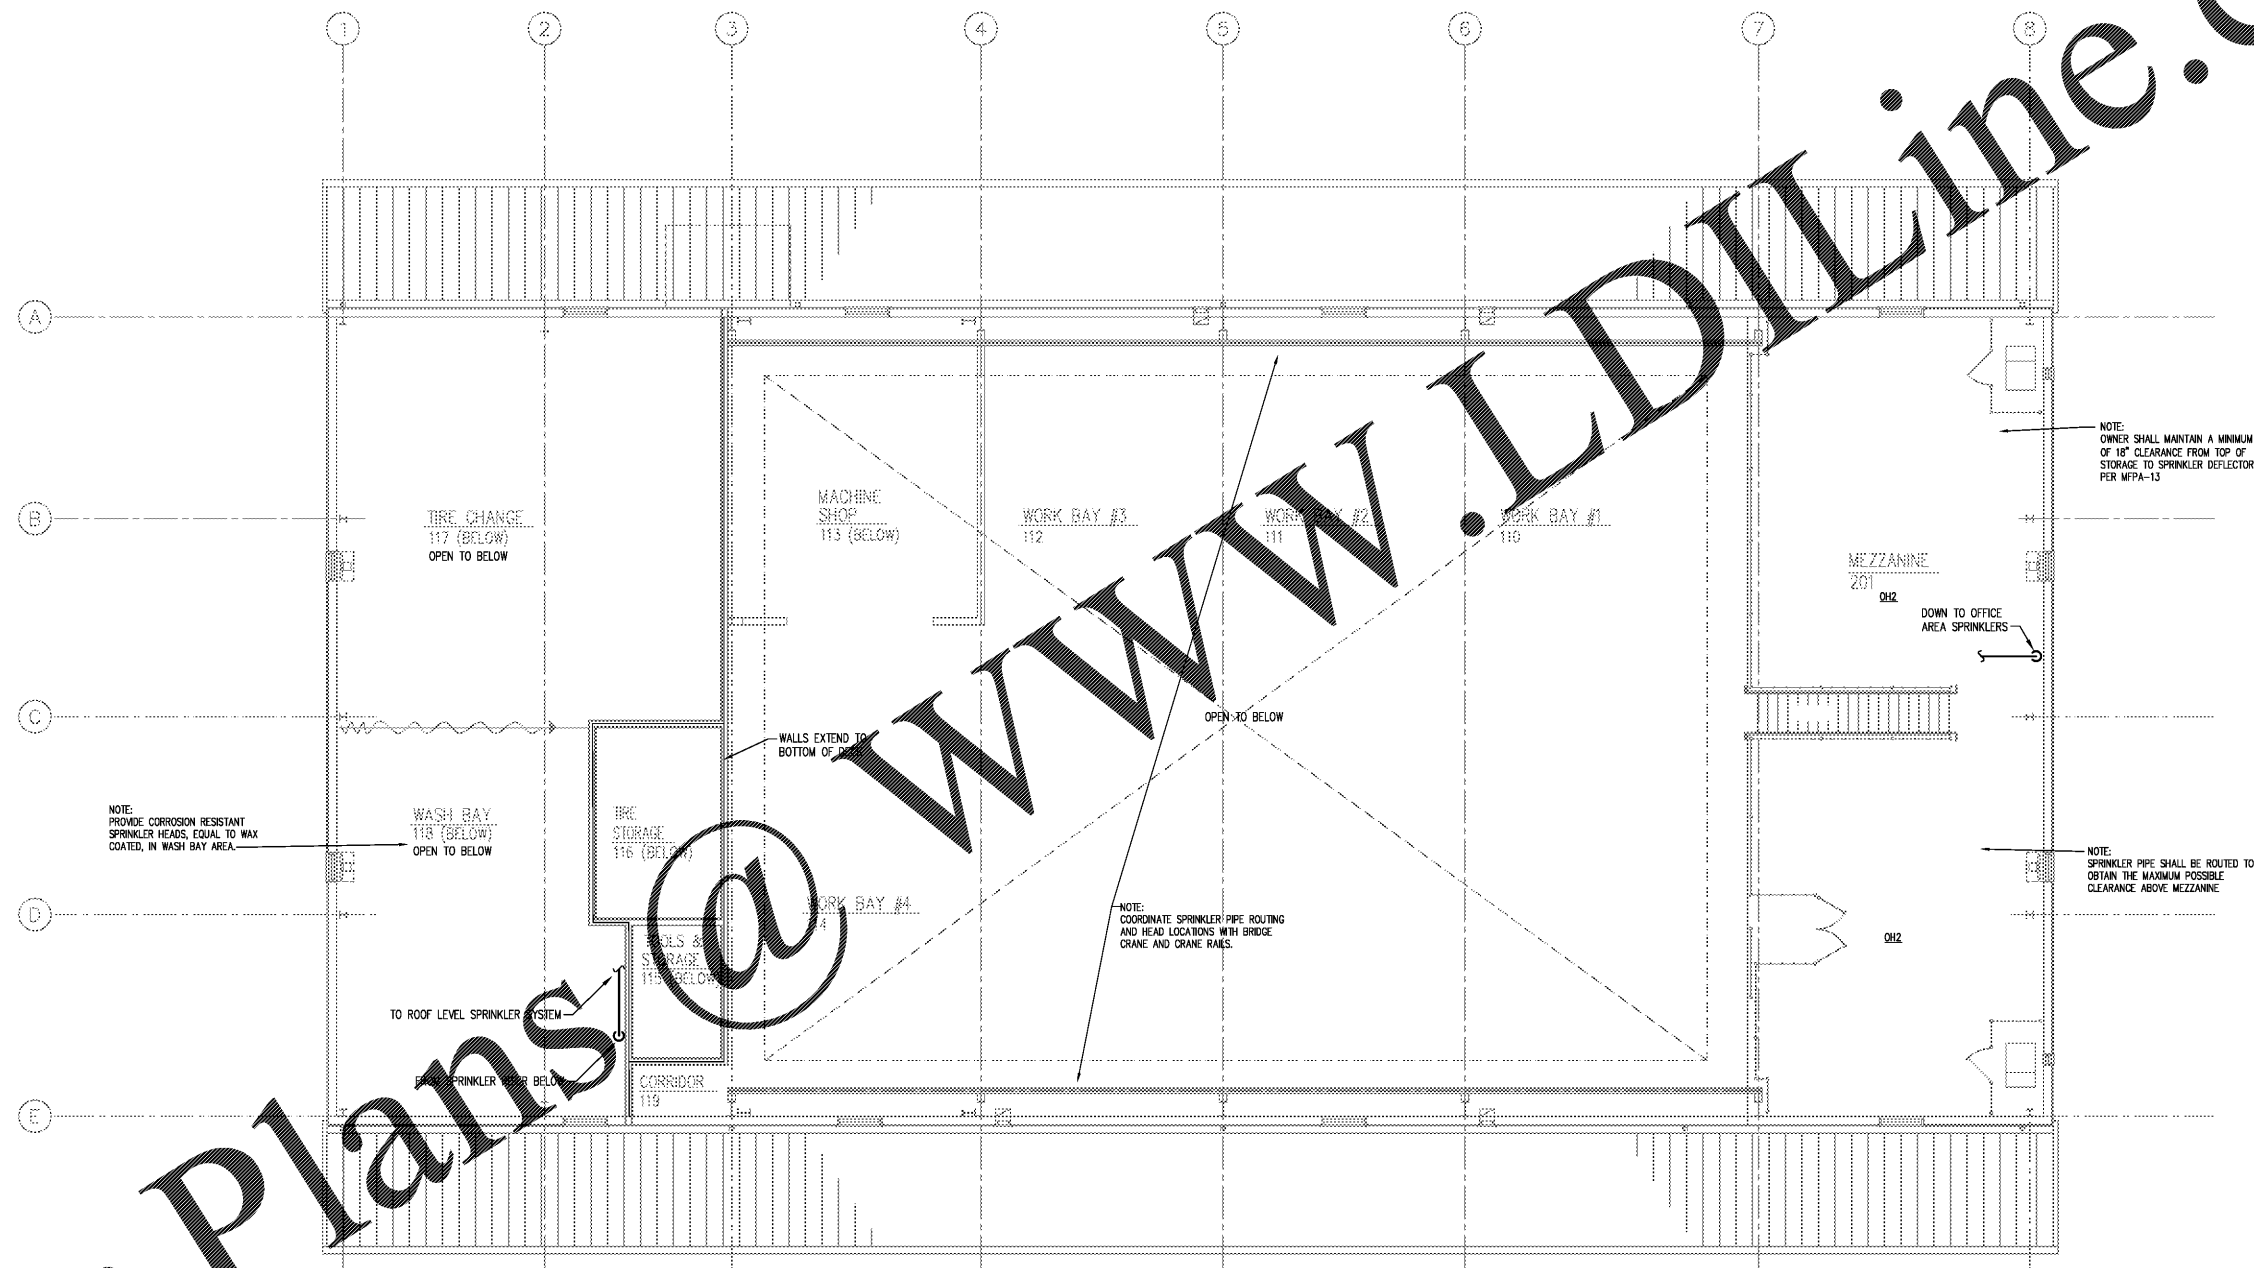

1 MEZZANINE LEVEL FLOOR PLAN - FIRE PROTECTION
 SCALE: 1/8" = 1'-0"



BIDDING DOCUMENTS

DESIGNED BY: **FACILITIES DESIGN ARCHITECTS & ENGINEERS**
 1. 800.572.386-3868 FAX: 888.778-0388
 2. 919.487.2000 FAX: 919.487.2000
 3. 919.487.2000 FAX: 919.487.2000

CONSULTANT: **DEVTA**
 DEVTA ARCHITECTS & ENGINEERS
 1000 W. GARDNER ST. SUITE 1000
 RALEIGH, NC 27603

DRAWING TITLE / DESCRIPTION: MEZZANINE LEVEL FLOOR PLAN - FIRE PROTECTION

PROJECT TITLE: LUMBERTON EQUIPMENT SHOP
 LUMBERTON HIGHWAY DIVISION 6
 872 NC 711 HIGHWAY
 LUMBERTON, NORTH CAROLINA 28380

STATE CONSTRUCTION ID.#: 16-12916-01A

ASSET NUMBER: 78-06-00

REVISIONS NO.	DATE

DATE ISSUED: 12/15/2017
DRAWN BY: DRB
CHECKED BY: WLA
SHEET NO.: FP1.1