


# Order Plans

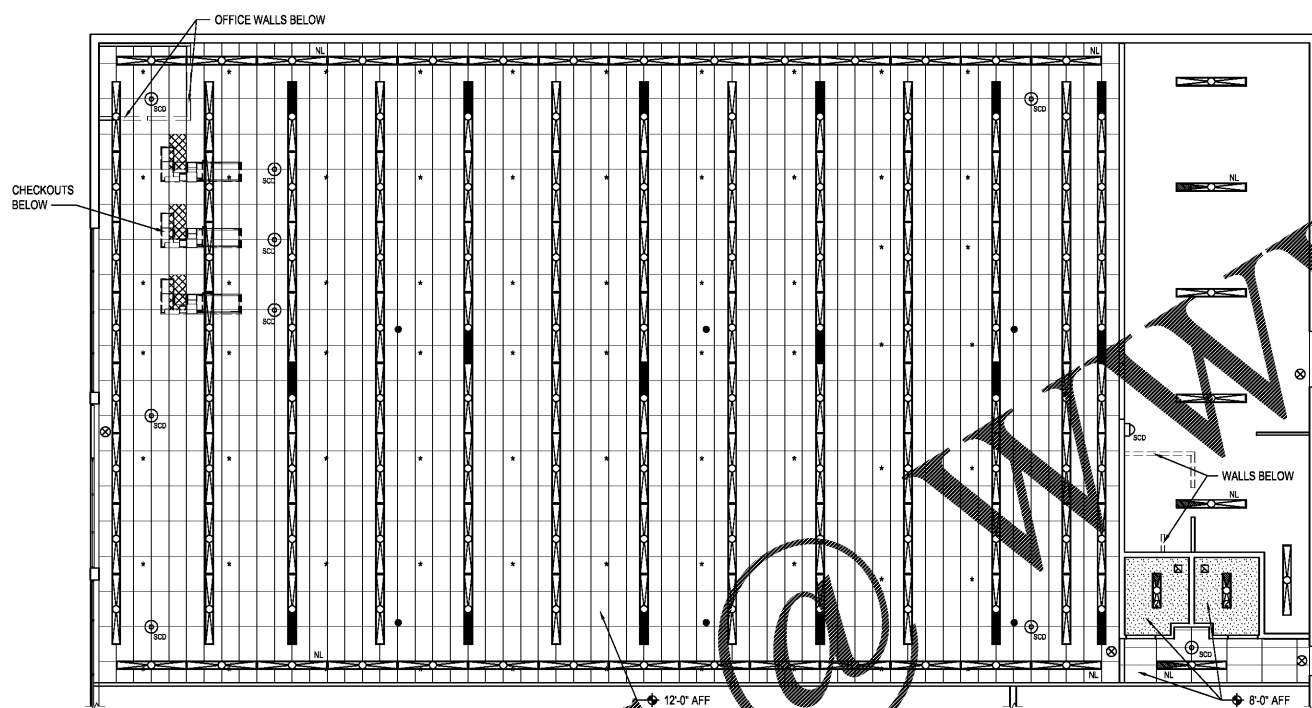

**REFLECTED CEILING PLAN**  
SCALE: 1/8" = 1'-0"

NOTE: 1. SECURITY CAMERA DOMES, SENSOR PANELS, OCCUPANCY SENSORS AND POWER POLES (UON) ARE TENANT SUPPLIED / CONTRACTOR INSTALLED.  
NOTE: 2. STAIRROOM LIGHTS MOUNTED 10'-0" AFF.

REFLECTED CEILING LEGEND	
	EXISTING 20"x4'-0" ACOUSTICAL CEILING TILE AND GRID - SEE FINISH NOTE 4.
	GWB - PAINT WHITE UNLESS OTHERWISE NOTED.
	EXIST 8'-0" STRIP LED LIGHT FIXTURE WITH LAMPS ON NIGHT LIGHT CIRCUIT. SURFACE MOUNT TO GWB AND ACT CEILING.
	EXIST 8'-0" STRIP LED LIGHT FIXTURE. SURFACE MOUNT TO GWB AND ACT CEILING.
	EXIST 8'-0" STRIP LED LIGHT FIXTURE WITH LAMPS ON EMERGENCY LIGHT CIRCUIT WITH BATTERY PACK. SURFACE MOUNT TO GWB AND ACT CEILING. FOR FIXTURES WITH 4 LAMPS, THE EMERGENCY BATTERY PACK WILL ONLY OPERATE 2 OF THE LAMPS.
	EXIST 4'-0" STRIP LED LIGHT FIXTURE WITH LAMPS ON NIGHT LIGHT CIRCUIT. SURFACE MOUNT TO TO GWB AND ACT CEILING.
	EXIST 4'-0" STRIP LED LIGHT FIXTURE WITH LAMPS ON EMERGENCY LIGHT CIRCUIT WITH BATTERY PACK. SURFACE MOUNT TO TO GWB AND ACT CEILING.
	EXIST 4'-0" STRIP LED LIGHT FIXTURE. SURFACE MOUNT TO ACT AND GWB CEILING.
	EXIT LIGHT
	SECURITY CAMERA DOME
	SECURITY CAMERA DOME MTD ON WALL @ 10'-0" AFF.
	VENTILATION FAN
	CEILING HEIGHT ABOVE FINISH FLOOR
	MIRROR PANEL
	DIFFUSER
	POWER POLE
	SPRINKLER HEAD (SHOWN FOR INFORMATIONAL PURPOSES ONLY. SPRINKLER CONTRACTOR SHALL PREPARE DRAWINGS AS REQUIRED BY CODE FOR RELOCATION OR ADDITION OF HEADS.)

description	
by	
date	revisions
mark	
date	
project	designed
drawn	checked
date	date
project	date
<p><b>RRMM</b> ARCHITECTS, P.C. 1317 Executive Blvd, Suite 200 Chesapeake, VA 23320 (757)622-2828 / fax (757)622-6883</p>	
<p><b>DOLLAR TREE</b> OAKBROOK STATION, DEAL #10854 SUMMERSVILLE, SOUTH CAROLINA REFLECTED CEILING PLAN AND LEGEND</p>	
project	drawing
sheet	
A2	