


ROOF LEGEND	
	ROOF HATCH WITH INTEGRAL STEEL CURB & FLASHING - SEE 2E/A303
	MEMBRANE WALKWAY TO ALL SERVICE SIDES OF ROOF TOP MOUNTED EQUIPMENT - VERIFY LOCATION PRIOR TO INSTALLATION. WALKWAY PADS SHALL BE PURCHASED WITH PVC ROOFING MEMBRANE, INSTALLED AND LOCATED PER MANUFACTURER'S SPECIFICATIONS AND WARRANTY. COLOR OF WALKWAY TO CONTRAST ROOF COLOR - GRAY
	SCUPPER/OVERFLOW & DOWNSPOUT SEE DETAILS ON A303
	TAPERED INSULATION, SLOPE 1/4" PER FT

GENERAL NOTES	
1	HVAC VENDOR TO PROVIDE ROOF CURBS AND VENDOR IS RESPONSIBLE FOR PROVISION/COORDINATION OF ROOF PENETRATIONS REQUIRED FOR EQUIPMENT INSTALLATION.
2	JOIST MANUFACTURER TO VERIFY STRUCTURAL JOIST CAPACITY BASED UPON FINAL ROOF TOP MOUNTED MECHANICAL PLAN AND WEIGHTS SUPPLIED BY MECHANICAL ENGINEER.
3	FLASH ROOF VENT PIPES. SEE 1D/A302
4	PROVIDE 6x4 WID SLEEPERS AT ALL CONDENSING UNIT AND SATELLITE DISH LOCATIONS - SEE DETAIL 6E/A302
5	INSTALL ROOF TOP MOUNTED MECHANICAL UNITS ON PREFINISHED METAL CURB WITH TREATED WOOD NAILER. REFER TO DETAILS AS INDICATED ON THIS SHEET. SEE MECHANICAL DRAWINGS FOR NUMBER, SIZE, HEIGHT, WEIGHT, AND FINAL LOCATION OF ROOF TOP MOUNTED MECHANICAL EQUIPMENT.
6	VENT PIPES TO BE 1/2" MINIMUM FROM AIR INTAKE.
7	ROOF PENETRATIONS, CURBS, AND SLEEPERS TO BE INSTALLED BY LANDLORD APPROVED ROOFER. REFER TO INFORMATIONAL DETAILS ON A302 AND A303.
8	NEW ROOF MEMBRANE TO BE INSTALLED BY MANUFACTURER APPROVED LICENSED ROOFING CONTRACTOR. REFER TO DETAILS AS INDICATED ON THIS SHEET. SPECIFICATIONS FOR NEW ROOF CRICKETS PER MANUFACTURER'S RECOMMENDATIONS.
9	ALL GAS PIPING TO ROOF SHALL BE PAINTED TO MATCH ADJACENT FINISH.
10	PROVIDE POWER AND BLOCKING FOR ALL BUILDING SIGNAGE. COORDINATE WITH SIGN VENDOR FOR RTU LOCATION DIMENSIONS. SEE STRUCT. ROOF FRAMING PLAN.
11	COORDINATE DIMENSIONS OF OPENINGS FOR ALL ROOF MOUNTED EQUIPMENT WITH THE VENDOR.
12	ROOF INSULATION IS "R" VALUE 30 (DOES NOT INCLUDE PATIO ROOF).

KEY NOTES			
1	DOWNSPOUT TO STORM DRAINAGE. REFER TO CIVIL DRAWINGS	19	BENT METAL PLATE
2	ROOF TOP HVAC UNIT. MOUNT ON PRE-FINISHED METAL CURB - REFER TO 2E/A302, COORDINATE STRUCTURE - SEE MECH DWGS	20	TUBE STEEL BEAM BELOW - REFER TO STRUCTURAL DRAWINGS
3	CRICKETS AROUND NEW ROOF EQUIPMENT CURBS - SLOPE 1/2" PER FOOT MIN	21	SLOPE ROOF MEMBRANE TO SCUPPER/DOWNSPOUT AT 1/4" PER 1'-0"
4	REF MECHANICAL ROOF PLAN FOR LIGHTS AND OUTLETS AT UNITS	22	CONSTRUCT WALL ON TOWER BACKSIDE TO MATCH SIDES EXCEPT BOTTOM OF WALL IS OPEN. TOP OF WALL IS 25'-0" AND BOTTOM OF WALL IS 21'-0". WALL IS FOR BRACING SIDES OF TOWER.
5	SHEET METAL COPING (SHT MET-1) OVER EHS SIGN WALL. REFER TO A302	23	UPLIGHT - REFER TO MEP
6	CONTINUOUS PREFINISHED GUTTER	24	LED WALL PACK - REFER TO MEP
7	CONDENSING UNIT FOR WALK IN BOXES. COORDINATE LOCATION WITH KITCHEN EQUIPMENT VENDOR REFER TO 1E/A302 FOR TYPICAL SUPPORTS		
8	CONDENSING UNIT FOR ICE MAKER. COORDINATE LOCATION WITH KITCHEN EQUIPMENT VENDOR. RUN REFRIGERANT LINES ABOVE CEILING IN KITCHEN. REFER TO 8E/A302 FOR TYPICAL SUPPORT		
9	HOODED PAN FOR REFRIGERANT LINES, ELEC, ETC - REF 1E/A303 - VERIFY FINAL LOCATION WITH EQUIPMENT		
10	APPROXIMATE LOCATION OF SATELLITE DISH PROVIDED BY AV CONTRACTOR 8E/A302. SIM AV VENDOR TO SUPPLY STEEL FRAME. COORDINATE PENETRATION WITH THE AV INSTALLER.		
11	PENETRATION FOR SATELLITE CABLE COORDINATE EXACT LOCATION WITH AV CONTRACTOR, SEE DETAIL 1C/A302.		
12	SIGNAGE, REFER TO ELEVATIONS, ELEC. COORDINATE BLOCKING REQUIREMENTS WITH SIGN VENDOR.		
13	SHEET METAL COPING (SHT MET-1), TYP AT ALL PARAPETS		
14	NOT USED		
15	ROOF HATCH, SEE DETAIL 3E/A206 AND 2E/A303		
16	SINGLE PLY MEMBRANE ROOF SYSTEM, CONTINUE MEMBRANE OVER TOP OF PARAPETS. TYP. OVER RIGID INSULATION (INSL 3). PROVIDE SHOP DRAWINGS OF ROOF INSULATION APPLICATION. REFER TO SPECIFICATIONS FOR "R" VALUE.		
17	EXHAUST FANS - SEE MECHANICAL DRAWINGS. REFERENCE 1A/A302 FOR GREASE EXHAUST PENETRATION DETAIL		
18	VENT THRU ROOF - REFERENCE PLUMBING SHEETS AND DETAIL 1D/A302		

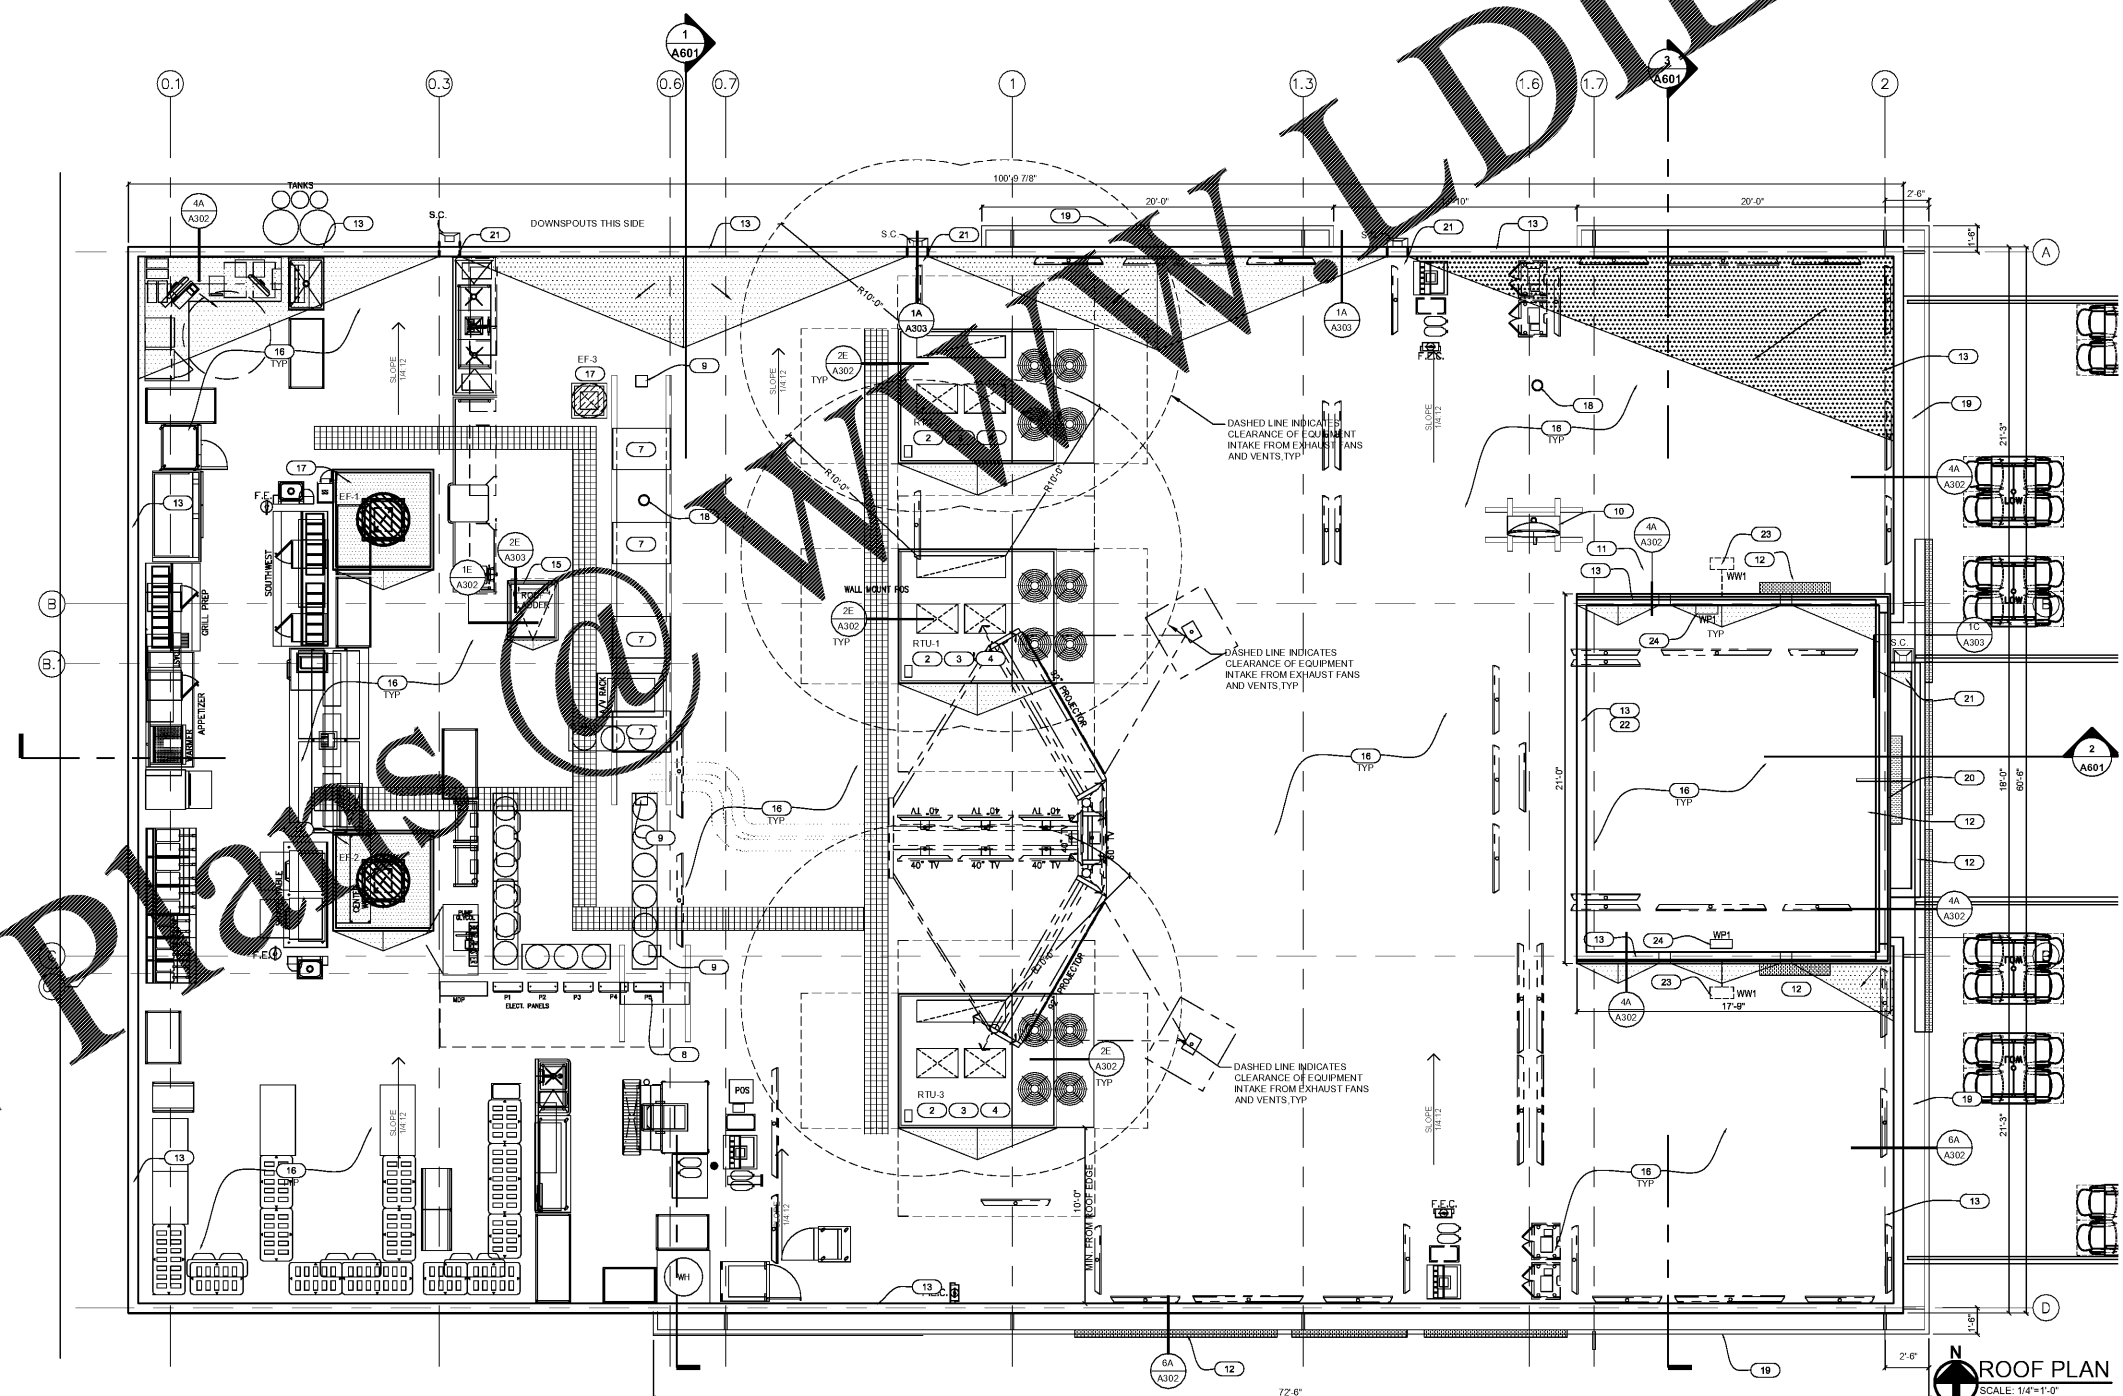

CERTIFICATION

PRANGER GROUP INC.
PROJECT MANAGER

PROJECT NUMBER
5748

BUFFALO WILD WINGS
BIRMINGHAM
1416 4th AVENUE SOUTH,
BIRMINGHAM, AL 35233



DRAWING ISSUE	
NO	DESCRIPTION
1	
2	
3	
4	
5	
6	
7	

Drawing Title
ROOF PLAN

A301

Order Plans

WWDLine.com