

LIGHTING LEGEND					
SYMBOL	DESCRIPTION	MOUNTING	SYMBOL	DESCRIPTION	MOUNTING
	RECESSED ADJUSTABLE 3 HEAD LED	RECESSED		CANTILEVERED LINEAR LED WALL WASHER ASYMMETRIC REFLECTOR	WALL STEM MOUNTED
	COMPACT FLUORESCENT RIM DOME WITH GUARD	PENDANT (CHASE NIPPLE)		LINEAR WARM LED WASH LIGHT, INTEGRAL POWER SUPPLY & GLARE SHIELD	PENDANT MOUNTED
	EMERGENCY LIGHT W/ TWO 1.5W LED HEADS	WALL MOUNT		RECESSED 2x4 FLUORESCENT	RECESSED
	OUTDOOR LED EMERGENCY LIGHT	WALL MOUNT		COMPACT FLUORESCENT DOWNLIGHT	RECESSED
	EMERGENCY LIGHT W/ TWO 3.6W HEADS	SURFACE MOUNT B.O. JOIST		COMPACT FLUORESCENT WALL WASH	RECESSED
	SINGLE FACE LED EXIT SIGN	TOP OR BACK MOUNT		LINEAR T8 FLUORESCENT WALL WASH	WALL MOUNTED
	SINGLE FACE LED EXIT SIGN WITH EMERGENCY HEADS	TOP OR BACK MOUNT		LINEAR LED RIBBON LIGHT WITH WET LOCATION LABEL, REMOTE POWER SUPPLIES	SURFACE
	DOUBLE FACE LED EXIT SIGN WITH EMERGENCY HEADS	TOP MOUNT		LINEAR LED RIBBON LIGHT WITH REMOTE POWER SUPPLIES	SURFACE


KEY NOTES	
1 "OPEN CEILING" AREA, ROOF JOISTS, DECK, CONDUIT, FIXTURES, ETC. PAINT (EXP-1)	15 5/8" GYPSUM BOARD, SEE CEILING DETAIL 1E/A207
2 EXHAUST HOOD, SEE MECHANICAL DRAWINGS	16 PATIO HEATERS, SEE MECHANICAL AND STRUCTURAL
3 ROOF HATCH & LADDER - SEE DETAIL 3E/A206	17 COOLER / FREEZER CEILING BY COOLER MANUFACTURER - OPEN TO STRUCTURE ABOVE COOLER / FREEZER
4 NOT USED	18 LED LIGHT FIXTURE ATTACHED TO UNDERSIDE OF MILLWORK - SEE ELECTRICAL
5 BENT METAL PLATE	19 CEILING FAN - CEILING MOUNT - SEE ELECTRICAL
6 SIGNAGE ABOVE SHOWN DASHED	20 TRACK LIGHT FIXTURE - SEE ELECTRICAL
7 NOT USED	21 SEE CIVIL AND ELECTRICAL DRAWINGS FOR LED BOLLARD INFORMATION
8 PATIO PURLIN, SEE STRUCTURAL	22 COORDINATE LIGHTING TO WALK-IN COOLER BOXES WITH KITCHEN VENDOR
9 STEEL VIDEO SUPPORT STRUCTURE PAINT, SEE STRUCTURAL & SHEET A209	23 PIPE-MOUNTED TELEVISIONS TYP. UNO
10 STEEL ROOF DECK	24 WALLS, FLOORS, AND CEILINGS IN KITCHEN, PREPARATION, SERVICE, WASHING AND BAR AREAS, OR ANY OTHER LOCATION WHERE FOOD OR BEVERAGES ARE PREPARED, SHALL BE LIGHT COLORED, SMOOTH, EASILY CLEANABLE, NON ABSORBENT AND DURABLE
11 PENDANT HUNG TRACK LIGHTING MOUNTED AT 14" AFF AT SERVER STATION - SEE ELECTRICAL	25 PROVIDE PROTECTIVE COVERS ON LIGHTS IN FOOD STORAGE, PREPARATION AND UTENSIL WASH AREA
12 CEILING CLOUD, SEE 5C/A402	26 LOCATION OF BEER LINE TROUGH - REFER TO MECH DRWS FOR MORE INFORMATION
13 WOOD STUD DROP DOWN HEADER WITH MOISTURE RESISTANT GYPSUM BOARD AND FRP FINISH ALIGN WITH FACE OF WALK-IN BOX.	
14 WRAP (3) EDGES OF OPENING WITH STAINLESS STEEL PROVIDED BY KITCHEN EQUIPMENT VENDOR, WCG-3	

GENERAL NOTES	
1 STUDY AND COMPARE THE REFLECTED CEILING PLANS WITH THE MECH AND ELEC DRAWINGS FOR LUMINAIRES, DIFFUSERS, AND GRILLES. REPORT TO THE ARCHITECT ANY ERROR, INCONSISTENCY, OR OMISSION DISCOVERED	27 ILLUMINATED RESTROOM SIGN - PROVIDE POWER, REF MEP SIZE TO BE VERIFIED WITH SIGN VENDOR. PROVIDE BLOCKING AS REQUIRED
2 VERIFY AND PROVIDE ACCESS PANELS OF APPROPRIATE SIZE AND TYPE ARE INSTALLED IN GYPSUM BOARD CEILINGS/ SOFFITS OR ANY OTHER NON ACCESSIBLE TYPE CEILINGS OR SOFFITS WHERE ACCESS, SERVICE OR ADJUSTMENT TO MEP ITEMS MAY BE REQUIRED	28 ELECTRIC UNIT HEATER - SEE ELECTRICAL
3 SPRINKLER HEADS, DIFFUSERS, INCANDESCENT LUMINAIRES, AND OTHER SURFACE MOUNTED OR RECESSED CEILING ITEMS SHALL BE LOCATED IN THE CENTER OF THE CEILING PANELS, UNLESS NOTED OTHERWISE	29 NOT ALL HVAC DUCTWORK NOT SHOWN ON THIS DRAWING REFER TO MECH DRWS FOR LAYOUT. PAINT ALL EXPOSED DUCTWORK (EXP-2)
4 SEE MECHANICAL AND ELECTRICAL DWGS FOR INFO AND SPECS CONCERNING FIXTURES SHOWN ON THIS PLAN	30 SEE 2D/A304 FOR MOUNTING LIGHT FIXTURES AT STEEL CHANNEL
5 WHERE GYP BD SOFFIT OR BREAKHEAD OCCURS WITH SUSPENDED CEILING, EXTEND AND PAINT GYP. BD. TO 6" MIN. ABOVE SUSPENDED CEILING.	31 LOCATION OF ACCESS PANEL IN WALL ABOVE COOLER REFER TO DETAIL 3C/A402
6 ALL EXPOSED AND INSULATED PIPING SHALL HAVE HARD, PAINTABLE FINISH. COORDINATE WITH AV VENDOR AND SUBCONTRACTORS TO CONFIRM THAT THERE ARE NO OBSTRUCTIONS OR LIGHTS IN THE WAY OF THE AV PROJECTOR PATH TO SCREENS	32 GRAY HATCHED AREA DENOTES DUCTWORK ABOVE, REFER TO MECH DWGS
7 COORDINATE WITH AV VENDOR AND SUBCONTRACTORS TO CONFIRM THAT THERE ARE NO OBSTRUCTIONS OR LIGHTS IN THE WAY OF THE AV PROJECTOR PATH TO SCREENS	33 BLACK EGGRATE ABOVE AV RACK TO MATCH EXPOSED DUCTWORK, USE ALUM GRID SYSTEM WALL ANGLES FOR MOUNTING
8 CEILING TYPES AND FINISHES, SEE FINISH SCHEDULE ON A106	34 BOTTOM OF TV AT 8'-0" AFF
9 MOUNT CYLINDER LIGHT FIXTURES IN AREAS WITH "OPEN CEILINGS" TO DECK (SEE ELECTRICAL)	35 2'-0" x 2'-0" CEILING ACCESS PANEL
10 CENTER LIGHT FIXTURES LOCATED IN SUSPENDED CEILING GRID UPON PIPING THAT RUN THROUGH SPACE	36 PROVIDE VENTILATION THROUGH SHIG-1 BY CUTTING A 6"x18" OPENING CENTERED ABOVE THE LIGHT FIXTURES. COVER OPENING WITH 10"x22" PERFORATED METAL COVER PLATE - PERFORATIONS NOT TO EXCEED 1/2" IN DIAMETER
11 INSULATING PIPE WRAP W/ HARD PAINTABLE FINISH ON ALL ROOF DRAINS AND PIPING THAT RUN THROUGH SPACE	
12 SEE 50N AND A207 FOR DOOR TYPES AND DETAIL CONDITIONS	
13 IN THE EVENT OF INCONSISTENCIES BETWEEN ARCHITECTURAL AND CONSULTANT PLANS, THE ARCHITECTURAL SHEET SHALL TAKE PRECEDENCE. REPORT DISCREPANCIES PRIOR TO PROCEEDING, WITH AFFECTED WORK DIMENSIONS ARE TO FACE OF FRAMING UNLESS NOTED OTHERWISE	
14 TELEVISION MONITORS AND TELEVISION PROJECTOR UNITS BY OWNER. FOR ALL EXTERIOR LIGHT FIXTURES, REFER EXTERIOR ELEVATIONS FOR MOUNTING HEIGHTS. COORDINATE WITH MEP	
15 REFER DETAIL 4B/A401 FOR TYPICAL SUPPORT FOR ALL LIGHT FIXTURES IN LUN CEILING GRID	

CEILING FINISHES	
EXP-1	EXPOSED STRUCTURE "OPEN CEILING" - ROOF JOISTS, DECK, CONDUIT, FIXTURES, ETC. PAINT (PS-24C-2)
EXP-2	EXPOSED DUCTWORK IN "OPEN CEILING" AREA. PAINT (PS-24C-3) REFER TO MECHANICAL DRAWINGS FOR EXTENT OF DUCTWORK
ACT-1	2X4 VINYL FACED GYPSUM PANELS
GYP BD	GYPSUM BOARD CEILING

NOTE: SEE FINISH SCHEDULE ON SHEET A106 FOR ADDITIONAL INFORMATION

MECHANICAL LEGEND	
SYMBOL	DESCRIPTION
	MECHANICAL SUPPLY DIFFUSER
	MECHANICAL RETURN

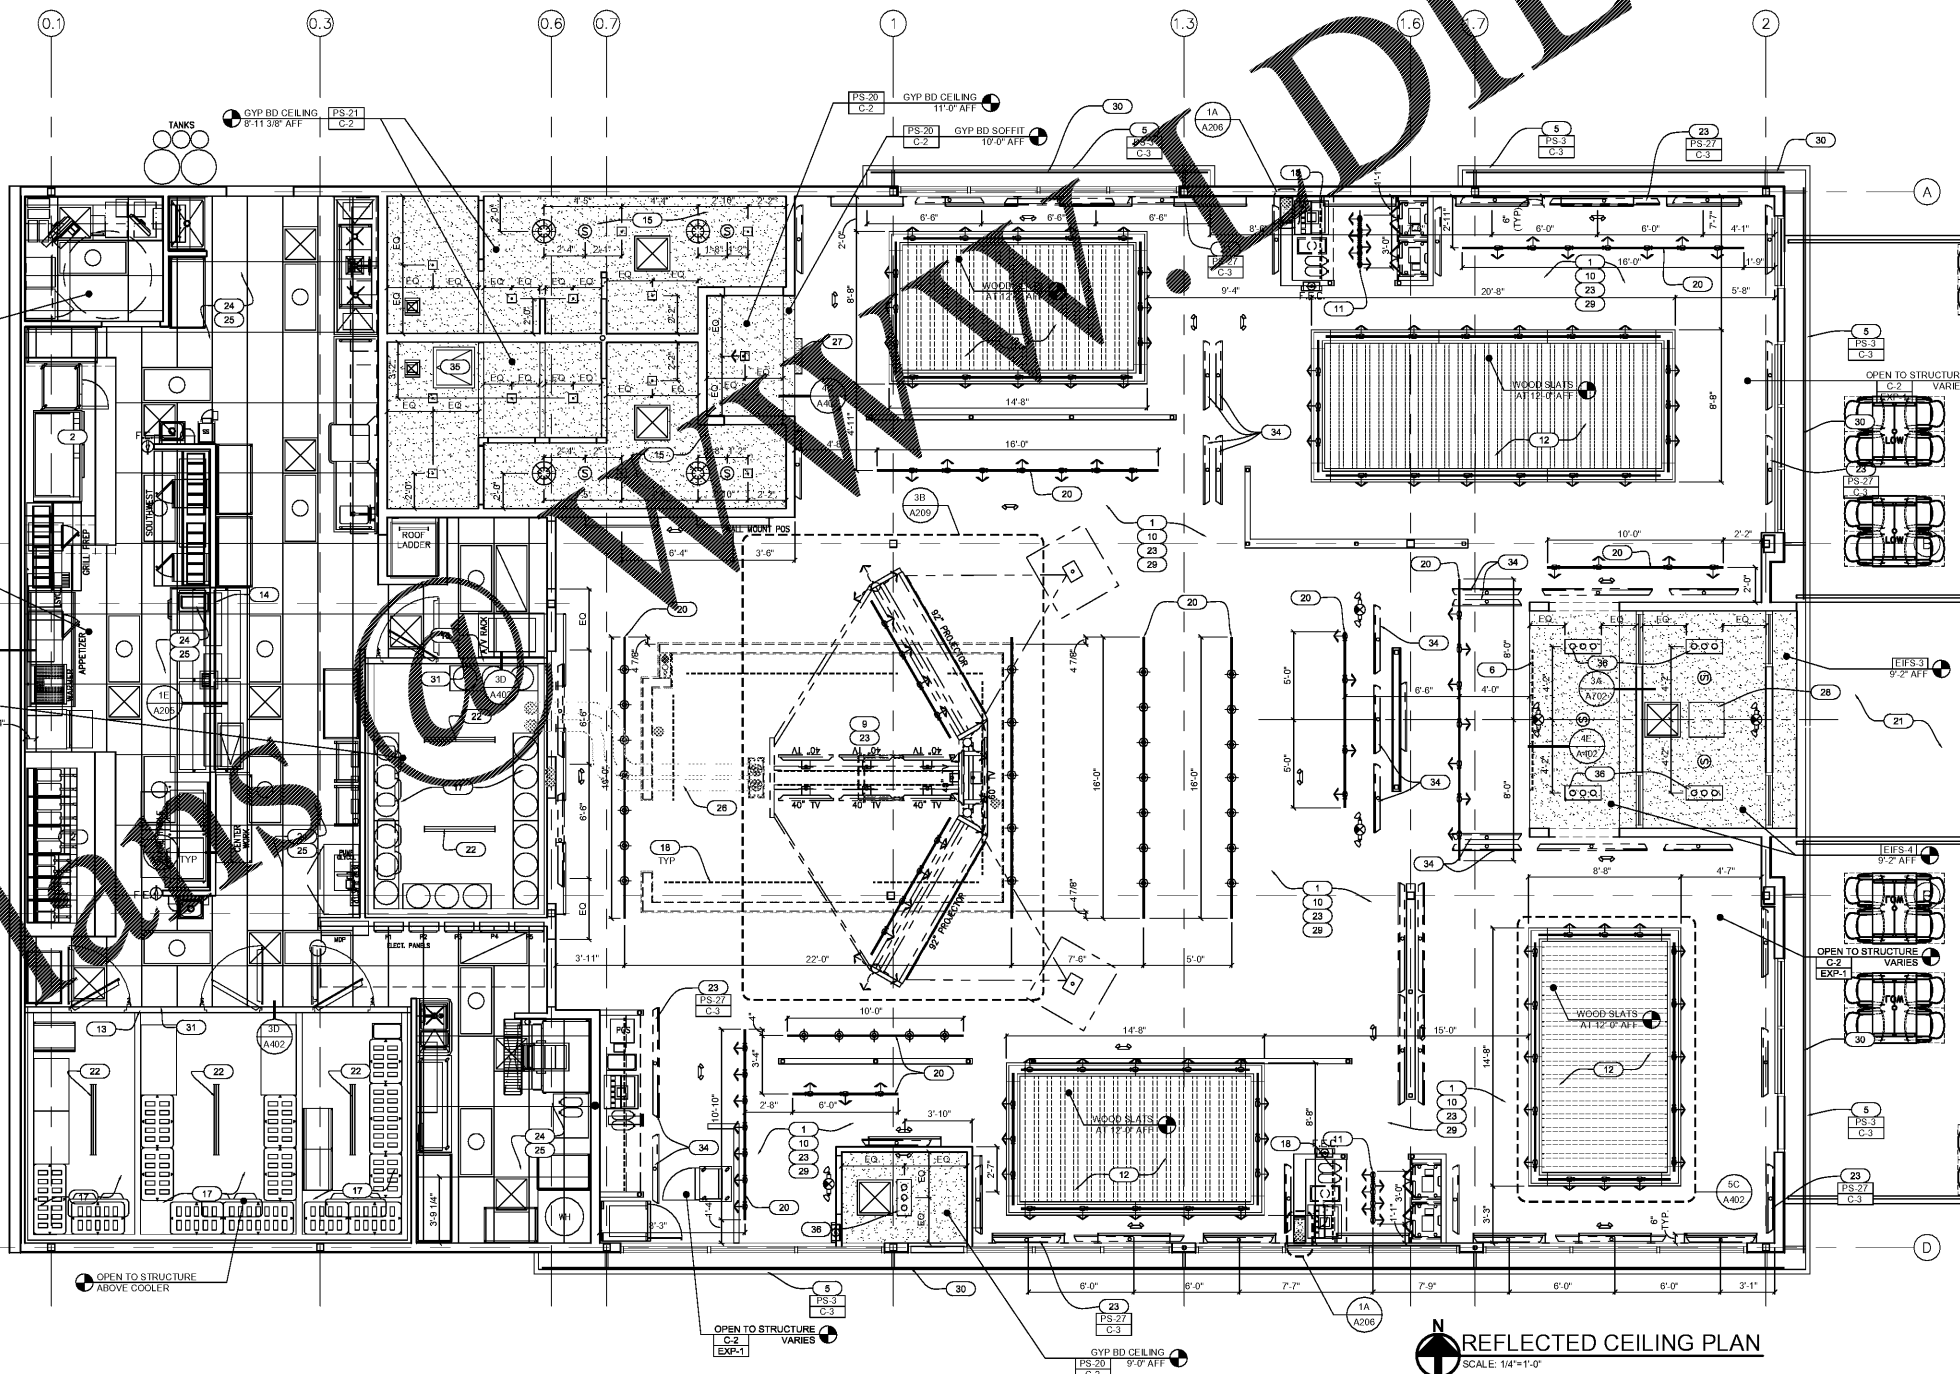

Order Plans

WWW.DILLING.COM

CERTIFICATION

PRANGER GROUP INC.
PROJECT MANAGER

PROJECT NUMBER
5748

BUFFALO WILD WINGS
BIRMINGHAM
1416 4th AVENUE SOUTH,
BIRMINGHAM, AL 35233



DRAWING ISSUE	
NO	DESCRIPTION
1	
2	
3	
4	
5	
6	
7	

Drawing Title
REFLECTED CEILING PLAN

A401