

LEGEND


KITCHEN EQUIPMENT IDENTIFICATION TAGS AND DETAIL KEYS. SEE KITCHEN EQUIPMENT PLANS FOR ITEMS SHOWN WITH THESE MARKINGS ON THIS SHEET, AND A COMPLETE LIST OF EQUIPMENT FOR THIS PROJECT.

SANITARY WASTE PIPING
 GREASE WASTE PIPING
 WASTE VENT PIPING

FLOOR DRAIN
 FLOOR DRAIN W/FUNNEL
 TRENCH DRAIN
 FLOOR SINK

- PLUMBING NOTES**
- CONTRACTOR TO COORDINATE WITH ALL REQUIREMENTS OF FOOD SERVICE PLANS AND PROVIDE ALL WORK SHOWN, ON BOTH PLUMBING AND KITCHEN PLANS.
 - PROVIDE PIPE BRACING FOR INDIRECT WASTE PIPING. BRACE PIPING FROM EQUIPMENT OR BACK WALL TO PREVENT MOVEMENT OR DAMAGE. CONTRACTOR TO INSTALL INDIRECT WASTE PIPING FROM EQUIPMENT TO DRAIN RECEPTOR BELOW. TERMINATE WITH CODE APPROVED AIR-GAP. VERIFY INDIRECT WASTE FOR ALL EQUIPMENT. REFERENCE KITCHEN PLANS FOR SIZING.
 - ALL WORK TO BE IN COMPLIANCE WITH PREVAILING CODES.
 - DRAIN LINES TO BE INSIDE OF WALLS. SURFACE MOUNTED WORK IS NOT ACCEPTABLE.
 - PROVIDE ALL INDIRECT WASTE LINES (i.e., WALK-IN COOLERS/FREEZERS, REFRIGERATED BASES, HOT WELLS).
 - REFER TO K. DRAWINGS FOR DIMENSIONS TO LOCATE FLOOR DRAINS, FLOOR SINKS AND TUBE CONDUITS.
 - CLEAN AND VIDEO ALL SEWER LINES OUT TO POINT OF CONNECTION WITH SEWER MAINS. PROVIDE THE VIDEOS TO THE G.C. FOR INCLUSION IN THE CLOSE-OUT SUBMITTALS.
 - REFER TO SECTION 3.06 OF SPECIFICATION 20.0660 BASIC MATERIALS AND METHODS FOR PIPE IDENTIFICATION REQUIREMENTS.

- KEY NOTES**
- CONNECT TO SANITARY WASTE PIPING. SEE CIVIL SITE UTILITY PLANS FOR CONTINUATION.
 - FLOOR DRAIN WITH TRAP PRIMER. SEE WATER AND GAS PLAN P201. RECESS TOP OF DRAIN 1" BELOW FINISH FLOOR AND SLOPE A 4 FT. RADII TO DRAIN.
 - VENT PIPING IN WALL AT 42" ABOVE FINISHED FLOOR. SEE PLUMBING RISER DIAGRAM.
 - VENT THRU ROOF. TO BE INSTALLED 10'-0" MIN. FROM ANY FRESH AIR INTAKE ON ROOF (30'-0" FOR BUILDINGS WITH SEPTIC SYSTEMS). COORDINATE WITH MECHANICAL EQUIPMENT ON ROOF.
 - CONDENSATE DRAIN LINE FROM COOLER EQUIPMENT SLOPE @ 1/4" FT. PROVIDE AND INSTALL INSULATION OVER HEAT TAPE. REFER TO KITCHEN PLANS AND DETAIL 4B-P102, AND 4E-F102.
 - AREA FLOOR DRAIN FOR WASH DOWN. NO TRAP PRIMER REQUIRED IN KITCHEN WET FLOOR AREAS. RECESS TOP OF DRAIN 1" BELOW FINISH FLOOR AND SLOPE FLOOR TO THE DRAIN TYPICAL OF AREA DRAINS IN KITCHEN. REFER TO STRUCTURAL PLANS FOR ADDITIONAL INFORMATION.
 - FLOOR DRAIN FOR INDIRECT WASTE. NO TRAP PRIMER REQUIRED. DO NOT SLOPE FLOOR AT THIS DRAIN. SEE KITCHEN PLANS.
 - FLOOR SINK TO RECEIVE DRAIN PIPING FROM WATER HEATER. TERMINATE 1/8" RELIEF DRAIN AT FLOOR SINK WITH CODE APPROVED AIR-GAP. PROVIDE TRAP PRIMER. SEE WATER AND GAS PLAN P201.
 - FLOOR RECEPTOR FOR INDIRECT WASTE FROM EQUIPMENT. REFER TO KITCHEN PLANS.
 - TRENCH DRAIN IN FLOOR WITH GRATE. INSTALL DRAIN FLUSH WITH FINISHED FLOOR. SEE PLUMBING FIXTURE SCHEDULE FOR SPECIFICATION.
 - PROVIDE INDIRECT WASTE. TYPICAL. COORDINATE WITH KITCHEN EQUIPMENT SUPPLIER AND GENERAL CONTRACTOR. REFERENCE KITCHEN PLANS FOR SIZING. PROVIDE SUPPORT BRACING AS NOTED. SEE DETAIL 4B-P102.
 - FLOOR SINK AT SODA STATION TO BE SET FLUSH WITH FLOOR AND PROJECT HALF EXPOSED UNDER MACHINE. REFER TO KITCHEN PLANS. PROVIDE AND INSTALL PVC INDIRECT WASTE PIPING FOR BEVERAGE STATION. TERMINATE AT F.S. WITH AIR-GAP.
 - ROUTE SANITARY VENT IN WALL 6" ABOVE THE FLOOR RIM OF THE HAND SINK.
 - NOT USED.
 - CONDENSATE DRAIN LINE FROM COOLER EQUIPMENT. SLOPE 1/4" FT.
 - 6" DIAMETER UNDER FLOOR CONDUIT FOR SODA SUPPLY LINES. PROVIDE ADDITIONAL 4" DIAMETER UNDER FLOOR CONDUIT FOR FUTURE SODA BUNDLES. COORDINATE WITH SODA VENDOR.
 - 6" DIAMETER UNDER FLOOR CONDUIT FOR BEER SUPPLY LINES. COORDINATE INSTALLATION WITH BEER SYSTEM VENDOR.

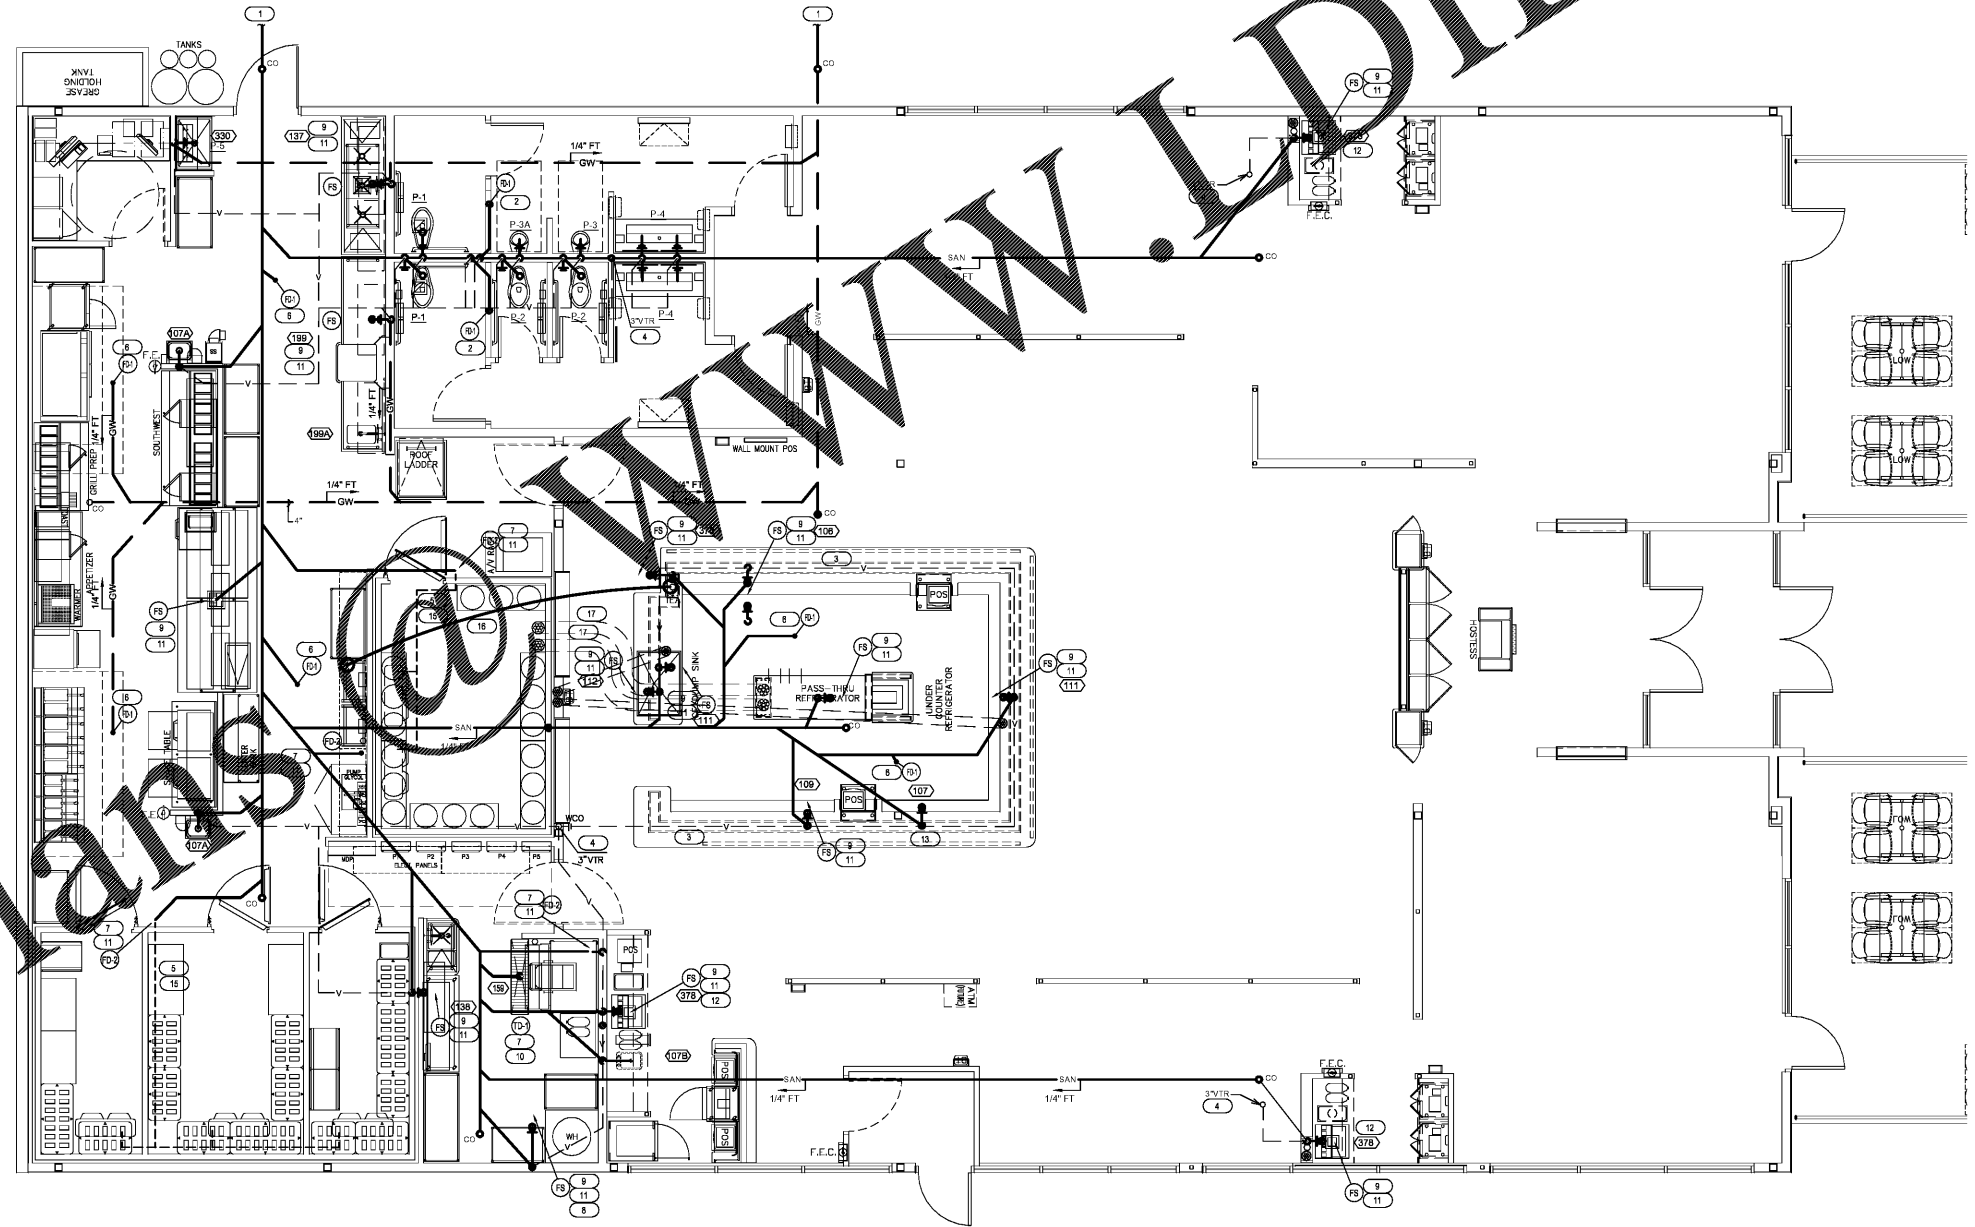

Order Plans @ www.wildwings.com

CERTIFICATION

PRANGER GROUP INC.
PROJECT MANAGER

PROJECT NUMBER
5748

BUFFALO WILD WINGS
BIRMINGHAM
1416 4th AVENUE SOUTH,
BIRMINGHAM, AL 35233



DRAWING ISSUE

NO	DESCRIPTION	DATE
1		
2		
3		
4		
5		
6		
7		

Drawing Title
WASTE & VENT FLOOR PLAN

WASTE & VENT PLAN
SCALE: 1/4"=1'-0"

P101