


Order Plans @

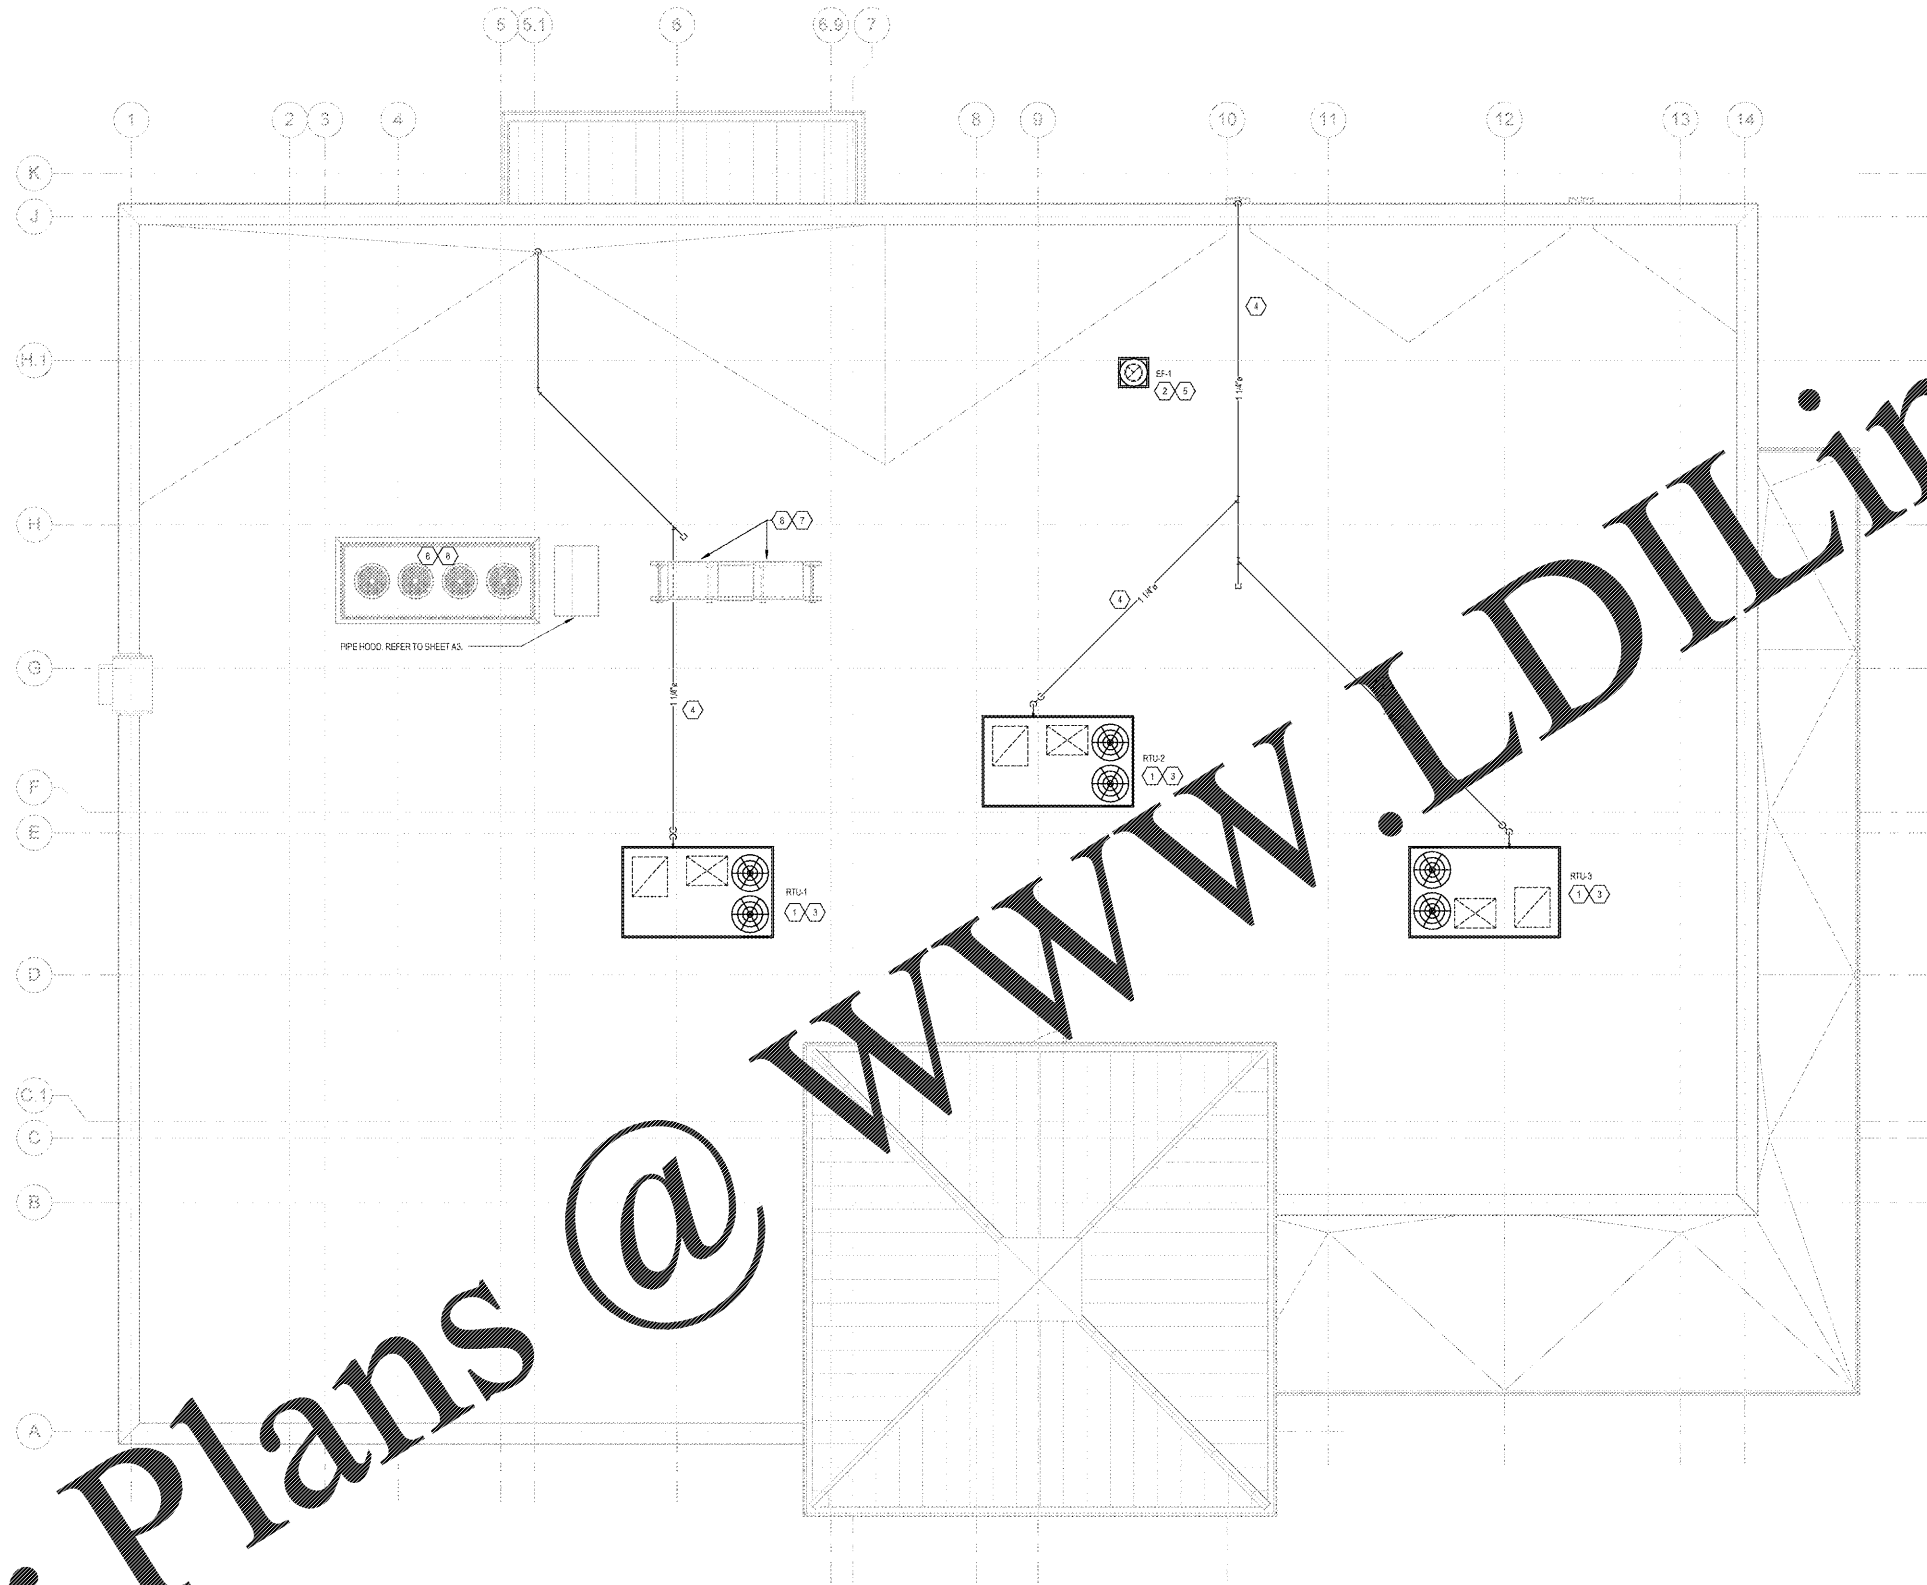

HVAC ROOF PLAN
M2

- KEY NOTES:**
- FACTORY INSTALLED SMOKE DETECTOR IN MAIN SUPPLY AND RETURN OF EACH ROOF TOP UNIT.
 - INSTALL ROOF MOUNTED EXHAUST FAN PER DETAIL SHEET M3. COORDINATE EXACT LOCATION OF PENETRATION WITH ARCHITECTURAL ROOF PENETRATION CALL VARIOUS DETAIL WORK. AS NECESSARY FROM FAN INTO CEILING/CLOSET SPACE. SEE SHEET M1 FOR CONTINUATION.
 - PROVIDE FLEXIBLE CONNECTION BETWEEN WORK AND MECHANICAL UNITS.
 - ROUTE 3/4" 40 P.S.I. EXHAUST DRAIN PIPES ALONG ROOF. SUPPORT HANGERS PER DETAIL ON SHEET M3.
 - MAINTAIN A MINIMUM CLEARANCE OF 18" ON INSIDE AIR INTAKES AND EXHAUSTS ON ROOF.
 - FOOD SERVICE REFRIGERATION EQUIPMENT PROVIDED BY OTHERS.
 - FOOD SERVICE REFRIGERATION EQUIPMENT MOUNTED ON ENGINEERED PAD. SEE DETAIL S ON SHEET A3 FOR PRODUCT APPROVAL INFORMATION.
 - FOR SPECIFIC WIND LOADING REQUIREMENTS: NOT TO EXCEED 100 MPH. SEE STRUCTURAL DRAWINGS.

SHEET NOTES:
CONTRACTOR RESPONSIBLE FOR USING CURBS PLUS CLIPS ON ALL RTU'S. CLIPS ARE DELIVERED TO SITE AS SEPARATE PACKAGE.

1925 Prospect Ave.
Orlando, FL 32814
P (407) 661-9100
F (407) 661-9101
www.rp.com

Cubaci & Retam Architects Engineers

CLIENT NAME
WAWA
260 WEST BALTIMORE PIKE
WAWA, PENNSYLVANIA 19053

PROJECT NAME
WAWA F85FB 2017.01 STORE #5294-CNY
26508 U.S. 19 NORTH
CLEARWATER, FL 33761

SHEET TITLE
HVAC ROOF PLAN

Revision Schedule	
No.	Description
1	PRELIMINARY
2	PRELIMINARY
3	PRELIMINARY
4	PRELIMINARY
5	PRELIMINARY
6	PRELIMINARY
7	PRELIMINARY
8	PRELIMINARY
9	PRELIMINARY
10	PRELIMINARY
11	PRELIMINARY
12	PRELIMINARY
13	PRELIMINARY
14	PRELIMINARY
15	PRELIMINARY
16	PRELIMINARY
17	PRELIMINARY
18	PRELIMINARY
19	PRELIMINARY
20	PRELIMINARY

PROJECT NO.
2017020

DATE
01/01/2017

DRAWN
RJK

CHECKED
JJD

M2