


Order Plans @

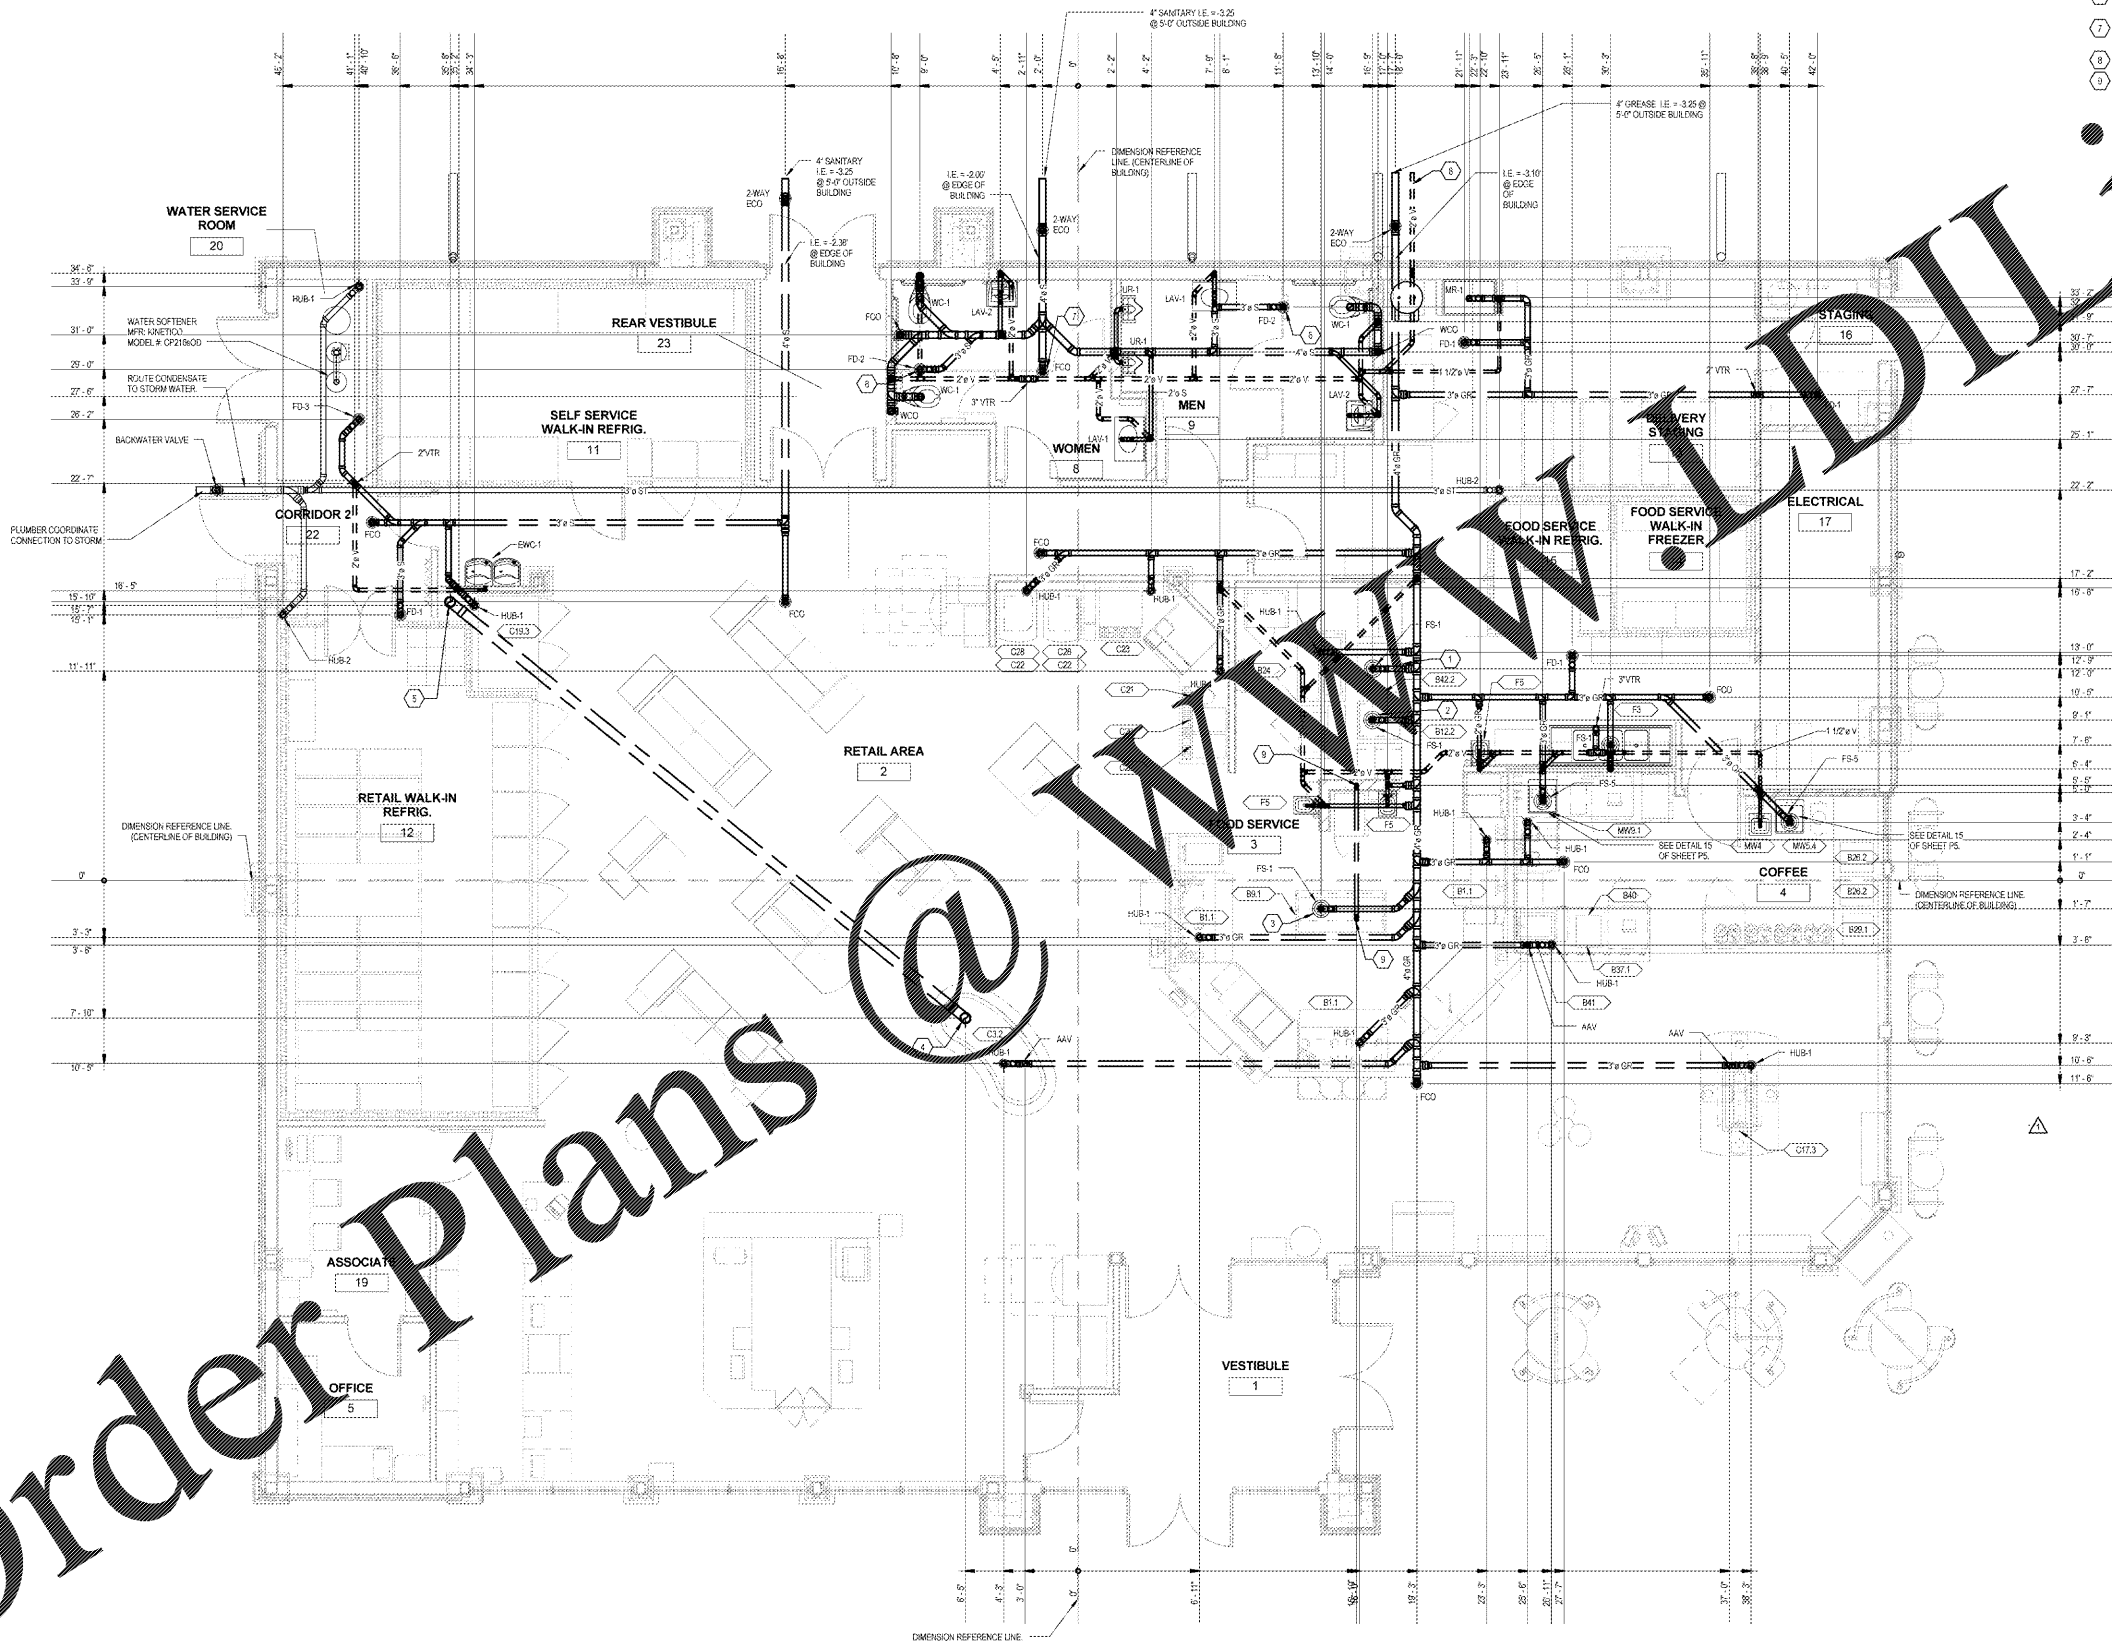

**SANITARY INVERT NOTE**  
 3.25' I.E. AT 5'-0" OUTSIDE BUILDING IS A COMMON ELEVATION FOR REFERENCE. COORDINATE ACTUAL ELEVATIONS WITH SITE CONTRACTOR WITH REGARDS TO SITE SANITARY MAIN INVERT.

- PLUMBING KEYNOTES**
- 2" COPPER PIPING FITTINGS TO ADAPT TO UNIT AND EXTEND TO THE FLOOR DRAIN.
  - MAKE THE FIRST 12" OF GREASE PIPING FROM FLOOR SINK AT THE B102 REHEAT/STERILIZER CAST IRON INSTEAD OF PVC.
  - MAKE THE FIRST 12" OF GREASE PIPING FROM FLOOR SINK AT THE B01 HOT FOOD TABLE CAST IRON INSTEAD OF PVC.
  - 8" SCHEDULE 40 ELECTRICAL PVC W/ LONG SWEEP ELBOWS SHALL BE USED FOR REFRIGERANT LINE CHASE. STUB UP 2" A.F.F. BY PLUMBING CONTRACTOR.
  - RUN REFRIGERATION PIPE DOWN IN WALL THRU 6" SCHEDULE 40 ELECTRICAL PVC W/ LONG SWEEP ELBOWS (STUB UP).
  - FLOOR DRAIN GRATE TO BE SET FLUSH WITH TOP OF CONCRETE AND CENTERED UNDER PARTITIONS.
  - FLOOR CLEANOUT TOP TO BE SET FLUSH WITH TOP OF CONCRETE AND CENTERED UNDER PARTITIONS.
  - 2" VENT TO BE CONNECTED WITH 1/2" GREASE INTERCEPTOR AT THE INLET AND 1/2" 1-1/2" PVC BELOW FLOOR FOR 1/2" HW LINE TO B01.

ROOF DRAIN TO BE PROVIDED WITH 1/2" 1-1/2" PVC AND 1/2" 1-1/2" OUTLET PIPE. SCALE PIPE DOWN TO 1/2" 1-1/2" PVC AND 1/2" 1-1/2" OUTLET PIPE. SEE SHEET PS FOR ROOF PLAN DRAINS AND FOR ROOF DRAIN AND PIPING INSTALLATION.

1925 Prospect Ave.  
 Orlando, FL 32814  
 P (407) 661-9100  
 F (407) 661-9101  
 www.cpa.com  
**Cabalci & Ret...**  
 Architects Engineers

CLIENT NAME  
**WAWA**  
 260 WEST BALTIMORE PIKE  
 WAWA, PENNSYLVANIA 19063

PROJECT NAME  
**WAWA F85FB 2017.01 STORE #5294-CNY**  
 26008 US 19 NORTH  
 CLEARWATER, FL 33761

SHEET TITLE  
**WASTE PIPING PLAN**

No.	Description	Date
1	PERMIT COMMENTS	01/17/2017
2	PRE-BID REVIEW SET	07/26/2017
3	BID SET	08/08/2017

PROJECT NO.  
 2016020

DATE  
 01/02/2017

DRAWN  
 BCS

CHECKED  
 Checker