


Order Plans @

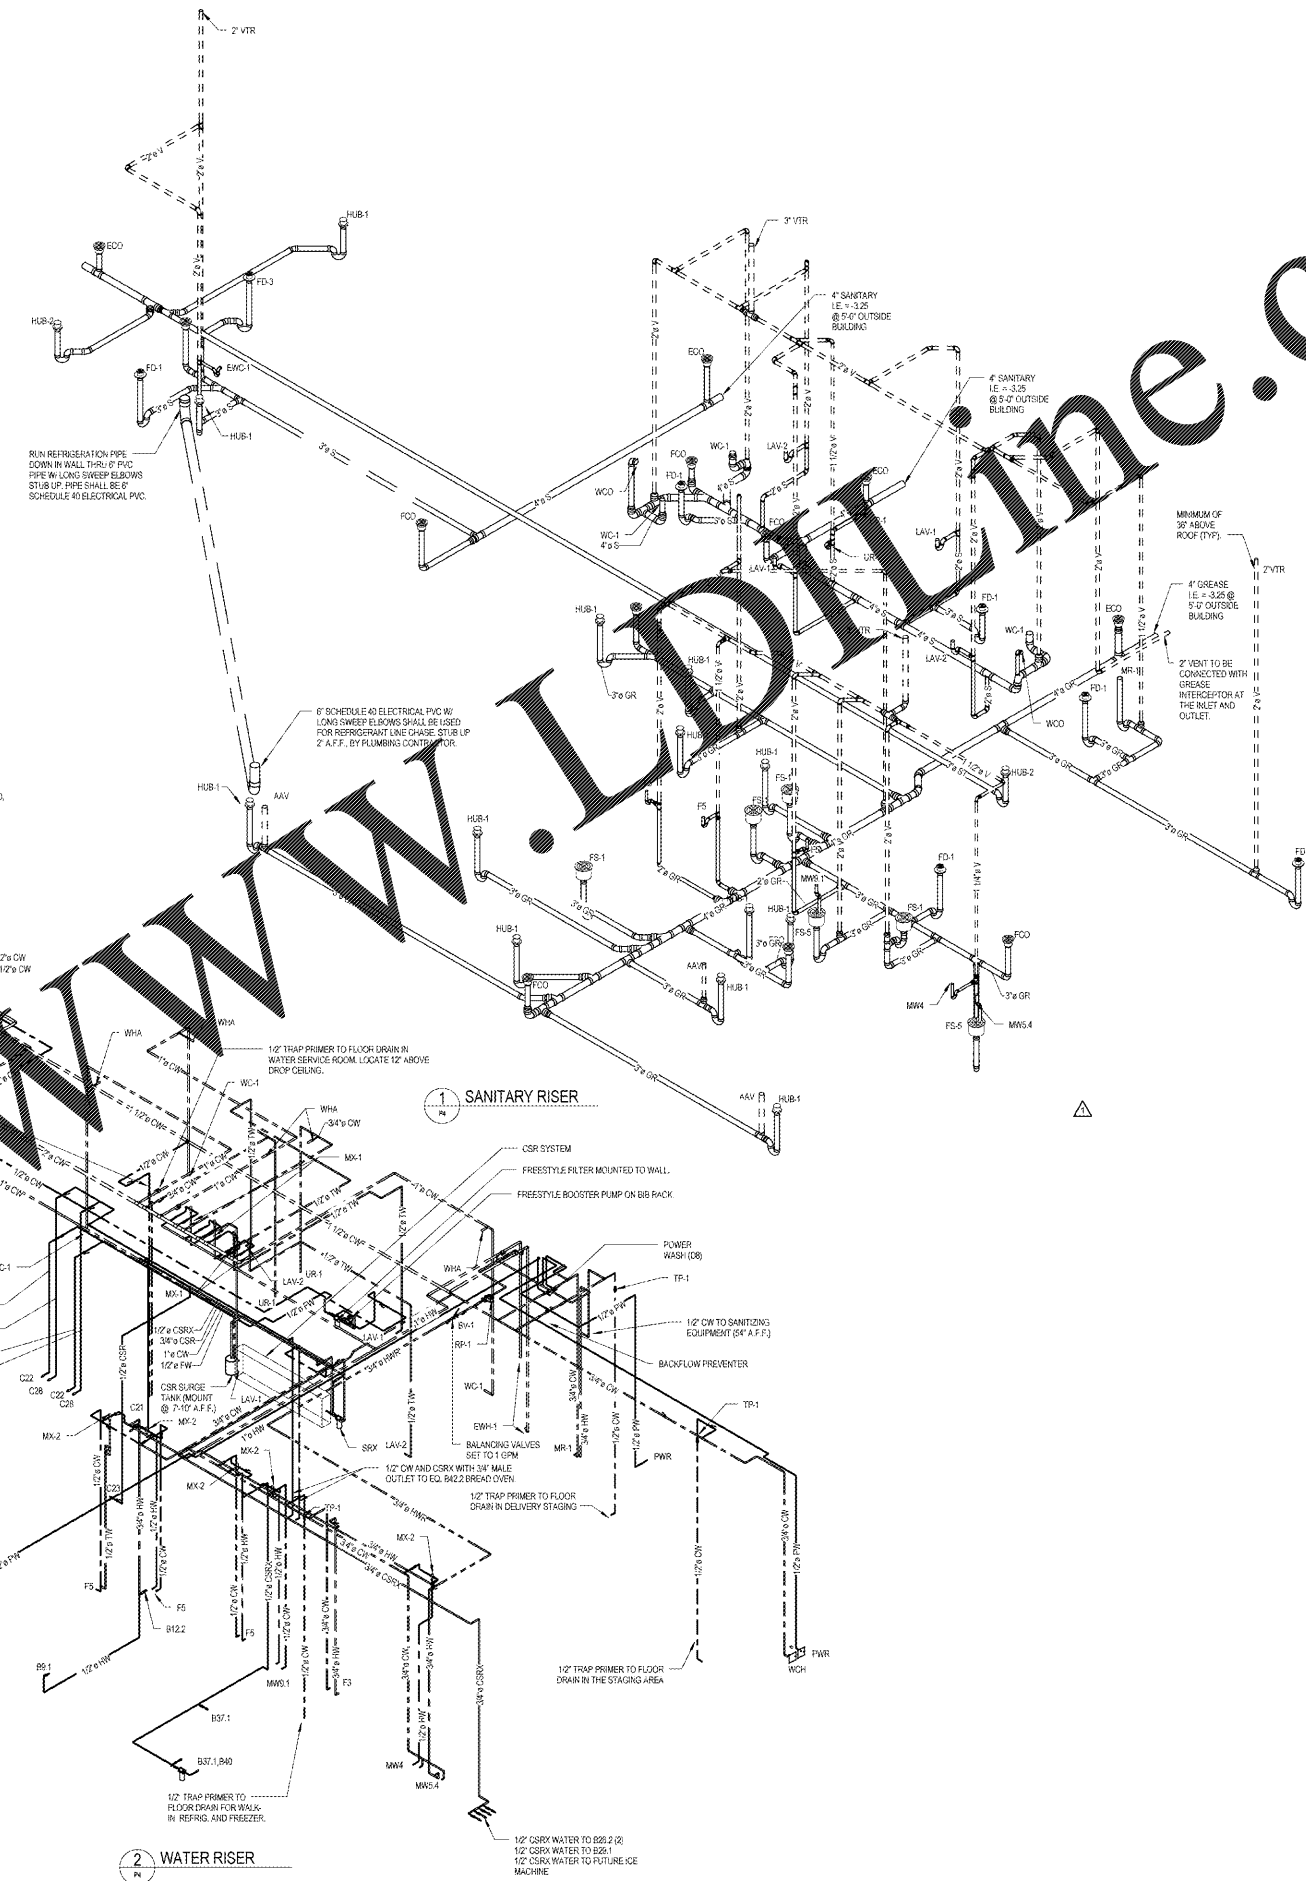

11/2" LAWN IRRIGATION SUPPLY. 1" RPZ BACKFLOW PREVENTER. 1" WATER SUB-METER WITH 1 GALLON DRY CONTACT PULSE FOR INTERLINK TO BAS SYSTEM. DO NOT INTERLINK IRRIGATION TO BAS IF RECLAIM WATER IS AVAILABLE.

INSTALL A 1" WATER SUB-METER WITH 10 GALLON DRY CONTACT PULSE FOR INTERLINK TO BAS SYSTEM.

3/4" COLD WATER LINE RUN DOWN IN WALL AND THEN UNDERGROUND. CONTINUE COLD WATER LINE UNDERGROUND TO WALL HYDRANT (MCP-1) LOCATED IN COLUMN IN GAS CANOPY AREA. REFER TO GAS CANOPY SHEET CA-1. USE BLACK POLY.

1 1/2" LAWN IRRIGATION SPRINKLER SUPPLY. VERIFY REQUIREMENTS WITH WAWA PROJECT MANAGER.

2" DOMESTIC WATER SERVICE METER LOCATED IN EXTERIOR PIT. SEE CIVIL PLAN FOR CONTINUATION.

12" TRAP PRIMER TO FLOOR DRAIN IN WATER SERVICE ROOM. LOCATE 12" ABOVE DROP CEILING.

12" TRAP PRIMER TO FLOOR DRAIN IN MEN'S AND WOMEN'S RESTROOMS.

12" TRAP PRIMER TO FLOOR DRAIN IN WATER SERVICE ROOM. LOCATE 12" ABOVE DROP CEILING.

12" TRAP PRIMER TO FLOOR DRAIN FOR WALK IN REFRIG. AND FREEZER.

12" CSRW WATER TO BSE.2 (R)

12" CSRW WATER TO BSA.1

12" CSRW WATER TO FUTURE ICE MACHINE

2 WATER RISER

1 SANITARY RISER

1925 Prospect Ave.
Orlando, FL 32814
P (407) 661-9100
F (407) 661-9101
www.rjg.com

Calaci & Ret...
Architects Engineers

CLIENT NAME
WAWA
280 WEST BALTIMORE PIKE
WAWA, PENNSYLVANIA 19063

PROJECT NAME
WAWA F85FB 2017.01 STORE #5294-CNY
28508 US 19 NORTH
CLEARWATER, FL 33761

SHEET TITLE
RISER DIAGRAMS

PROJECT NO.	DATE	DESCRIPTION	BY	CHECKED
2016020	01/13/2017	PERMIT		
	01/13/2017	PERMIT COMMENTS		
	01/13/2017	PRE-BID REVIEW SET		
	01/13/2017	BID SET		
	01/13/2017	ISSUES		
	01/13/2017	REVISIONS		