


Order Plans @

1 ELECTRICAL ROOF PLAN
B3 1/4" = 1'-0"

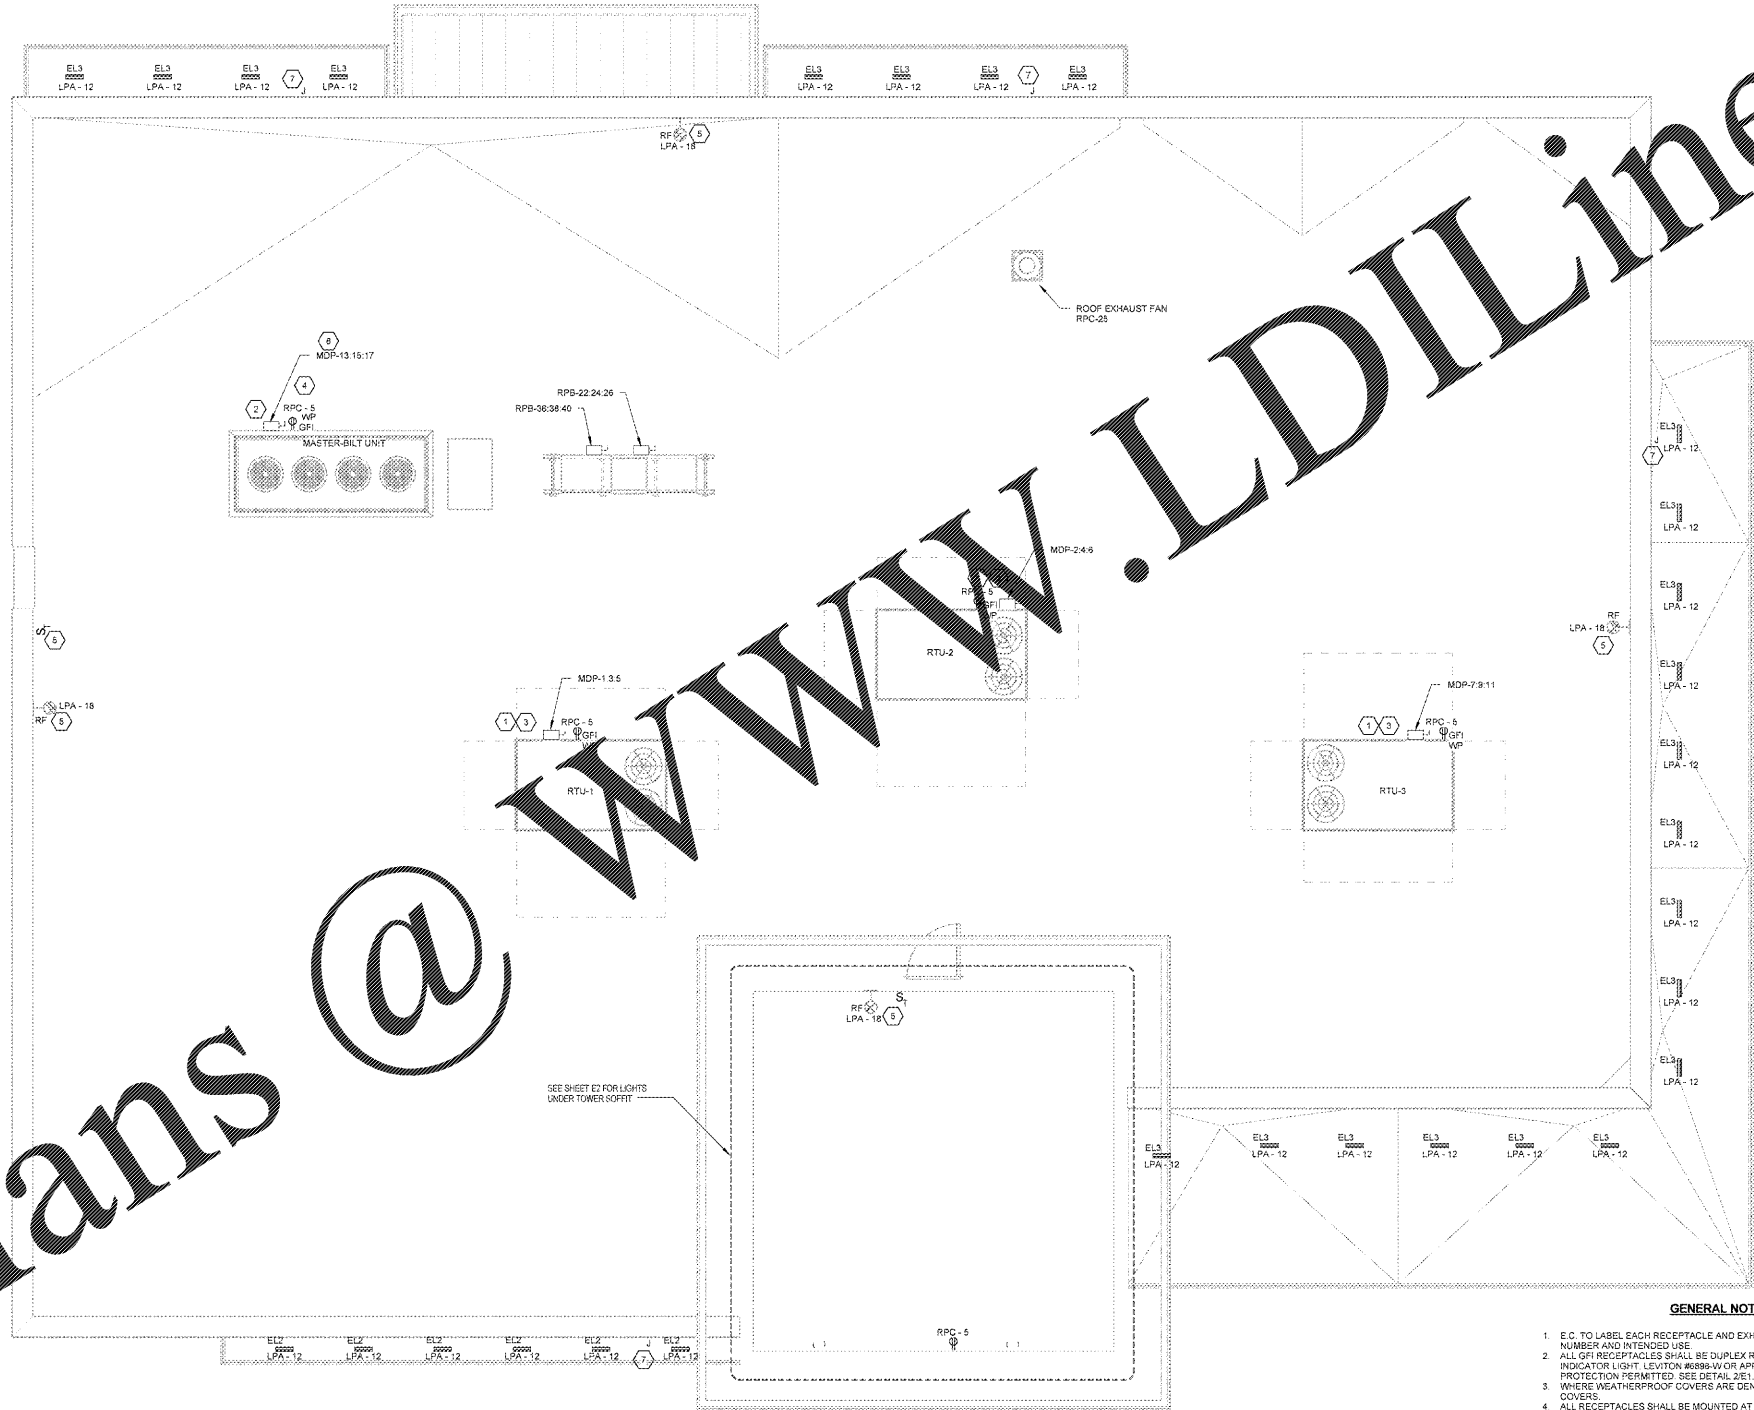

GENERAL NOTES:

- E.C. TO LABEL EACH RECEPTACLE AND EXHAUST FAN SWITCH WITH CIRCUIT NUMBER AND INTENDED USE.
- ALL GFI RECEPTACLES SHALL BE DUPLEX RECEPTACLES U.N.O. WITH LED INDICATOR LIGHT. LEVITON 8888-W OR APPROVED EQUAL. NO FEED THRU PROTECTION PERMITTED. SEE DETAIL D61.
- WHERE WEATHERPROOF COVERS ARE DENOTED, PROVIDE "WHILE-IN-USE" COVERS.
- ALL RECEPTACLES SHALL BE MOUNTED AT 18" AFF UNLESS OTHERWISE NOTED.
- E.C. TO COORDINATE INSTALLATION OF ALL ROOF LIGHTING FIXTURES WITH ROOFING CONTRACTOR TO PROVIDE A STRUCTURALLY SOUND AND WEATHERPROOF "LEAK FREE" INSTALLATION. RUN CONDUITS IN PARAPET WALL. NO EXPOSED CONDUITS OR EXTRA ROOF PENETRATIONS.

KEYNOTES:

- MAIN DISCONNECT PROVIDED WITH UNIT. POWERED CONVENIENCE OUTLET PROVIDED WITH UNIT.
- E.C. SHALL PROVIDE COMPLETE CONDUIT/CONDUCTOR SYSTEM FROM MDP TO UNIT VIA DISCONNECT.
- E.C. SHALL PROVIDE COMPLETE CONDUIT/CONDUCTOR SYSTEM FROM MDP TO SINGLE POINT CONNECTION AT UNIT.
- PROVIDE SUPPORT RACK ATTACHED TO UNIT AS REQUIRED TO MOUNT ELECTRICAL EQUIPMENT.
- E.C. SHALL PROVIDE (4) LIGHTING FIXTURES (BASIS OF DESIGN - VAPOLET VFN420UW-LP-PG). PROVIDE WEATHERPROOF SWITCH WITH TIMER NEAR ACCESS LADDER AND DOOR. FIXTURES AND SWITCHES TO BE SURFACE MOUNTED 8" BELOW TOP OF WALL OR 48" ABOVE FLOOR IN TOWER. PROVIDE COMPLETE CONDUIT/CONDUCTOR SYSTEM FOR FIXTURES AND SWITCHES BACK TO POWER PANEL IN ELECTRICAL ROOM.
- NOT USED.
- WALL MOUNTED WEATHERPROOF J-BOX TO SERVE 'E12' AND 'E13' LIGHTS ON TOP OF CANOPY. ELECTRICAL POWER TO MASTER-BILT UNIT TO RUN THROUGH PROVIDED GOOSENECK NEXT TO UNIT. DO NOT CREATE SEPARATE ROOF PENETRATION.

WWW.LDILine.com

1925 Prospect Ave.
Orlando, FL 32814
P (407) 661-9100
F (407) 661-9101
www.rj.com

Cabalci & Ret
Architects Engineers

CLIENT NAME
WAWA
260 WEST BALTIMORE PIKE
WAWA, PENNSYLVANIA 19063

PROJECT NAME
WAWA F85FB 2017.01 STORE #5294-CNY
26508 US 19 NORTH
CLEARWATER, FL 33761

SHEET TITLE
ROOF LIGHTING AND POWER PLAN

| Revision Schedule | |
|-------------------|-------------|
| No. | Description |
| 1 | 01/17/2017 |
| 2 | 07/28/2017 |
| 3 | 09/04/2017 |

| | |
|-------------|------------|
| PROJECT NO. | 2016022 |
| DATE | 01/01/2017 |
| DRAWN BY | BA |
| CHECKED | Cher |