

Order Plans @ WWW.DILLINE.COM


LEGEND			
	HEAT DETECTOR - RATE OF RISE		FIRE ALARM CONTROL PANEL
	HEAT DETECTOR - FIXED TEMP.		FIRE ALARM SYSTEM ANNUNCIATOR
	PHOTOELECTRIC SMOKE DETECTOR		NOTIFICATION APPLIANCE CERT.
	FIRE ALARM HORN/STROBE ANNUN.		RTU MOUNTED SMOKE DETECTOR
	FIRE ALARM STROBE		SPRINKLER FLOW
	FIRE ALARM PULL STATION		SPRINKLER TAMPER
			END OF LINE

GENERAL NOTES:

- FIRE ALARM DEVICES, OTHERS, AND PROVIDING CONDUIT AND WIRING FOR ALL PULL STATIONS AND STROBES SHALL BE INSTALLED BY THE CONTRACTOR.
- FIRE ALARM CONTROL PANEL SHALL BE MOUNTED 96" AFF. UNLESS OTHERWISE NOTED. ALL PULL STATIONS AT 48" AFF. UNLESS OTHERWISE NOTED. ALL PULL STATIONS AT 48" AFF. UNLESS OTHERWISE NOTED.
- ALL FIRE ALARM DEVICES SHALL BE WIRED WITH 18 GAUGE/2 WIRE RED FIRE WIRE.
- SPRINKLER TAMPER AND KEY SWITCHES ONLY USED IF REQUIRED BY THE ELECTRICAL CONDUIT PLAN FOR THE PROJECT. TAMPER AND FLOW SWITCHES AT BACKFLOW PREVENTER REQUIRED BY AHJ.
- ALL FIRE ALARM HORN/STROBES SHALL BE WIRED WITH 16 GAUGE 2 PAIR RED FIRE WIRE WHEN NOT USING SILENT KEY SWITCH 5495 POWER SUPPLY.
- CONNECTION BETWEEN SECURITY CAMERA SYSTEM AND FIRE ALARM SYSTEM PANEL SHALL BE A 22 GAUGE 2 PAIR DRAWING IS FOR INFORMATION PURPOSES ONLY. FINAL FIRE ALARM PLAN TO BE PROVIDED BY A LICENSED CONTRACTOR.

KEYNOTES:

- FIRE ALARM CONTROL PANEL TO BE MOUNTED 96" AFF. PROVIDE 1" CONDUIT FROM FIRE ALARM CONTROL PANEL TO SECURITY PANEL LOCATED IN THIS ELECTRICAL ROOM.
- FIRE ALARM PULL STATION SHALL BE NOT LESS THAN 5'-6" (1.3M) AND NOT MORE THAN 4'-9" (1.5M) AFF. PROVIDE PROTECTIVE COVER TO PREVENT ACCIDENTAL INITIATION.
- FOR EXACT LOCATION OF ALL DEVICES IN MANAGER'S OFFICE. SEE ARCHITECTURAL ELEVATIONS SHEET.
- FACTORY INSTALLED SMOKE DETECTOR IN MAIN SUPPLY AND RETURN OF EACH ROOF TOP UNIT.

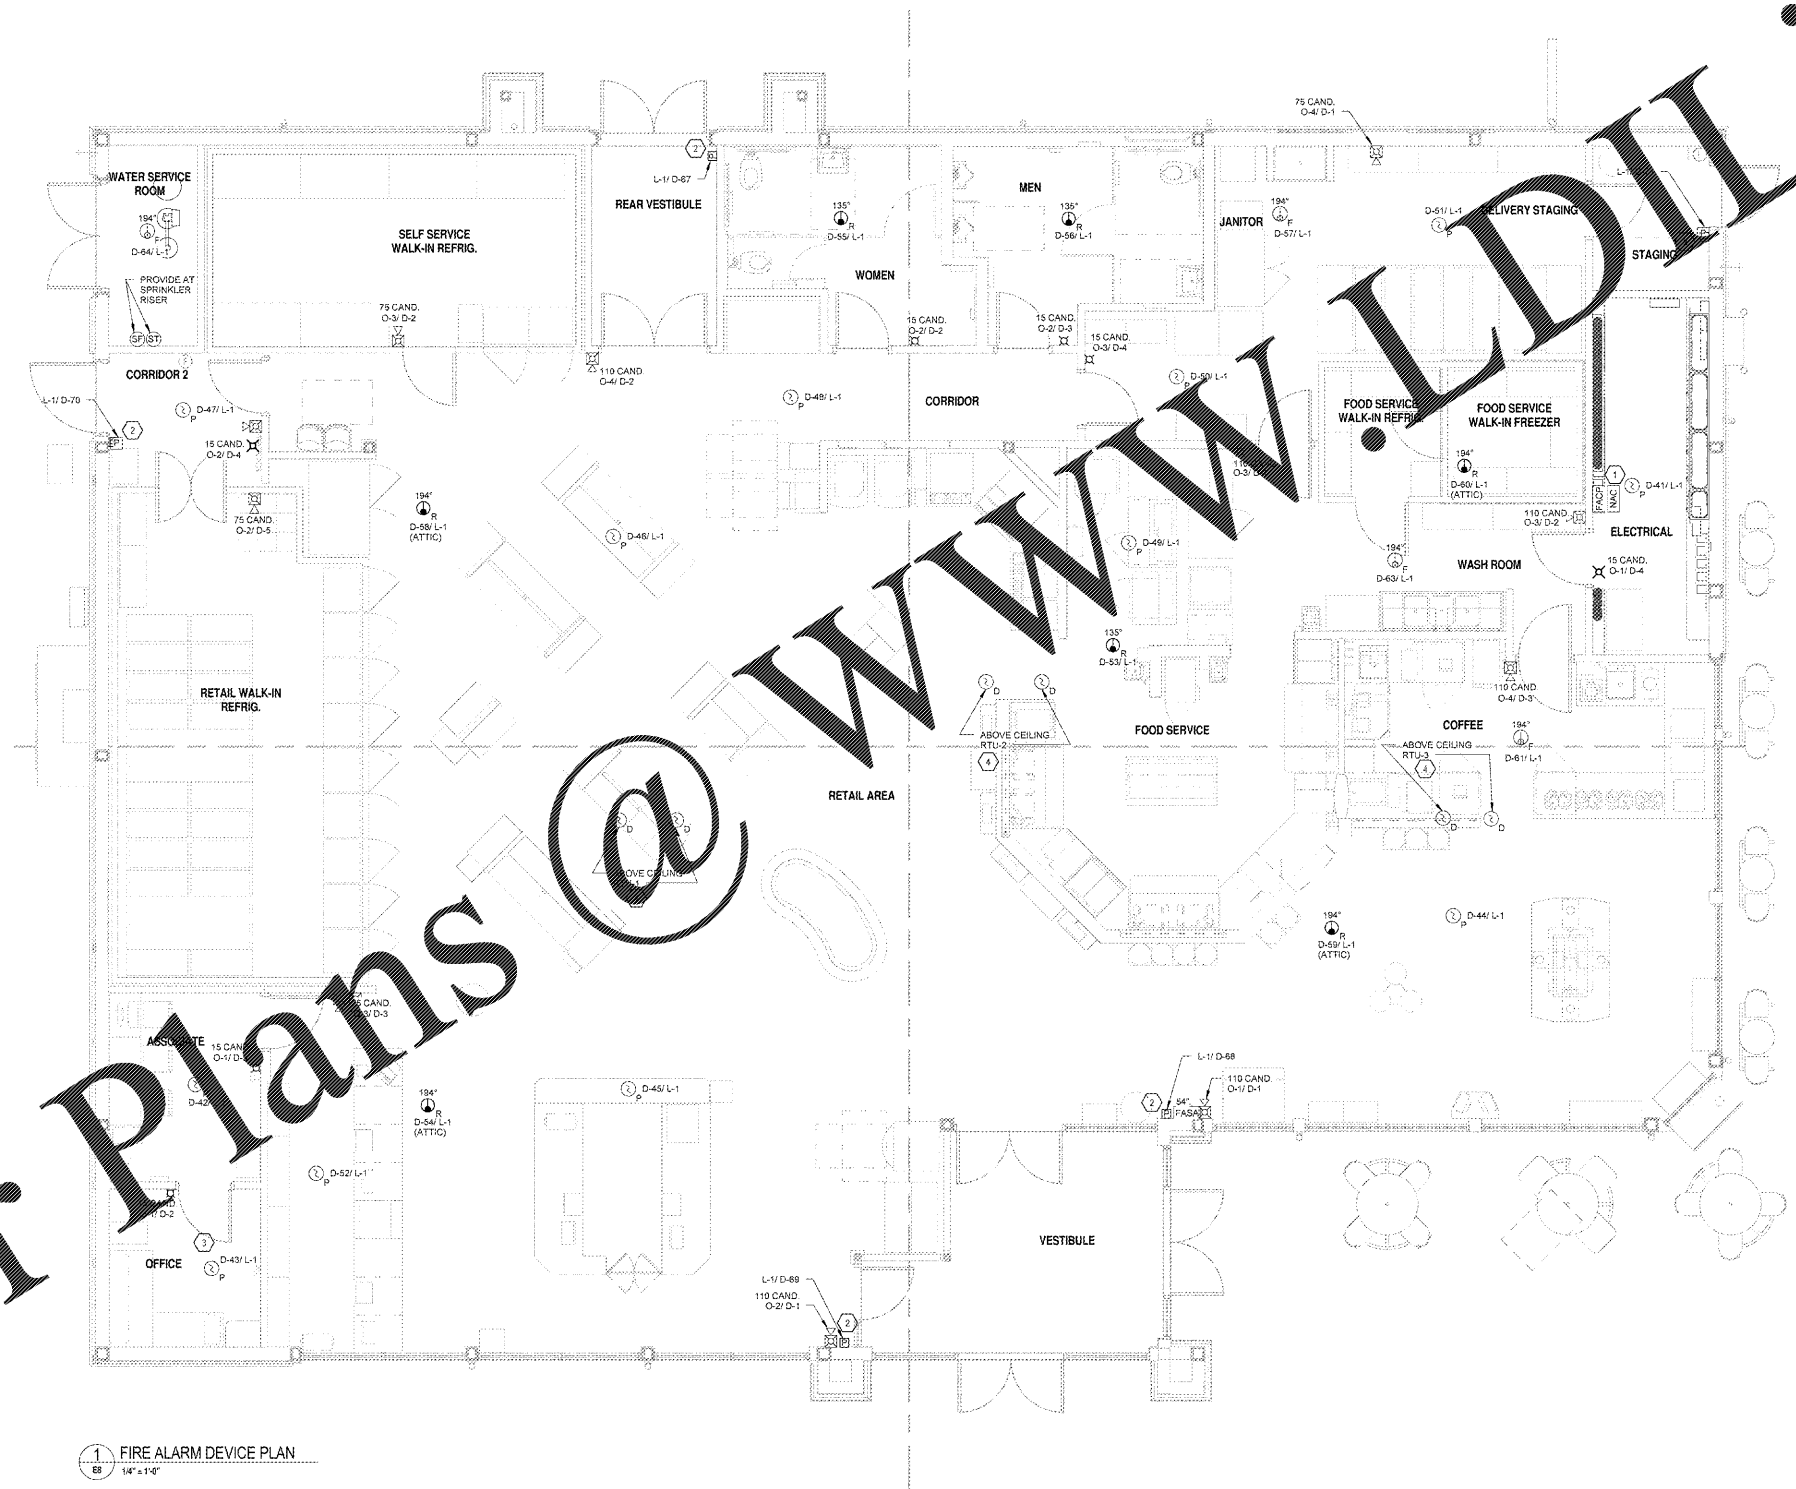

1 FIRE ALARM DEVICE PLAN
1/4" = 1'-0"

1925 Prospect Ave.
Orlando, FL 32814
P (407) 661-9100
F (407) 661-9101
www.dil.com
Cubaci & Ret...
Architects Engineers

CLIENT NAME
WAWA
280 WEST BALTIMORE PIKE
WAWA, PENNSYLVANIA 19083

PROJECT NAME
WAWA F85FB 2017.01 STORE #5294-CNY
28508 US 19 NORTH
CLEARWATER, FL 33761

Revision Schedule	
No.	Description
1	PRELIMINARY SET 01/17/2017
2	FIELD REVISED SET 07/28/2017
3	BID SET 09/04/2017

PROJECT NO. 2016020
DATE 01/02/2017
DRAWN BY
CHECKED BY
E8