
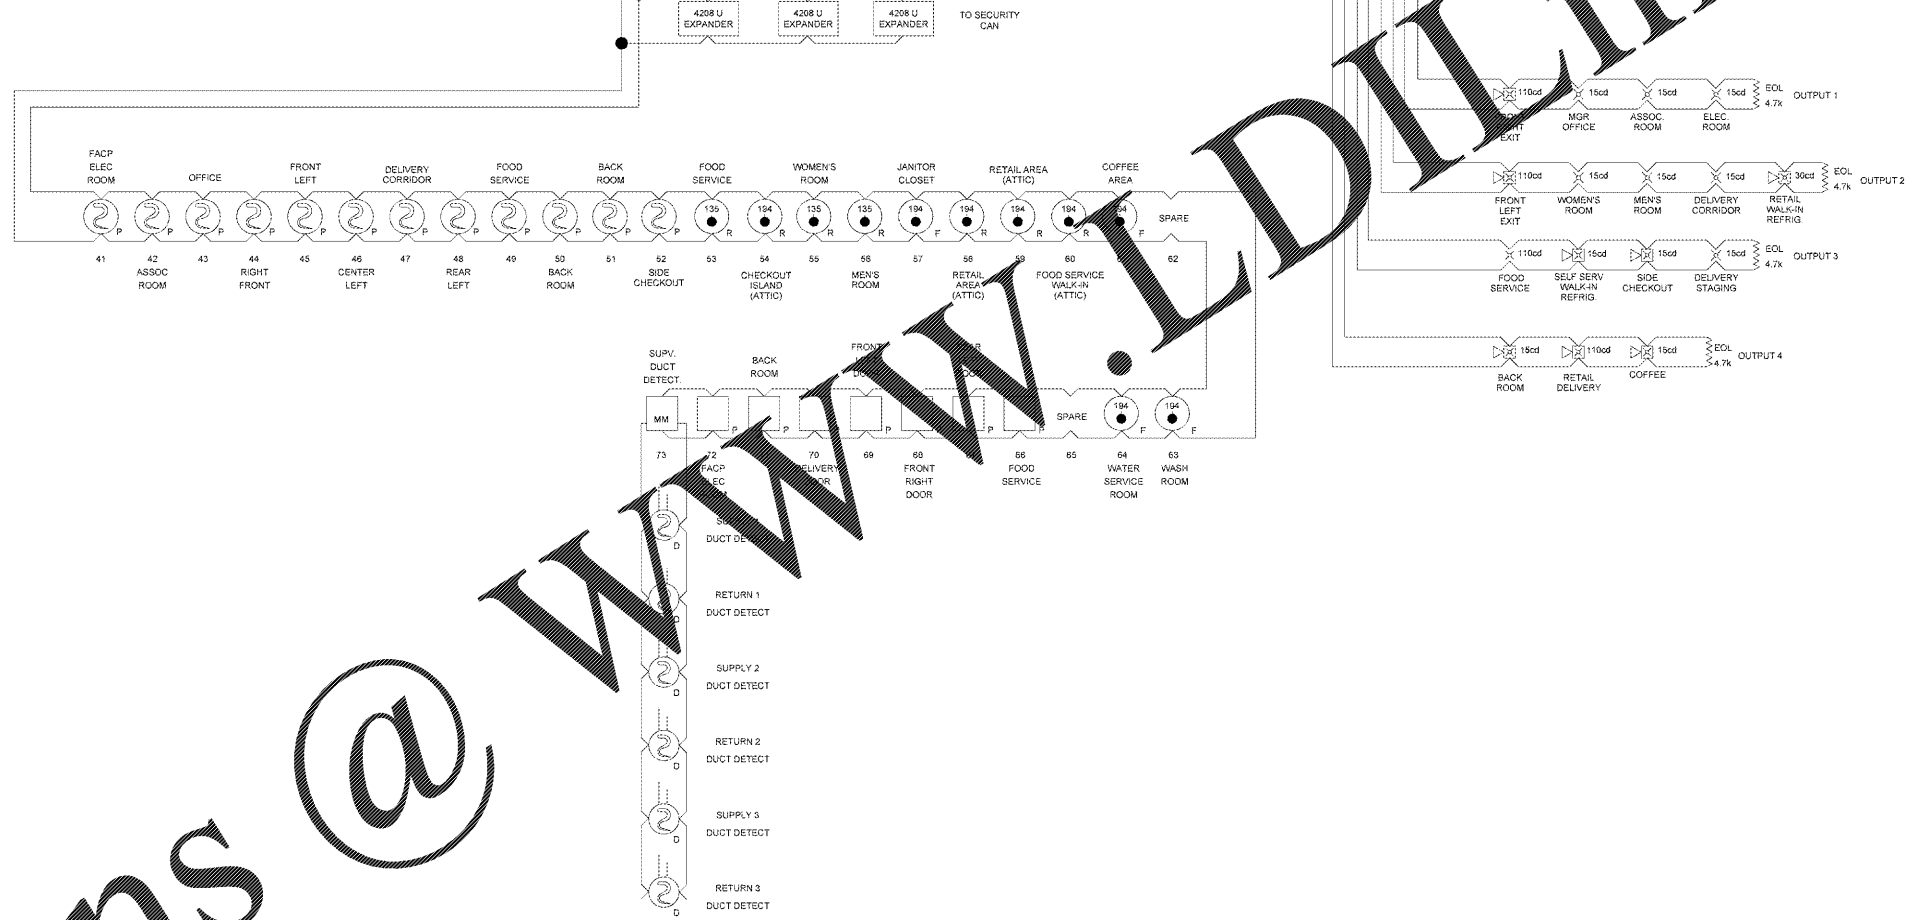
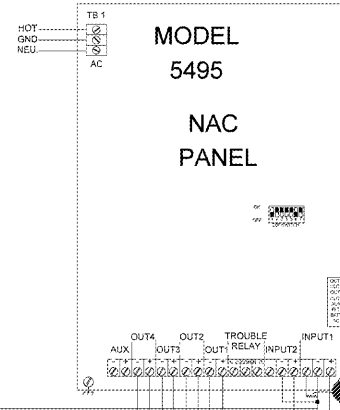


Order Plans @

WWW.DIline.com

VISTA-128FB  
FIRE ALARM PANEL

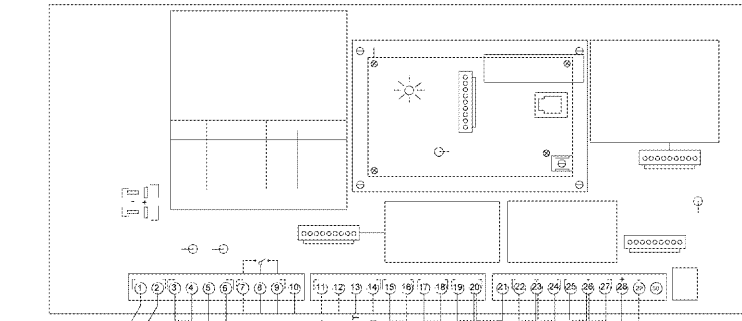

1 FIRE ALARM RISER DIAGRAM  
NOT SCALE

1925 Prospect Ave  
Orlando, FL 32814  
P (407) 661-9100  
F (407) 661-9101  
www.rjefire.com

**WAWA**  
260 WEST BALTIMORE PIKE  
WAWA, PENNSYLVANIA 19063

CLIENT NAME  
**WAWA F85FB 2017.01 STORE #5294-CNY**  
26508 US 19 NORTH  
CLEARWATER, FL 33761

PROJECT NAME  
**WAWA F85FB 2017.01 STORE #5294-CNY**  
26508 US 19 NORTH  
CLEARWATER, FL 33761

SHEET TITLE  
**FIRE ALARM SYSTEM RISER DIAGRAM**

No.	Description	Date
1	PRELIMINARY	01/17/2017
2	FIELD REVISION SET	07/26/2017
3	BID SET	09/04/2017

PROJECT NO.	DATE	DESIGNED BY	CHECKED BY
2016202	01/01/2017	BJM	CA

19