


Order Plans @

WWW.LDILINE.COM

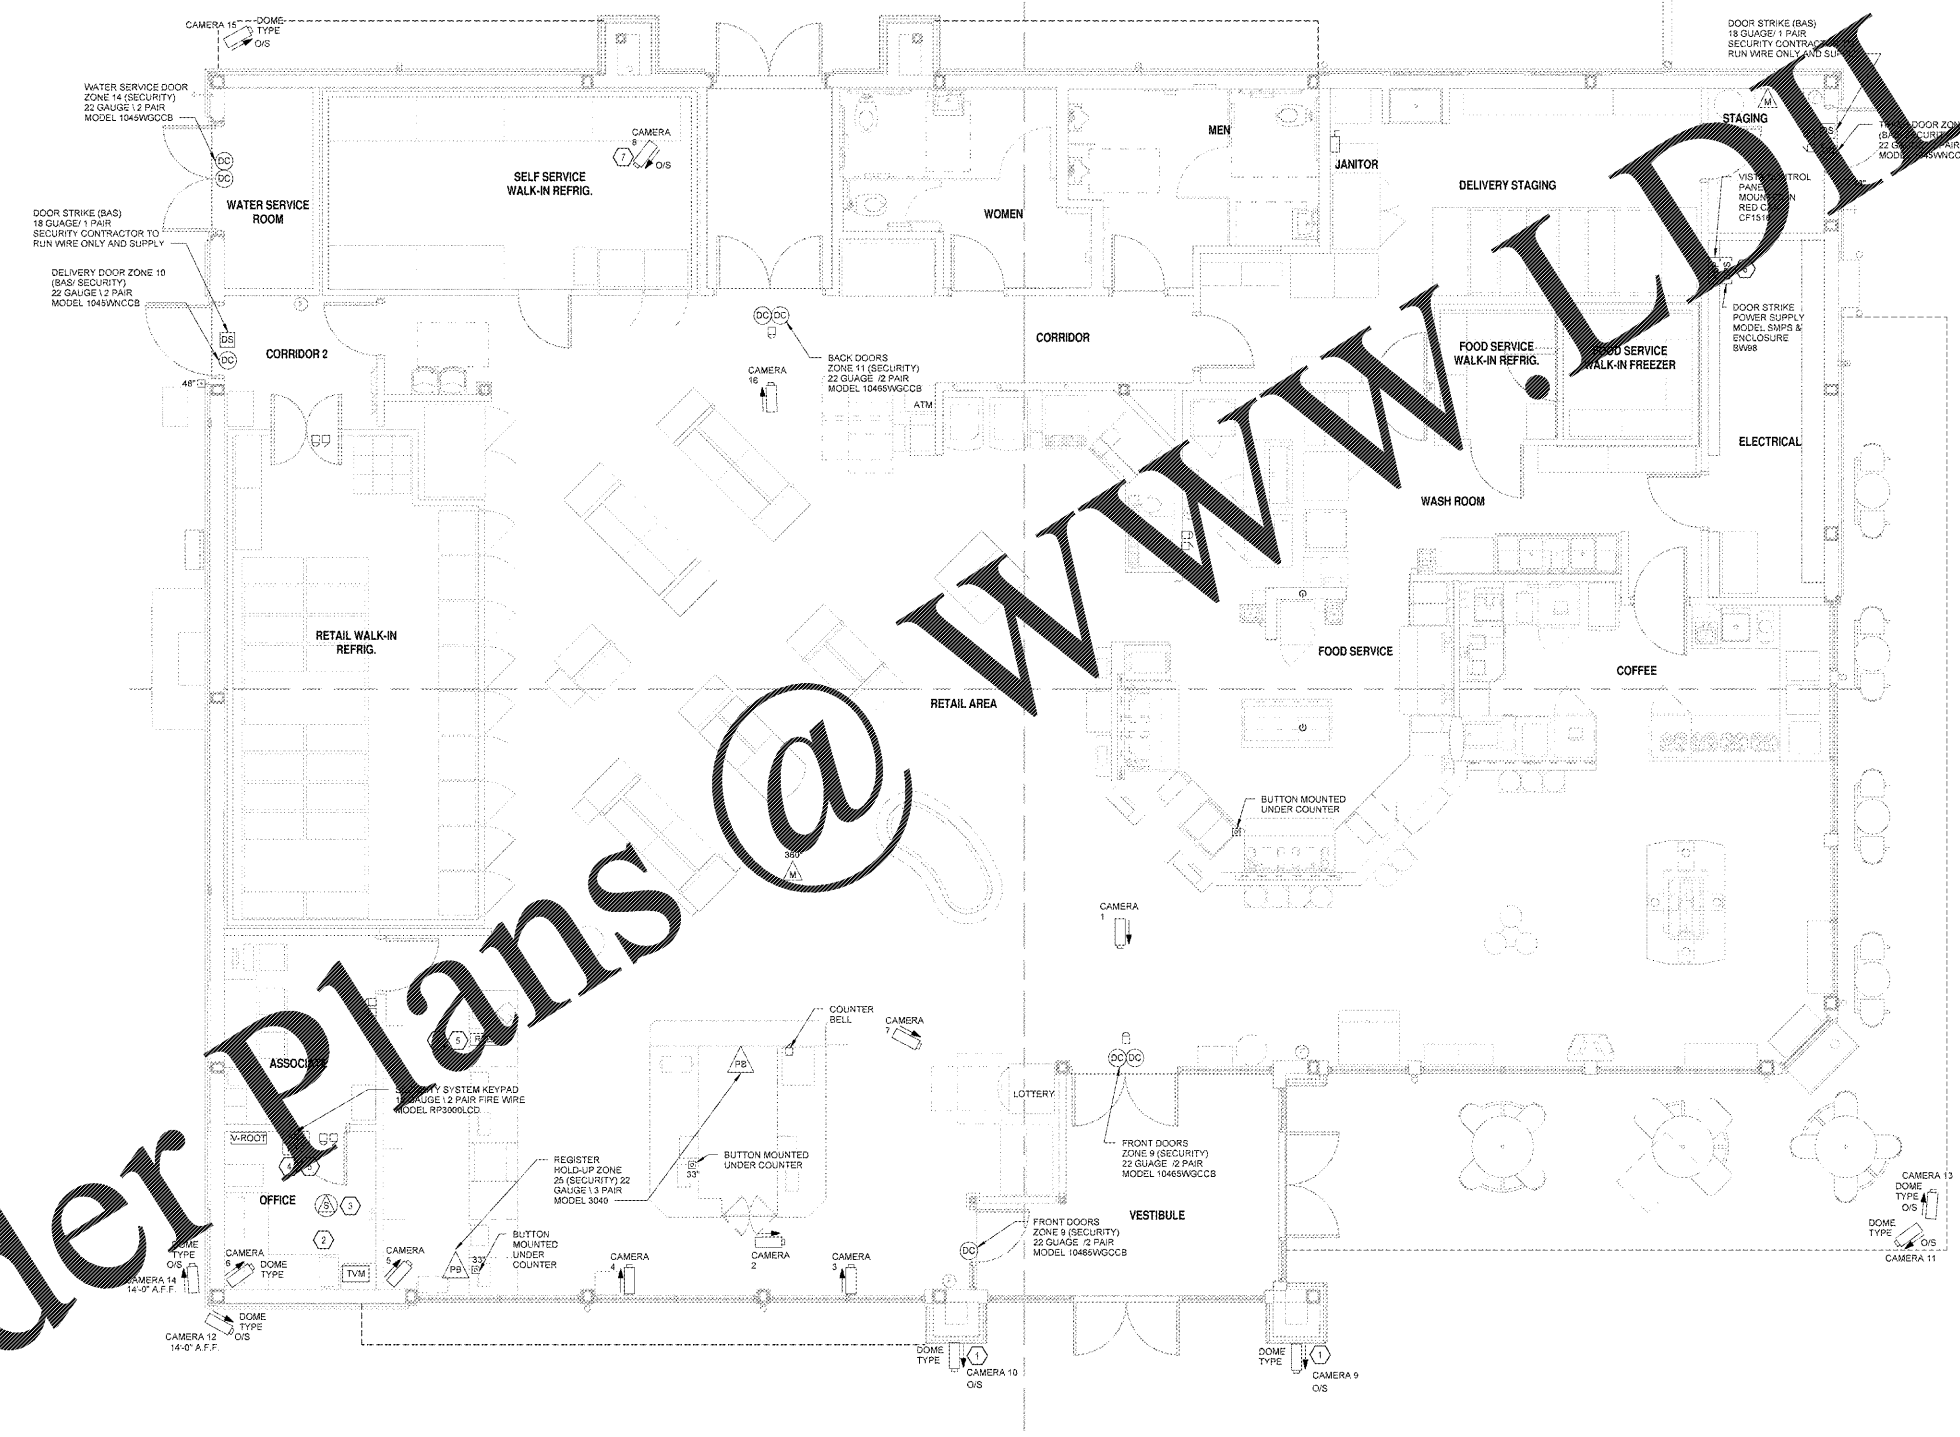

**LEGEND**

[Symbol]	PUSH BUTTON BUZZER (EXTERIOR)
[Symbol]	PUSH BUTTON BELL (INTERIOR)
[Symbol]	BUZZER (EXTERIOR) / BELL (INTERIOR)
[Symbol]	CHIME
[Symbol]	SECURITY SYSTEM PANEL
[Symbol]	SECURITY SYSTEM KEYPAD
[Symbol]	PETROLEUM ALARM
[Symbol]	DOOR CONTACT
[Symbol]	MOTION DETECTOR
[Symbol]	PANIC BUTTON
[Symbol]	PANIC BUTTON WITH LEAD
[Symbol]	SECURITY SPEAKER
[Symbol]	DOOR STRIKE POWER SUPPLY
[Symbol]	DOOR STRIKE
[Symbol]	REQUEST TO ENTER
[Symbol]	CAMERA (SHOWING DIRECTION)
[Symbol]	CAMERA (OUTSIDE RATED FOR TEMPERATURE AND WEATHER)
[Symbol]	MONITOR FOR CAMERAS (CCTV)

- GENERAL NOTES:**
- ELECTRICAL CONTRACTOR TO PROVIDE CONDUIT, OUTLETRACK BOX AND PULL STRING TO ABOVE ACCESSIBLE CEILING FOR ALL DEVICES. PANELS AND OTHER ELECTRICAL EQUIPMENT LOCATED IN WALL OR HARD CEILING SPACES.
  - ALL SECURITY SYSTEM PANELS, DEVICES, CAMERAS, SPEAKERS, AND ASSOCIATED WIRING SUPPLIED AND INSTALLED BY WAWA SECURITY CONTRACTOR.
  - CONNECTION BETWEEN SECURITY CAMERA SYSTEM AND FIRE ALARM SYSTEM PANEL SHALL BE A 2 GAUGE/2 PAIR ELECTRICAL CONTRACTOR SHALL PROVIDE (1)18-2 AND (1)18-2 COAX CABLE TO EACH SECURITY CAMERA FROM CAMERA POWER SUPPLY. PROVIDE 2 WHITE 18-2 CONDUCTORS FOR POWER SUPPLY.
  - PHONE LINES PROVIDED BY OTHERS. E.C. TO PROVIDE CONDUIT BOX AND PULL STRING TO ACCESSIBLE ABOVE CEILING SPACE.
  - EXTERIOR WALL MOUNTED CAMERAS (NOT UNDER CANOPIES) TO BE MOUNTED AT HEIGHT OF 14 FEET.
- KEYNOTES:**
- SECURITY CONTRACTOR TO MOUNT OUTSIDE CAMERAS AND 10 VIEWING GAS PUMPS FOR EXHAUSTION OF DEVICES IN MAIN OFFICE SEE SHEET 01-100.
  - SECURITY CONTRACTOR SHALL MOUNT SECURITY PANEL ABOVE OFFICE CEILING. SECURED TO WALL OR BEHIND STUD. 18 GAUGE/2 PAIR.
  - TRASH DOOR SECURITY TIMER RELEASE BUTTON MOUNTED IN OFFICE SECOND SWITCH MOUNTED TO THE RIGHT OF OFFICE CLOSET IN FIRST CLOSET. (NO TIME DELAY NEEDED FOR BAS SYSTEM).
  - TRASH DOOR SECURITY TIMER RELEASE BUTTON MOUNTED IN OFFICE BELOW SERVICE KEYPAD. SECOND SWITCH MOUNTED TO THE LEFT OF CORE OPENING IN FIRST CLOSET.
  - MOUNT SECURITY PANELS 9" FROM FLOOR. FIELD LOCATION WITH WAWA PROJECT MANAGER. PROVIDE SELF SERV WALK-IN CAMERA. PROVIDE O/S TYPE RATED FOR COOLER TEMPERATURE.

1 SECURITY SYSTEM DEVICE PLAN  
E10 1/4" = 1'-0"

1925 Prospect Ave.  
Orlando, FL 32814  
P (407) 661-9100  
F (407) 661-9101  
www.ldilinc.com  
Cabalaci & Ret...  
Architects Engineers

CLIENT NAME  
**WAWA**  
260 WEST BALTIMORE PIKE  
WAWA, PENNSYLVANIA 19063

PROJECT NAME  
**WAWA F85FB 2017.01 STORE #5294-CNY**  
26508 US 19 NORTH  
CLEARWATER, FL 33761

REVISIONS

No.	Description	Date
1	PRELIMINARY SET	01/17/2017
2	REVISED SET	07/28/2017
3	REVISED SET	09/04/2017

PROJECT NO.  
2016020

DATE  
01/17/2017

DRAWN BY  
BA

CHECKED BY  
C