


Order Plans @

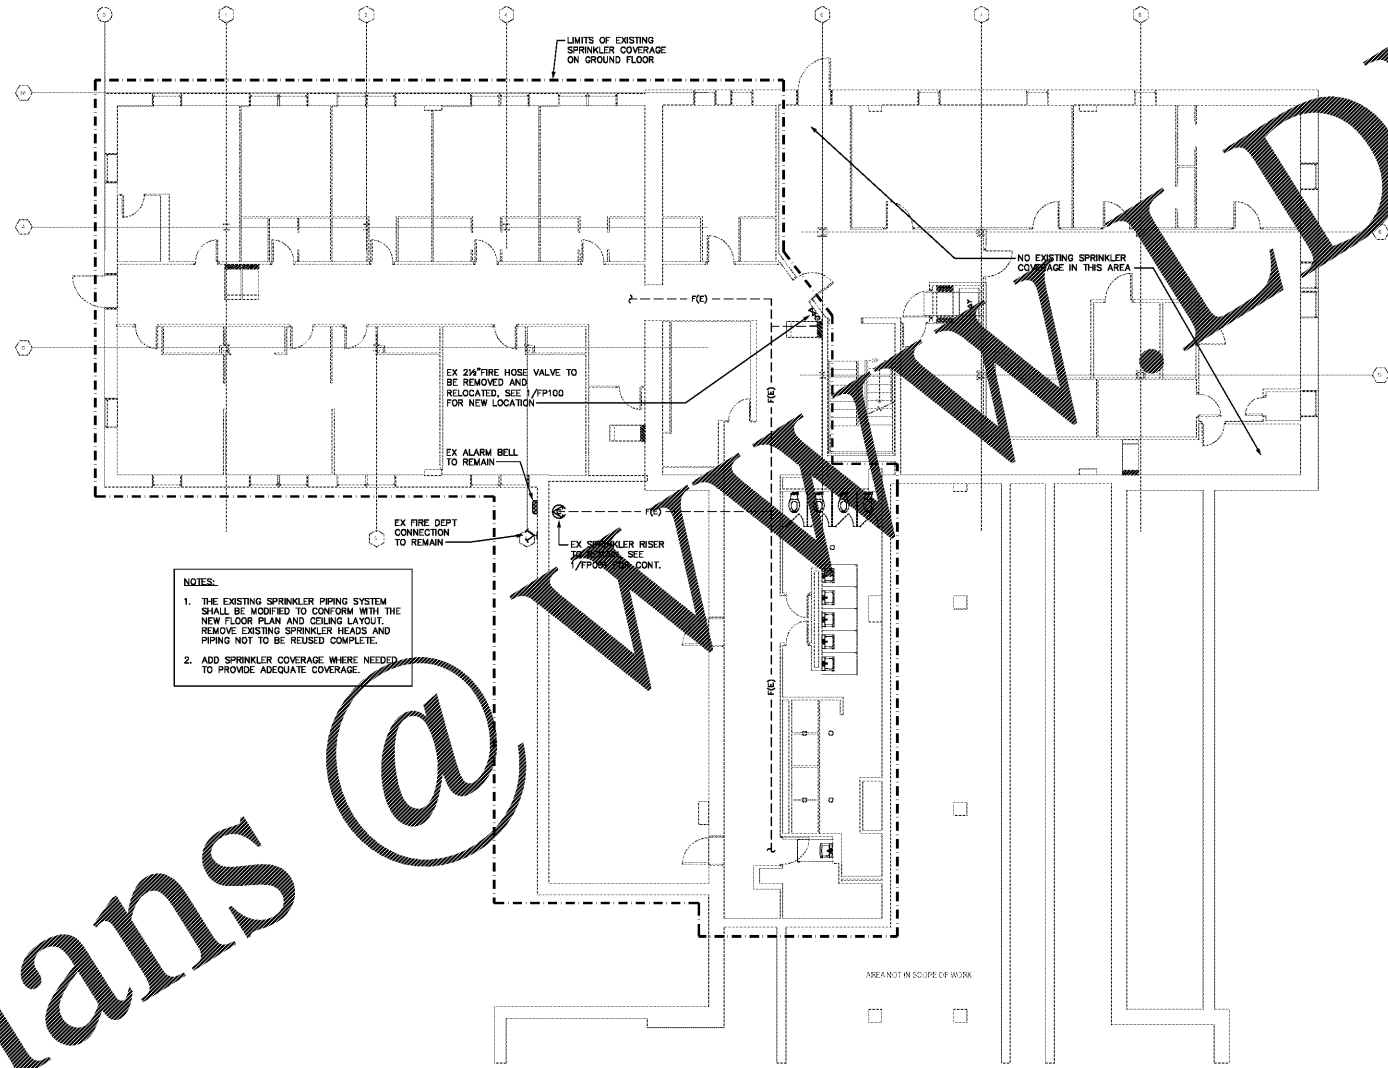


- NOTES:**
1. THE EXISTING SPRINKLER PIPING SYSTEM SHALL BE MODIFIED TO CONFORM WITH THE NEW FLOOR PLAN AND CEILING LAYOUT. REMOVE EXISTING SPRINKLER HEADS AND PIPING NOT TO BE REUSED COMPLETE.
  2. ADD SPRINKLER COVERAGE WHERE NEEDED TO PROVIDE ADEQUATE COVERAGE.

**1 GROUND FLOOR PLAN - FIRE PROTECTION - DEMOLITION**  
1/8" = 1'-0"

RATED WALL LEGEND	
	01 000 1 000 1 000 1 000 1 HOUR FIRE BARRIER
	02 000 15 000 15 000 15 000 2 HOUR FIRE BARRIER

REFER TO ARCHITECTURAL DRAWINGS FOR COMPLETE WALL CONSTRUCTION AND RATING INFORMATION.

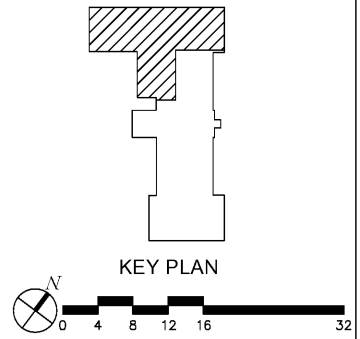

WESTERN CAROLINA UNIVERSITY  
**MOORE HALL GROUND FLOOR RENOVATION**  
CULLOWHEE, NC

SHEET NO.	DATE	DESCRIPTION	BY
1	03/07/18	ISSUED FOR BID	

PRINCIPAL IN CHARGE: LR  
PROJECT ARCHITECT: AFR  
DRAWN BY:  
SHEET TITLE:  
**GROUND FLOOR PLAN - FIRE PROTECTION DEMOLITION**

AGENCY REVIEW ID: 17-1742-01A  
**FPD100**

