


**WESTPOINT 2
DURHAM, NC**

REVISIONS

▲	2016-08-17 UTILITY COORD.
▲	2017-08-08 PLUMBING COMMENTS

PROJECT: 1342
DATE: 11/11/16
DRAWN BY: GCF
CHECKED BY: GCF

**GROUND FLOOR
PLUMBING PLAN**

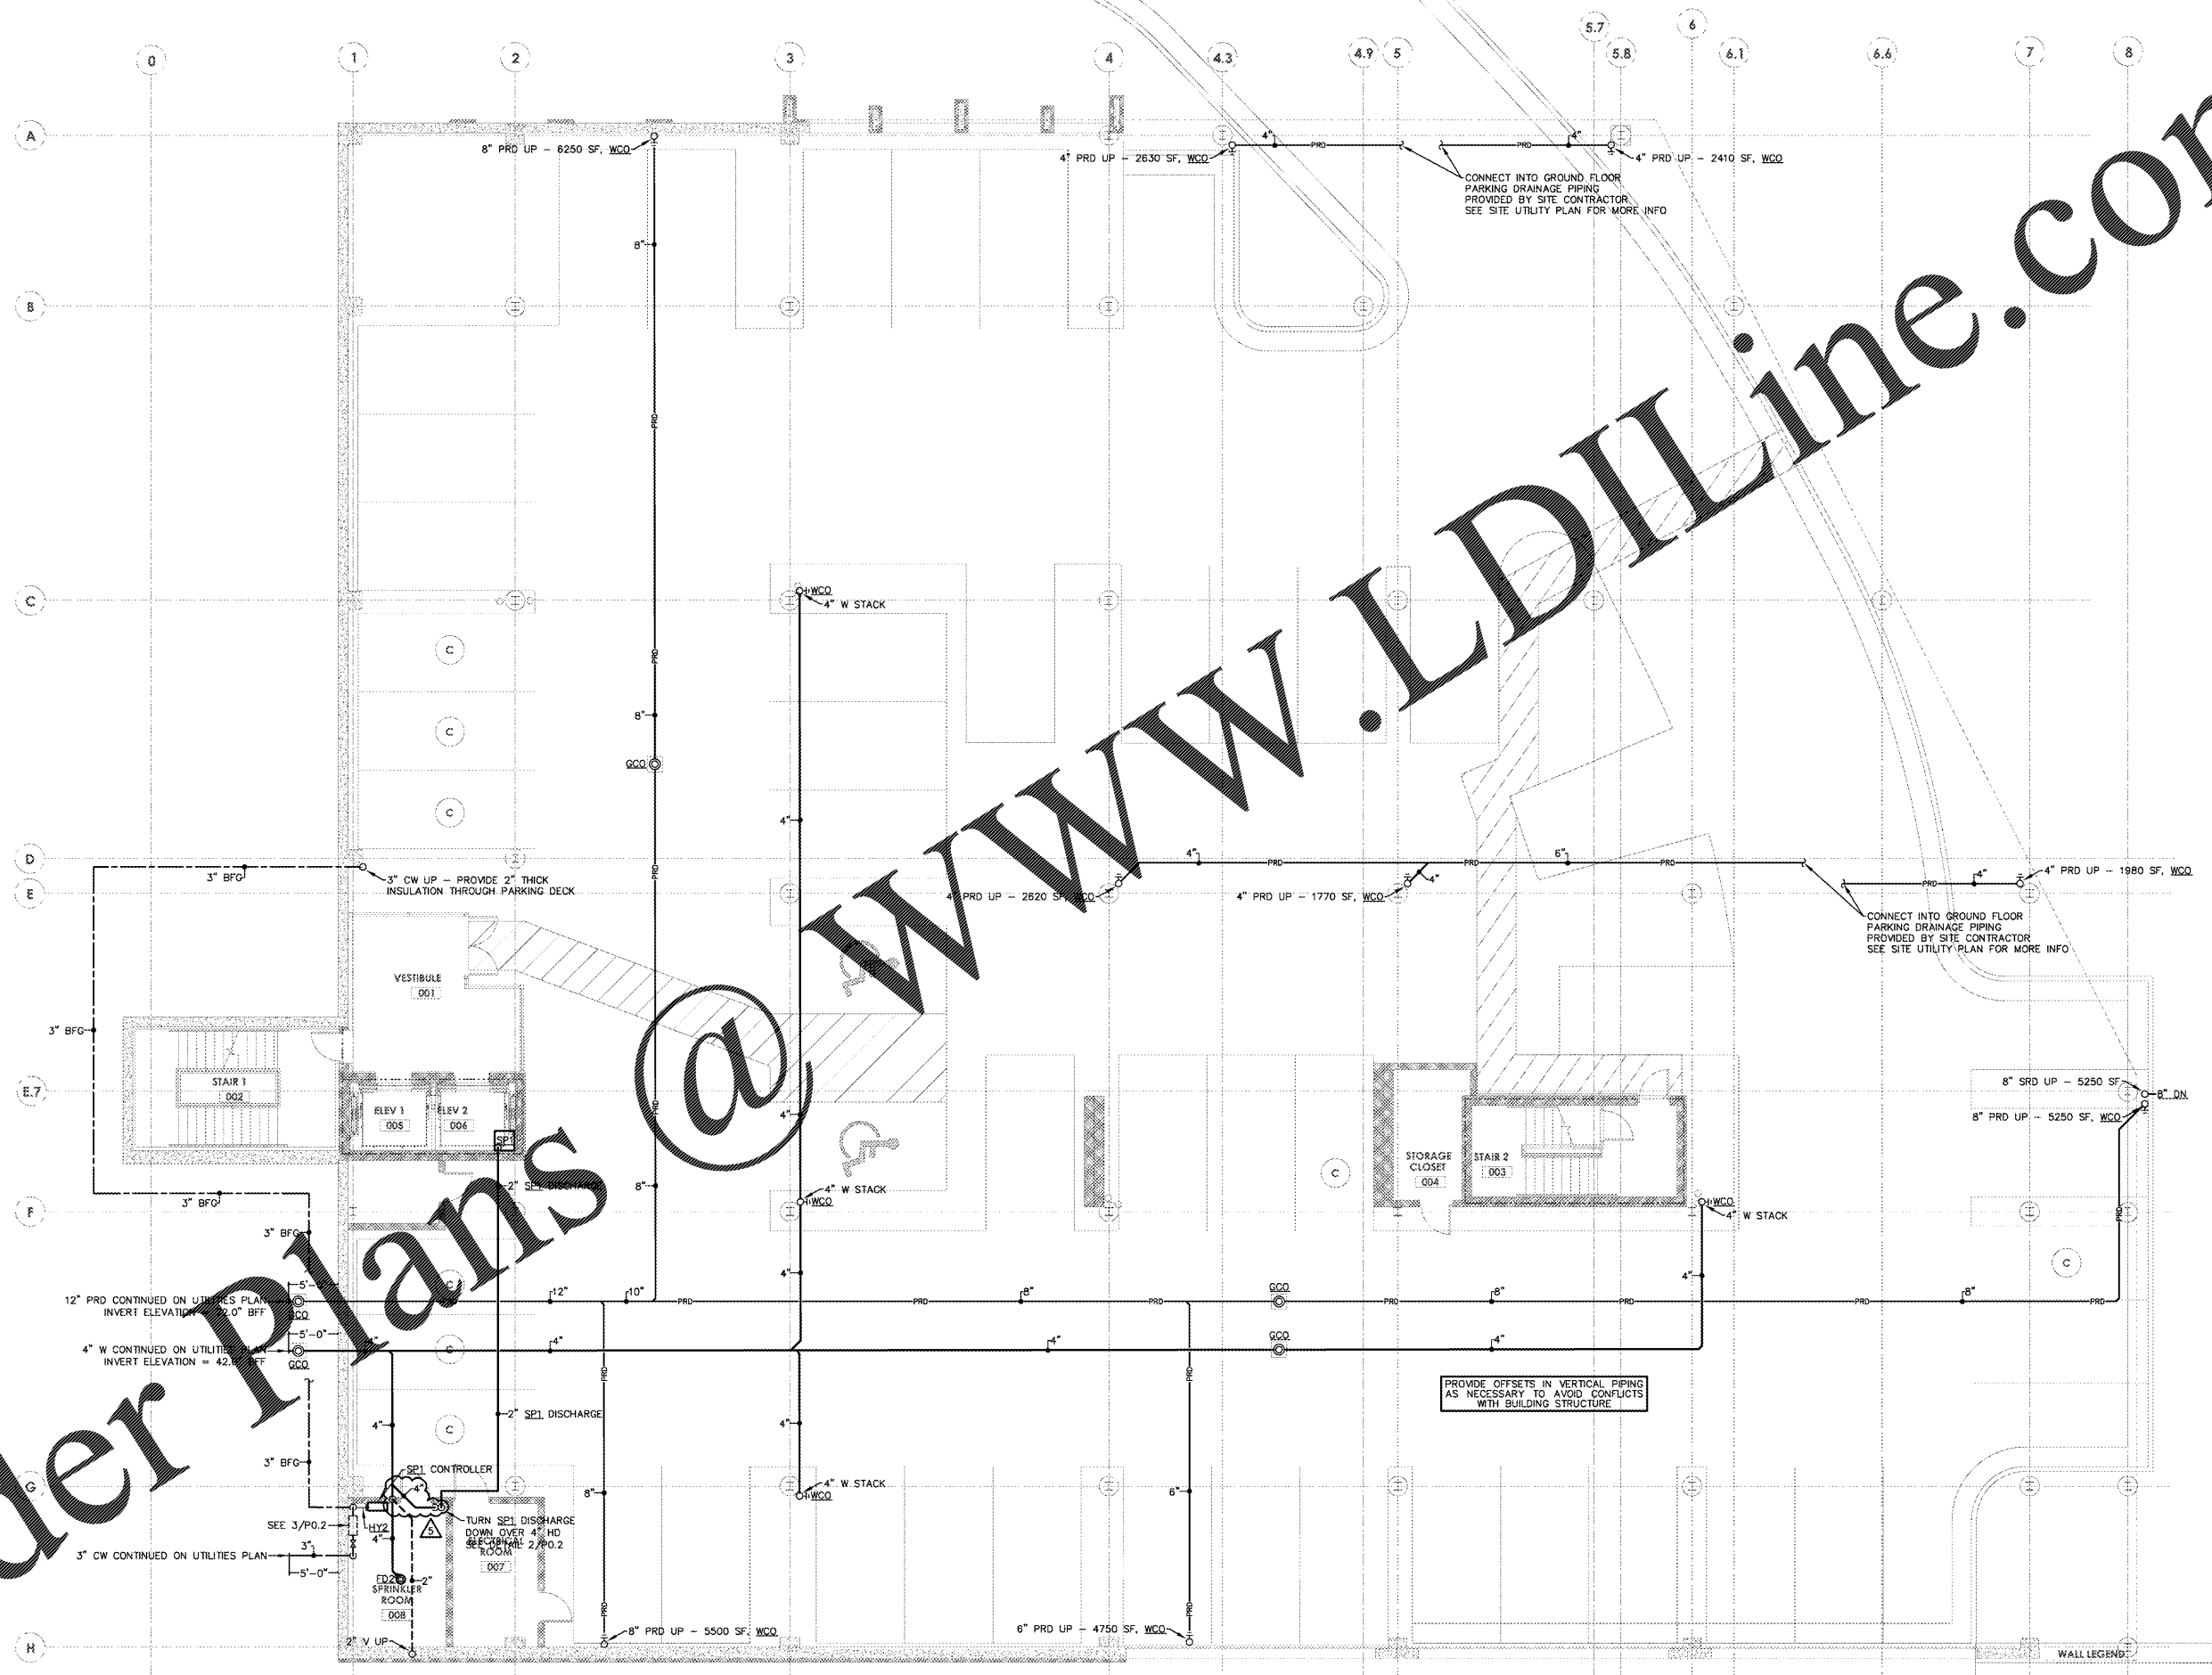

1 GROUND FLOOR PLUMBING PLAN
1/8" = 1'-0"

Order Plans @ WWW.LDILine.com

L:\2016-R\16-0194.XPSA.DWG