


FINLEY DESIGN PA
 7806 NC HWY 751
 SUITE 110
 DURHAM, NC 27713
 P 919-493-8200
 F 919-493-8113
 FINLEYDESIGNARCH.COM

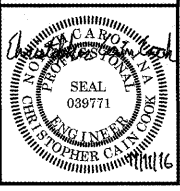


WESTPOINT 2
DURHAM, NC

REVISIONS

PROJECT: 1342
 DATE: 11/11/16
 DRAWN BY: GCB
 CHECKED BY: GCB
THIRD FLOOR PLUMBING PLAN
P1.3
 6 OF 9

L:\2016-11-01\1342\XFSAN.DWG

Order Plans @ www.LDILine.com

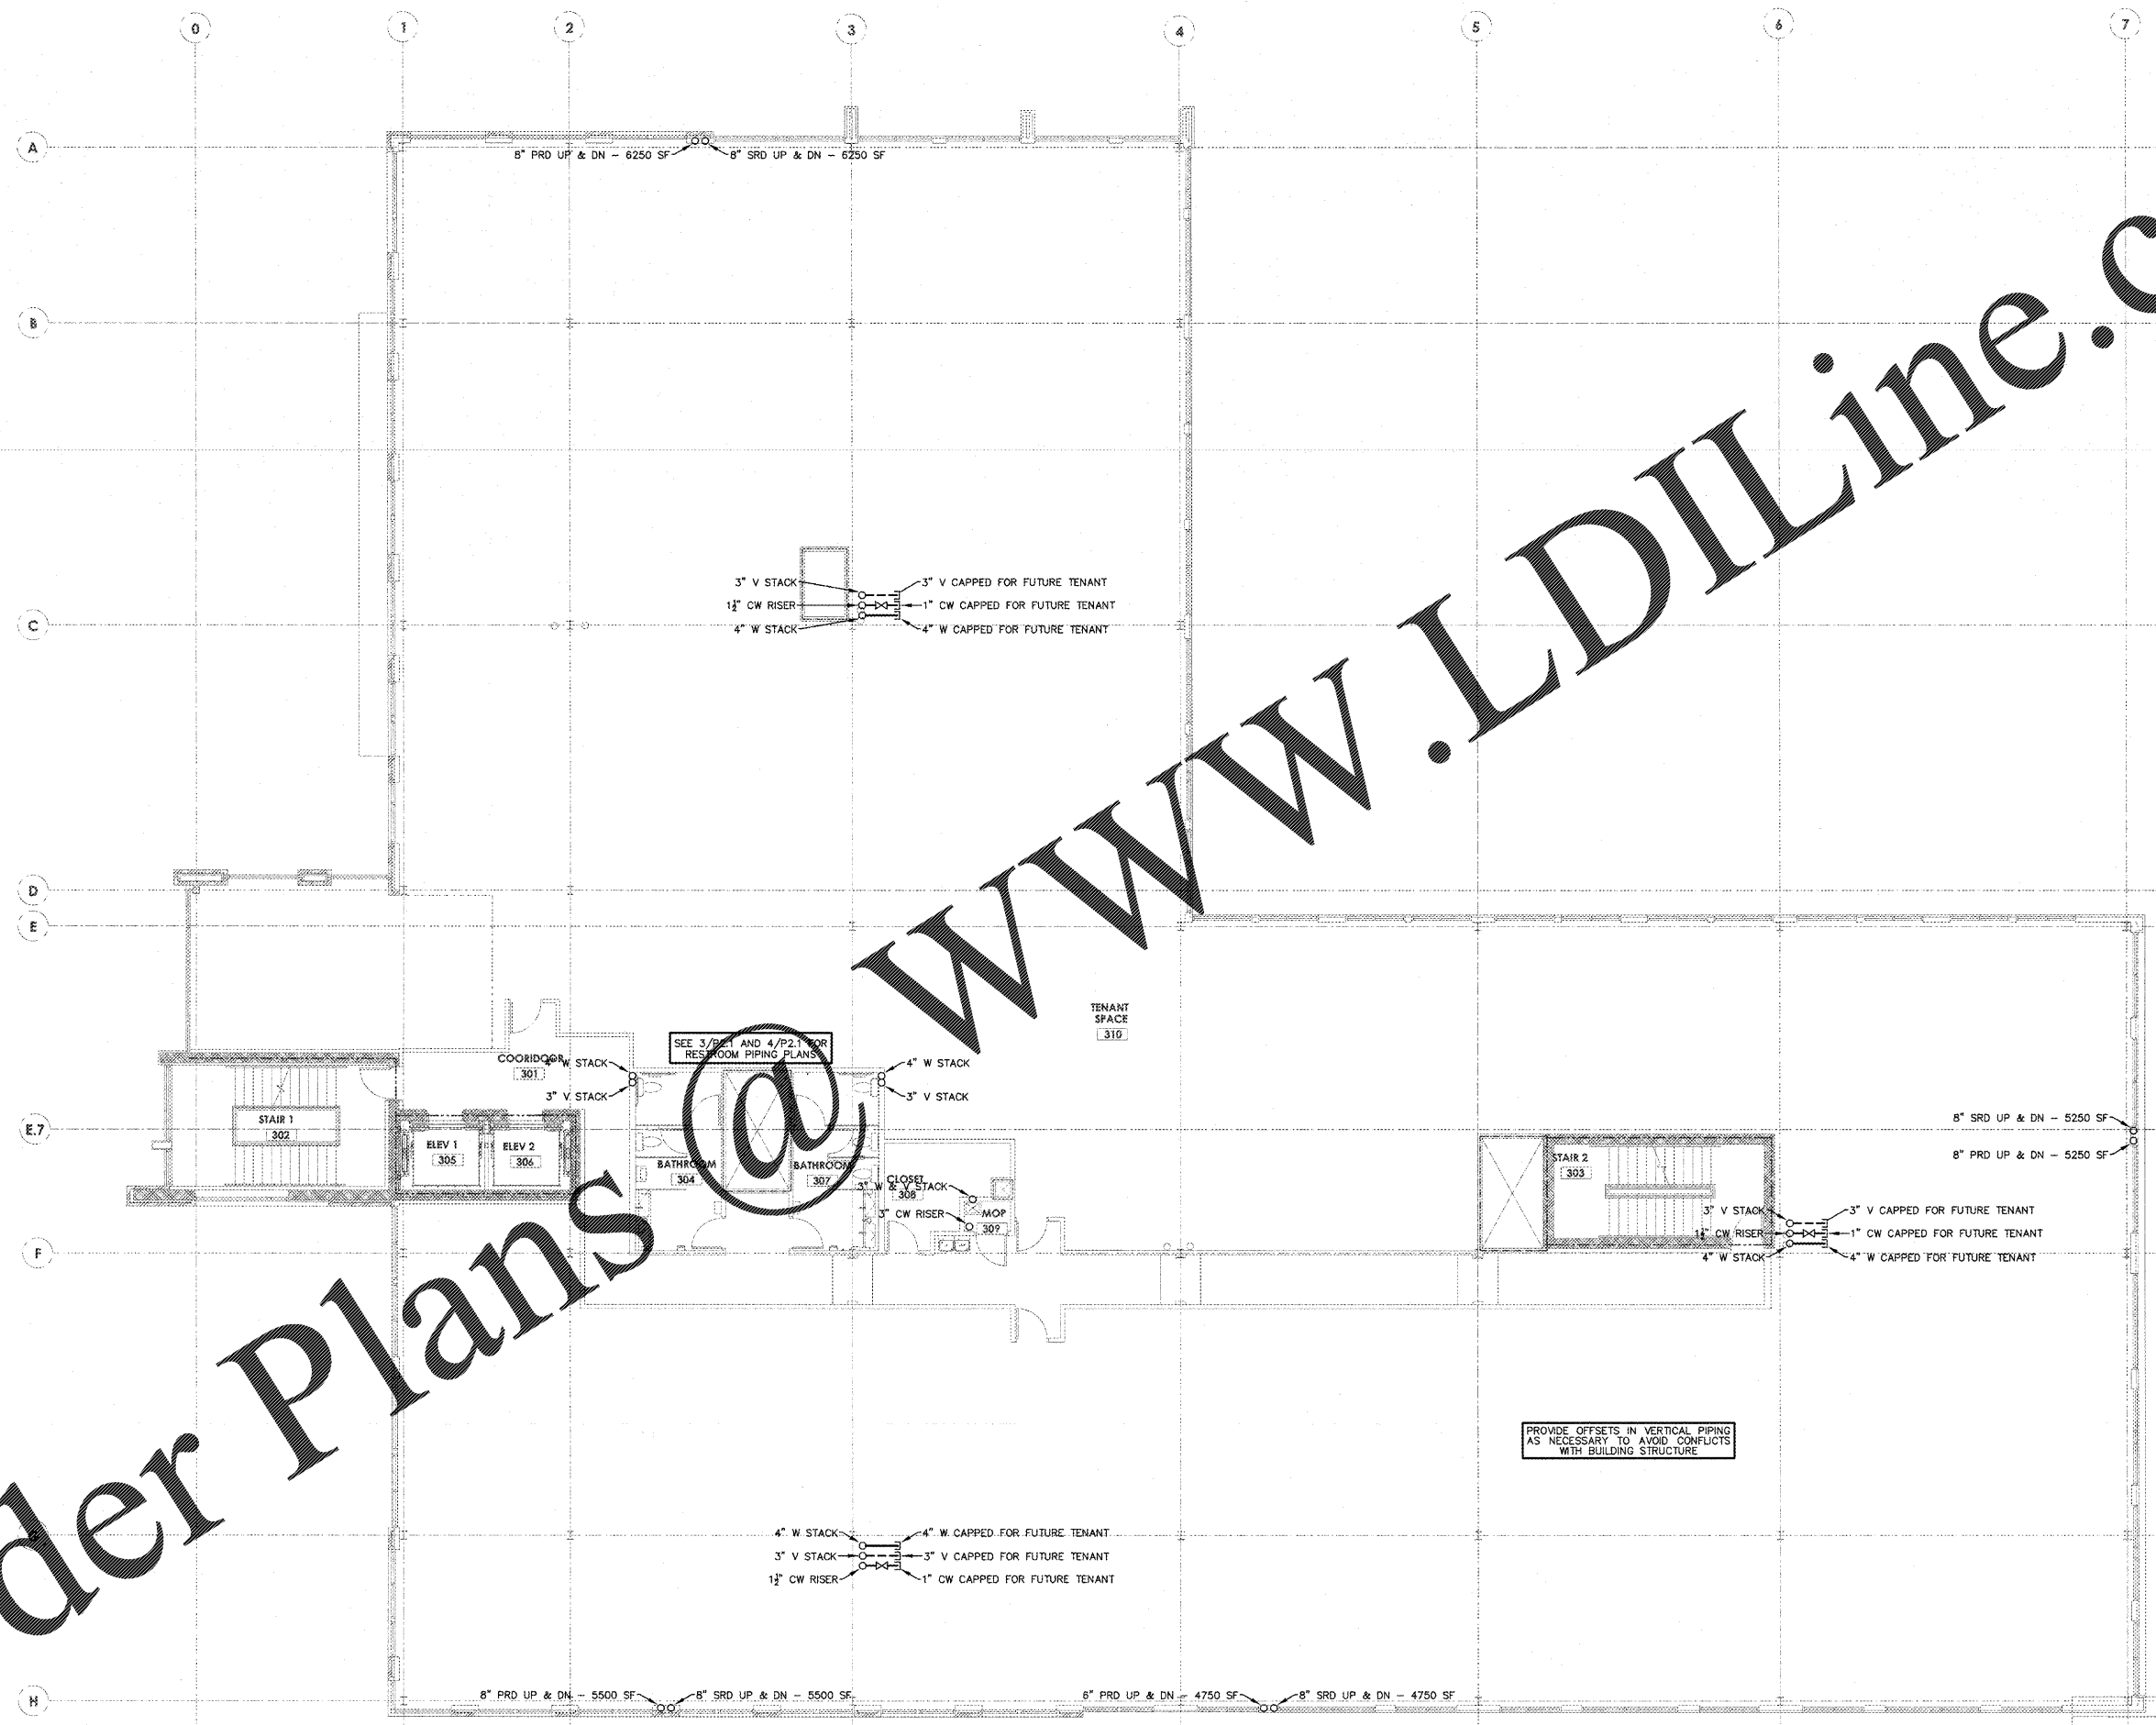

1 THIRD FLOOR PLUMBING PLAN
 1/8" = 1'-0"

WALL LEGEND

---	1-HR RATED WALL
---	2-HR RATED WALL