


www.LDILine.com

Order Plans @

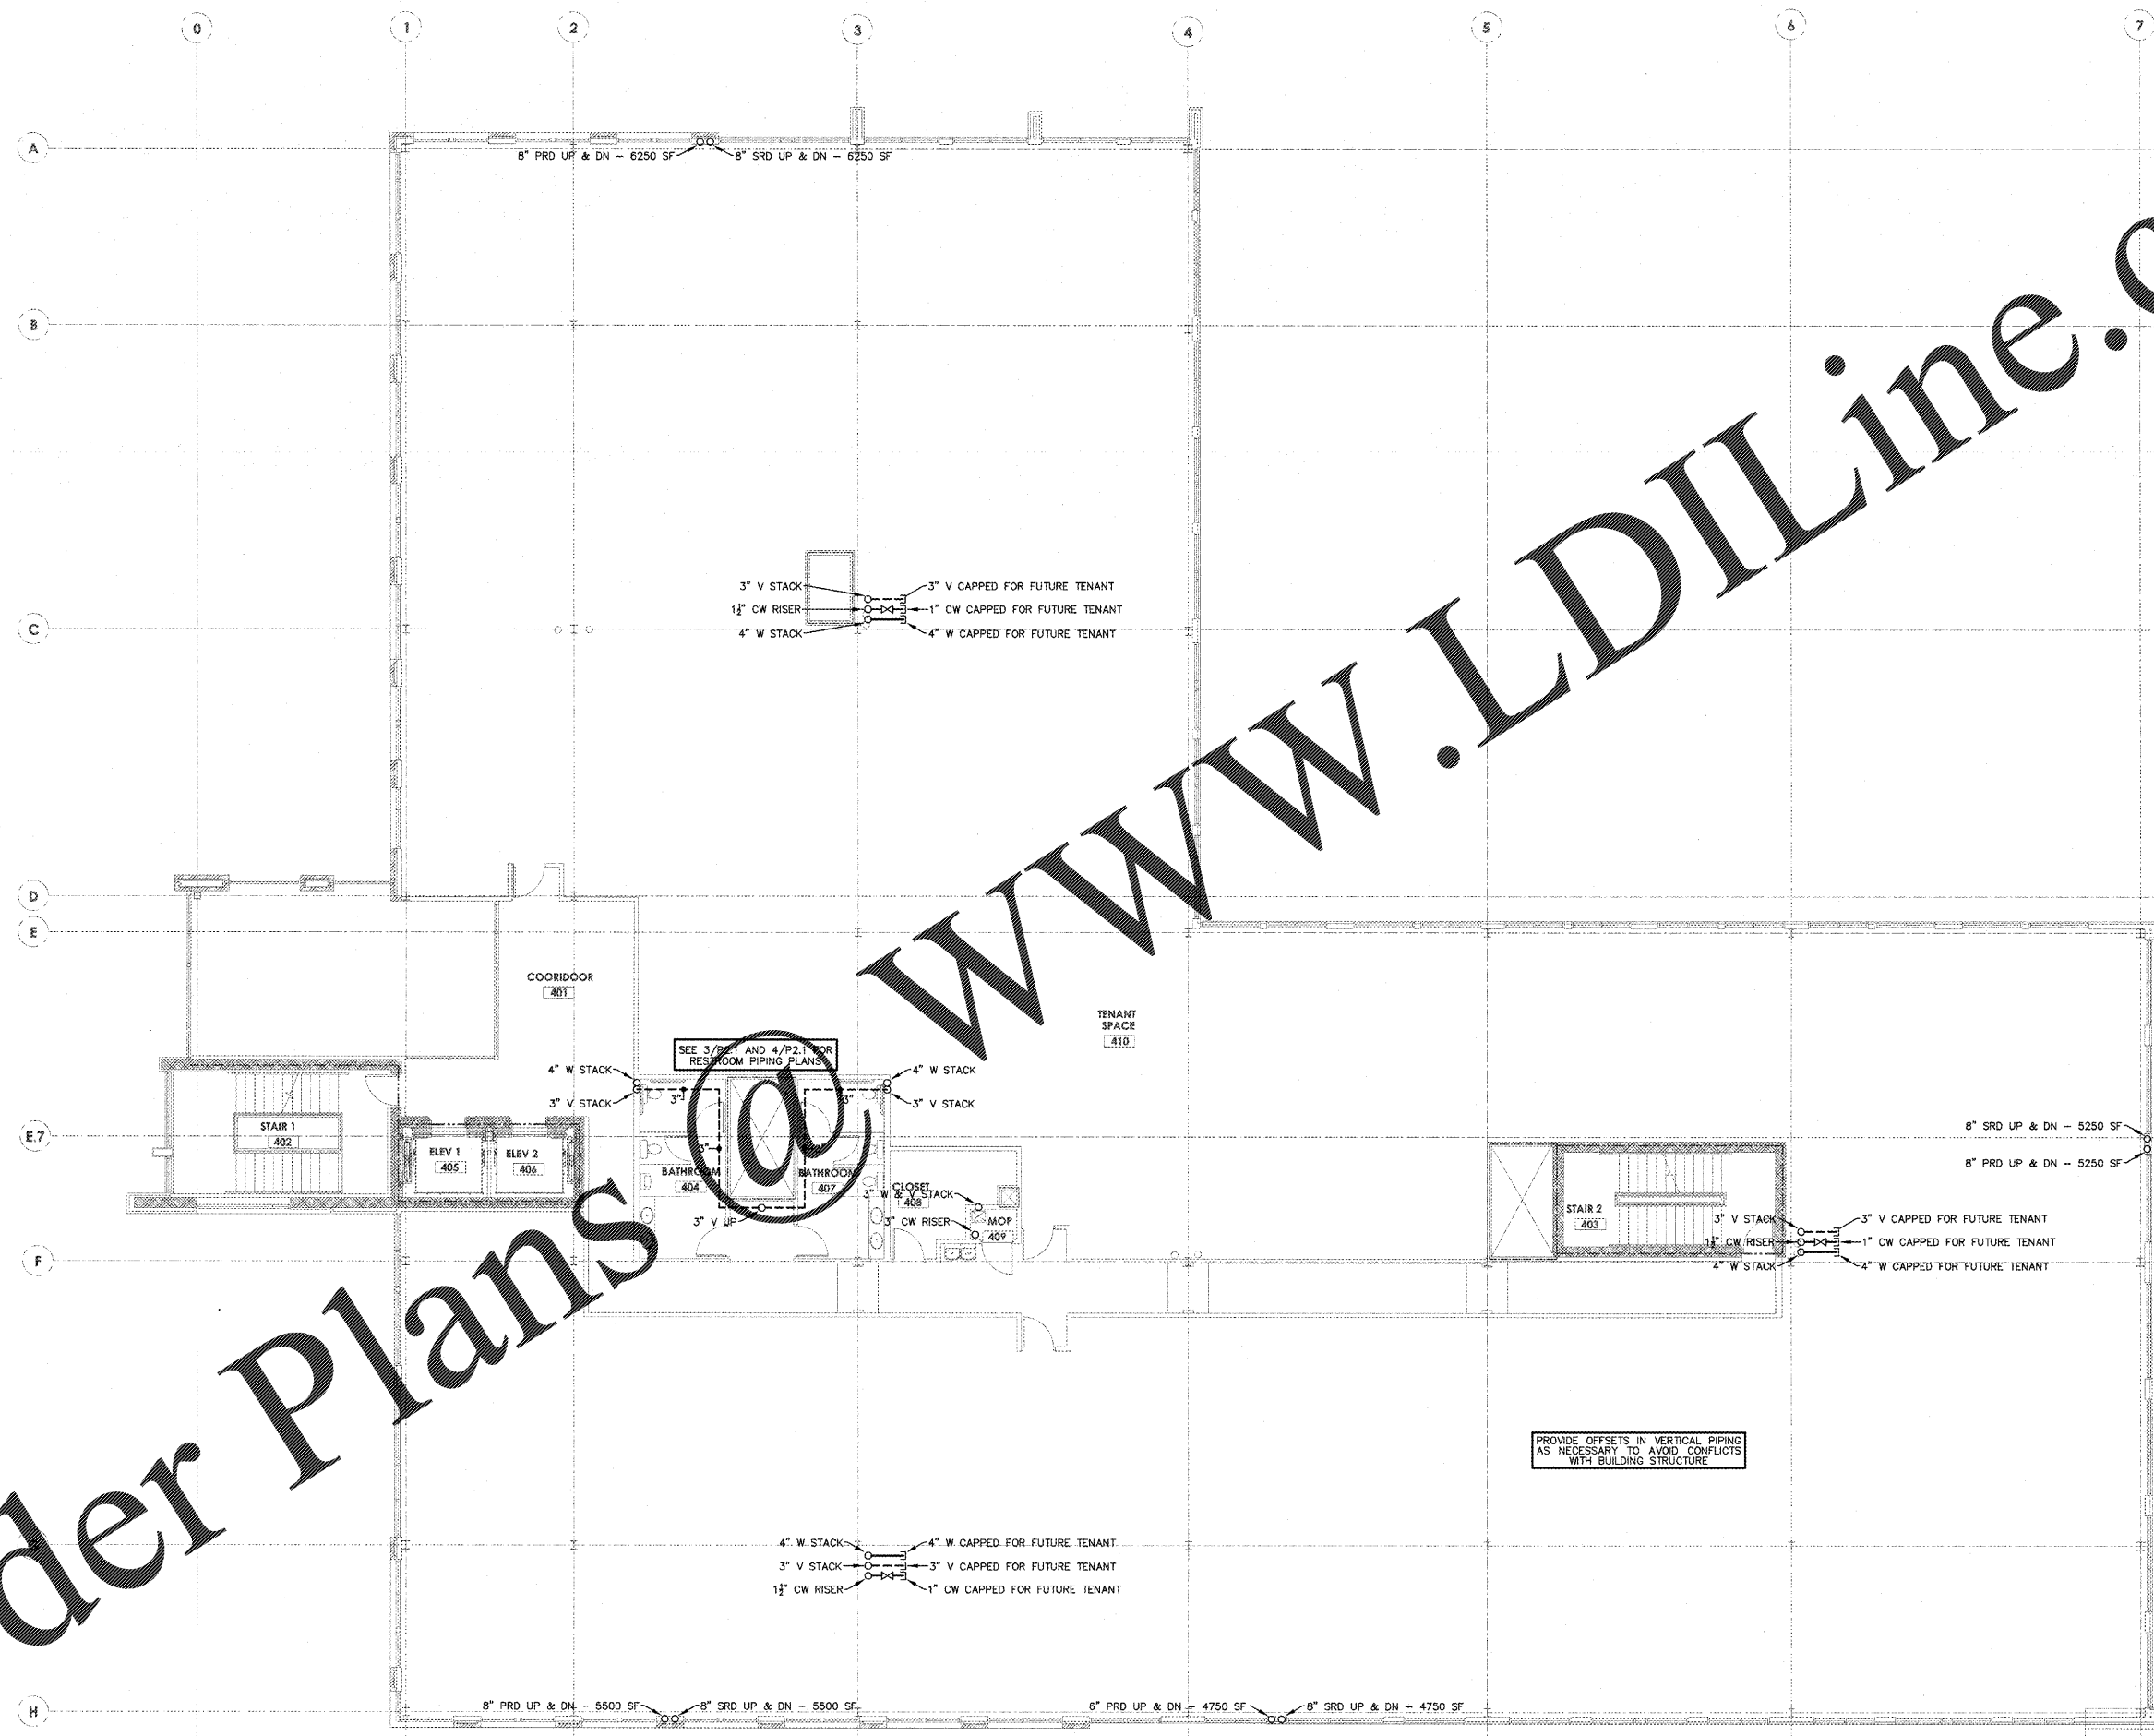


1 FOURTH FLOOR PLUMBING PLAN  
1/8" = 1'-0"

WALL LEGEND

	1-HR RATED WALL
	2-HR RATED WALL

**FINLEY DESIGN PA**  
ARCHITECTURE & INTERIORS  
7806 NC Hwy 751  
SUITE 110  
DURHAM, NC 27713  
P 919-493-8200  
F 919-493-8113  
FINLEYDESIGNARCH.COM

**optima engineering**  
130 Fayetteville St., Suite 200, Raleigh, NC 27601  
1627 South Tryon St., Suite 300, Charlotte, NC 28203  
Phone: 919-828-2202 • www.optimaengineering.com

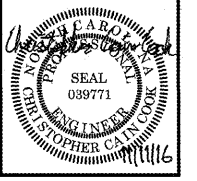

WESTPOINT 2  
DURHAM, NC

REVISIONS


PROJECT: 1342  
DATE: 11/11/16  
DRAWN BY: CCC  
CHECKED BY: GCF  
**FOURTH FLOOR PLUMBING PLAN**  
**P1.4**  
7 OF 9  
OPTIMA # 16-0194