

**FINLEY DESIGN PA**  
 7806 NC Hwy 751  
 SUITE 110  
 DURHAM, NC 27713  
 P 919-493-8200  
 F 919-493-8113  
 FINLEYDESIGNARCH.COM




**WESTPOINT 2**  
**DURHAM, NC**

REVISIONS


PROJECT: 1342  
 DATE: 11/11/16  
 DRAWN BY: GCF  
 CHECKED BY: GCF  
**ROOF PLUMBING PLAN**  
**P1.5**  
 8 OF 9

L:\2016-R\16-0194.XPS&DWG

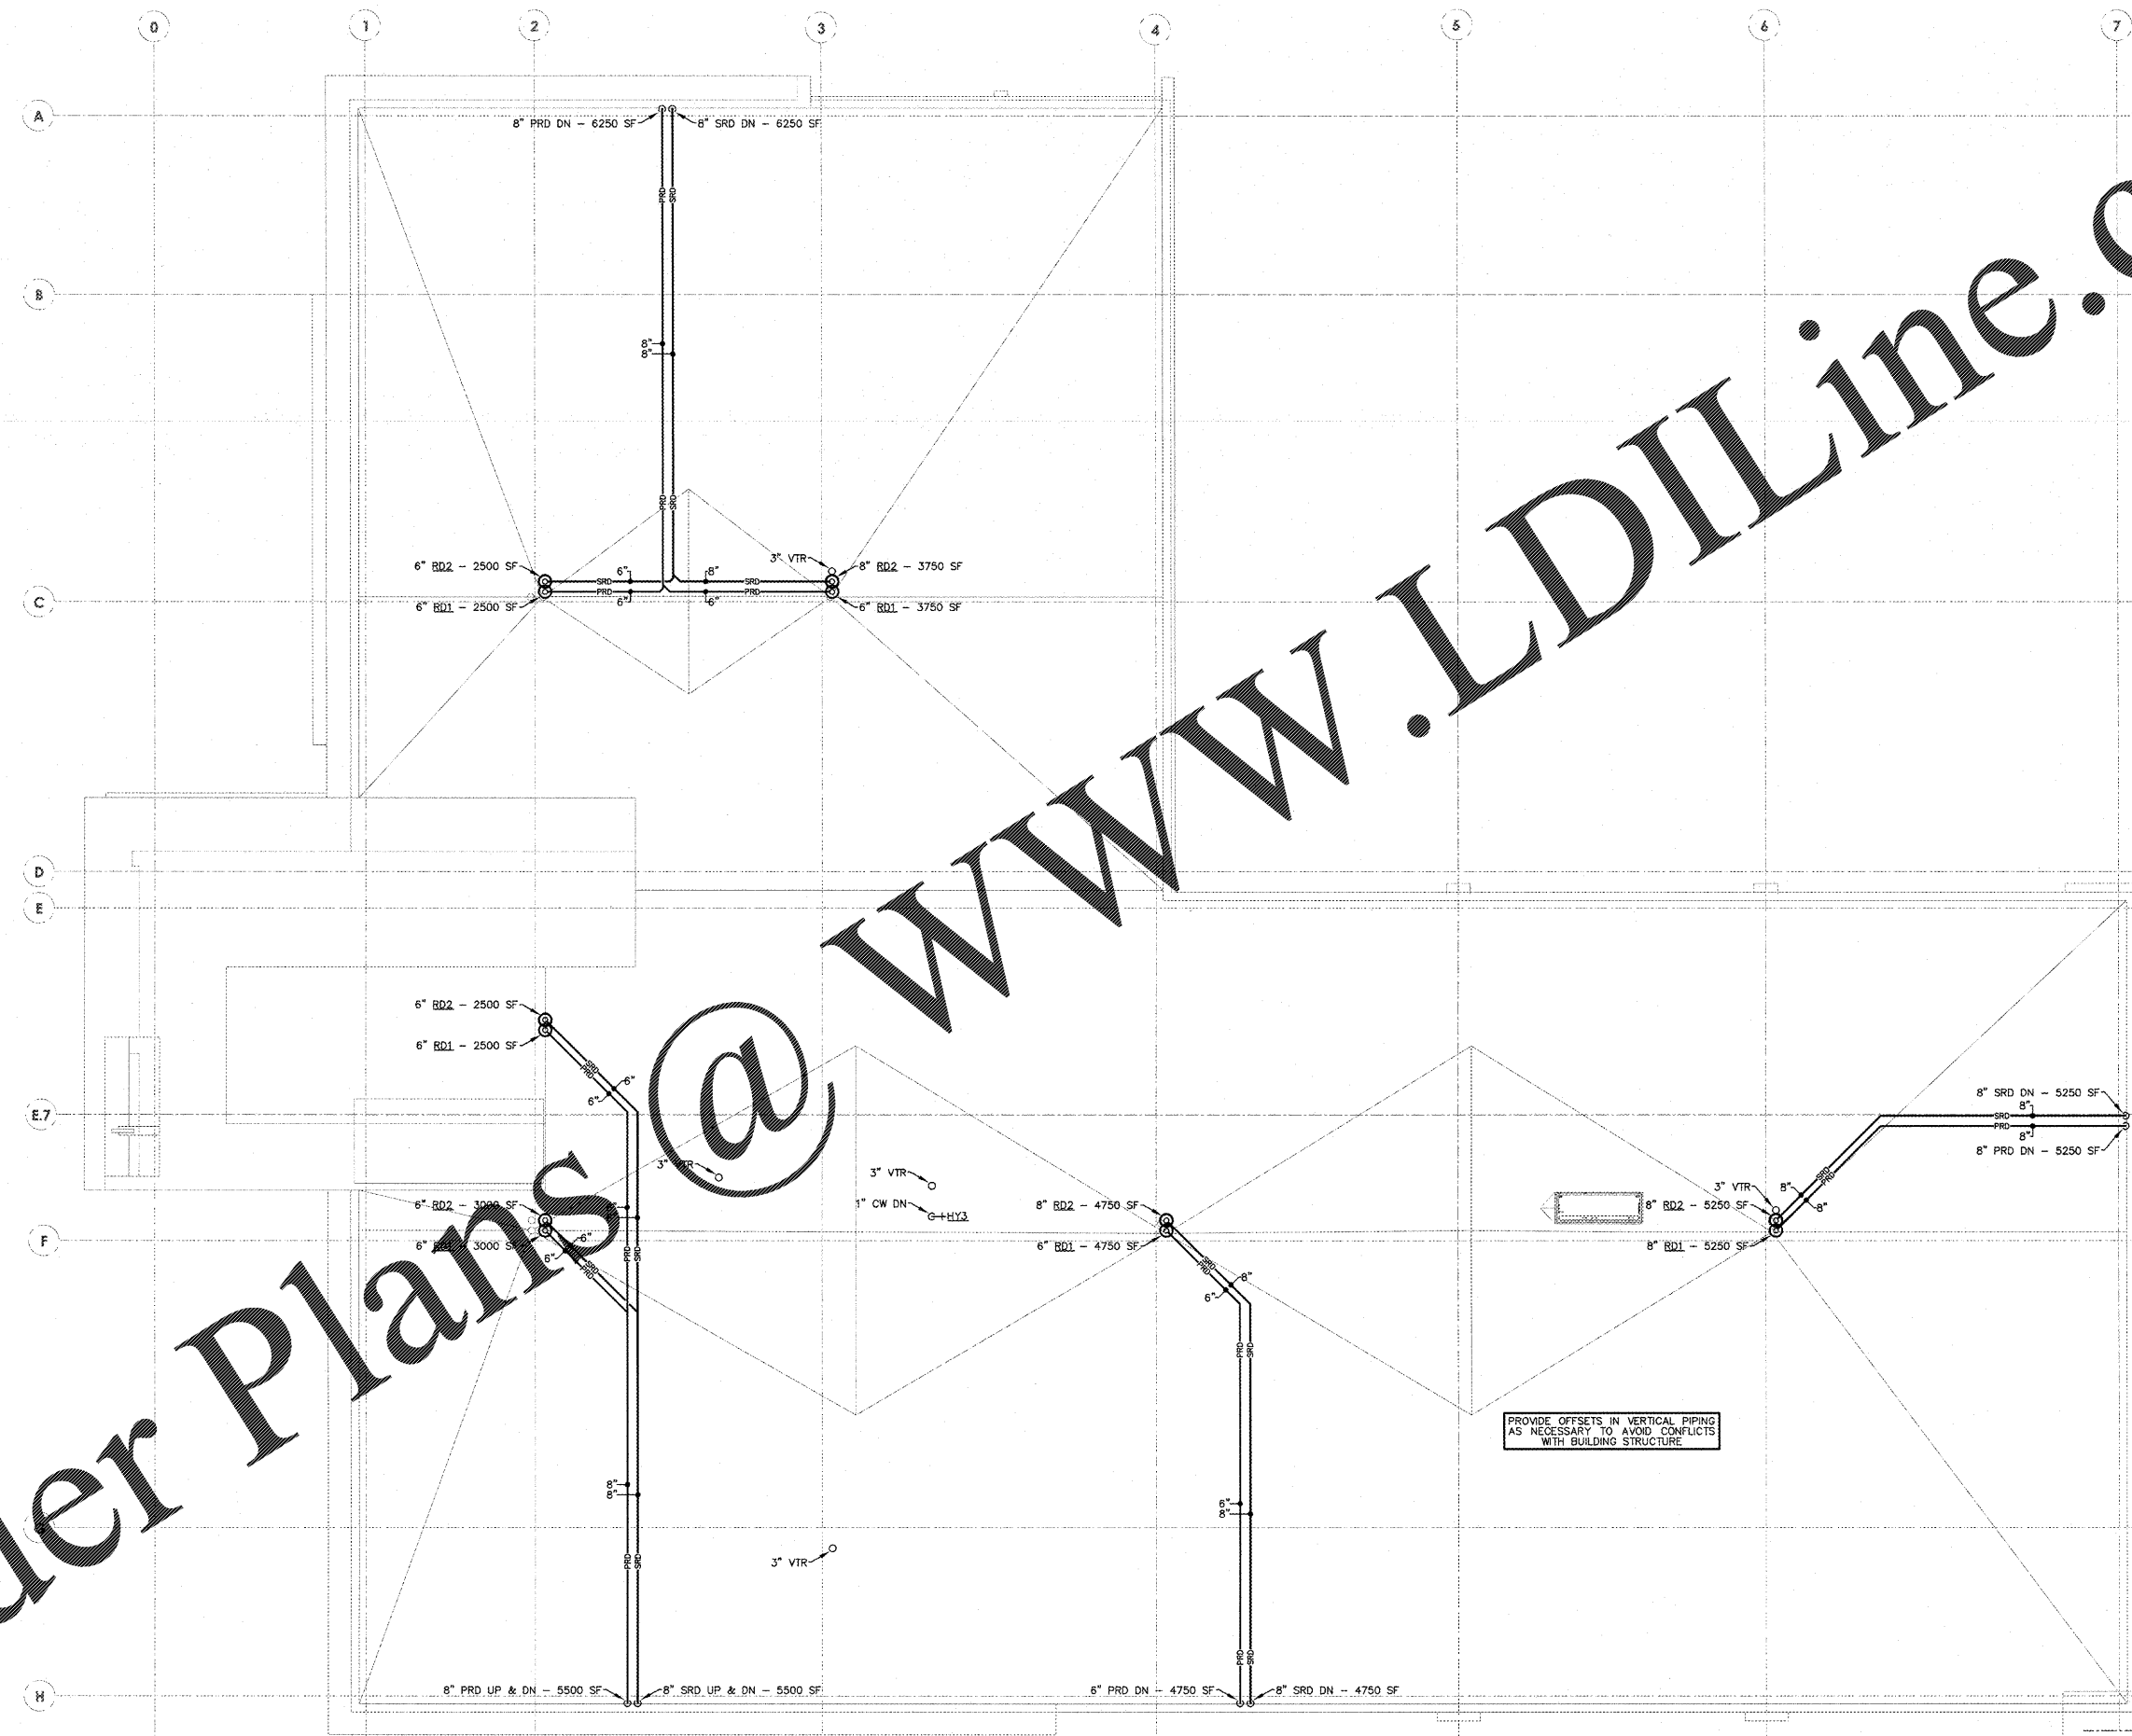

Order Plans @ WWW.LDILine.com

**1 ROOF PLUMBING PLAN**  
 1/8" = 1'-0"

PROVIDE OFFSETS IN VERTICAL PIPING AS NECESSARY TO AVOID CONFLICTS WITH BUILDING STRUCTURE.

WALL LEGEND

---	1-HR RATED WALL
---	2-HR RATED WALL