




② SECOND FLOOR RESTROOMS - PRESSURE PIPING
1/4" = 1'-0"

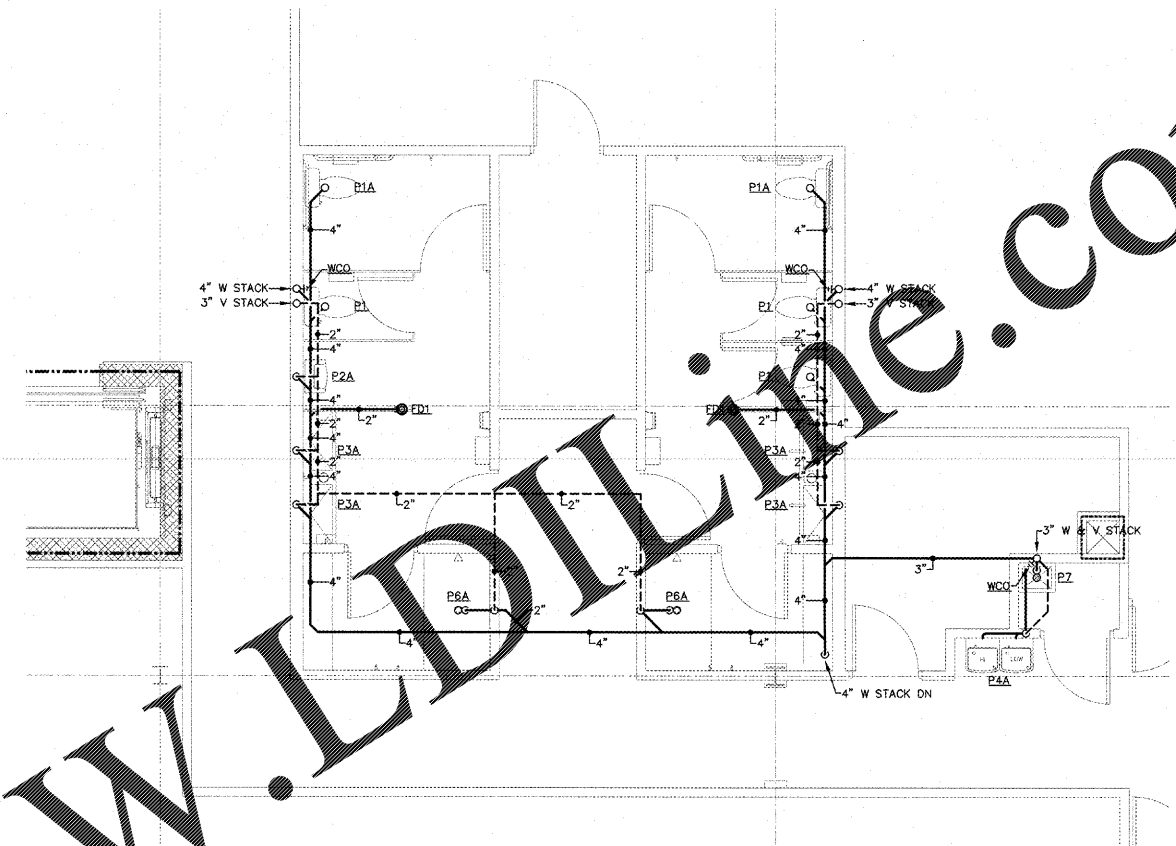

① SECOND FLOOR RESTROOMS - GRAVITY PIPING
1/4" = 1'-0"

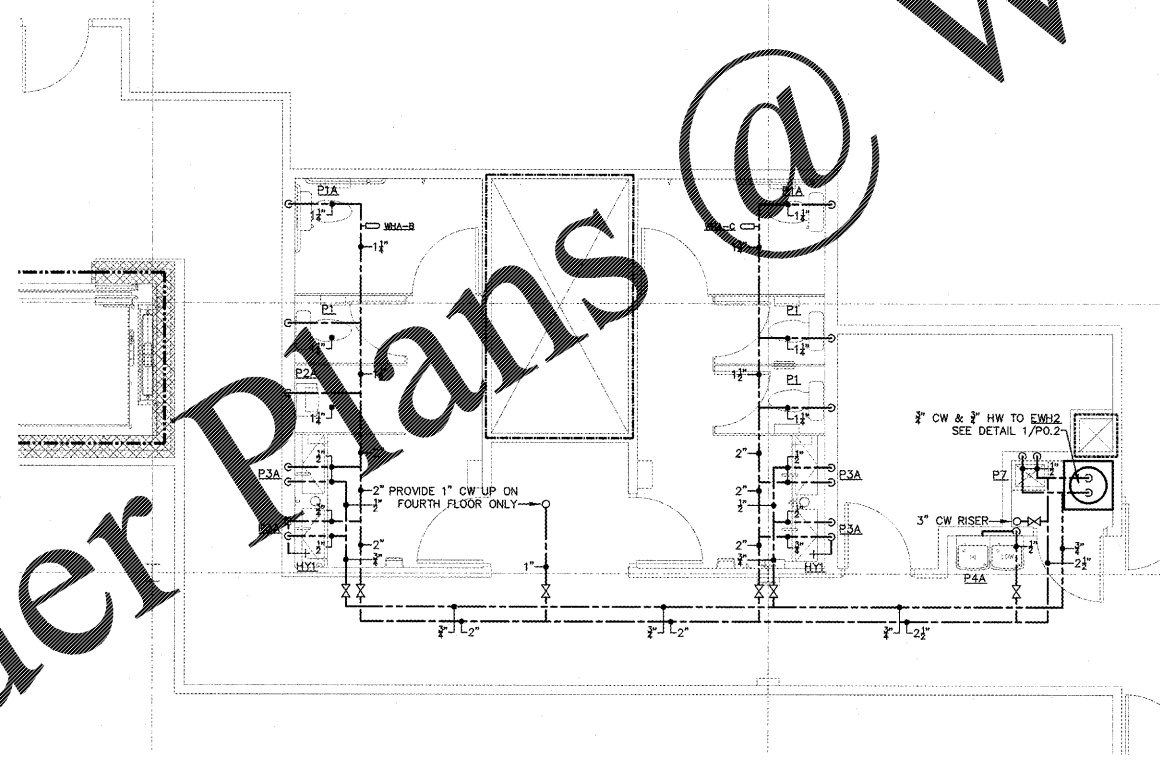

④ THIRD AND FOURTH FLOOR RESTROOMS - PRESSURE PIPING
1/4" = 1'-0"

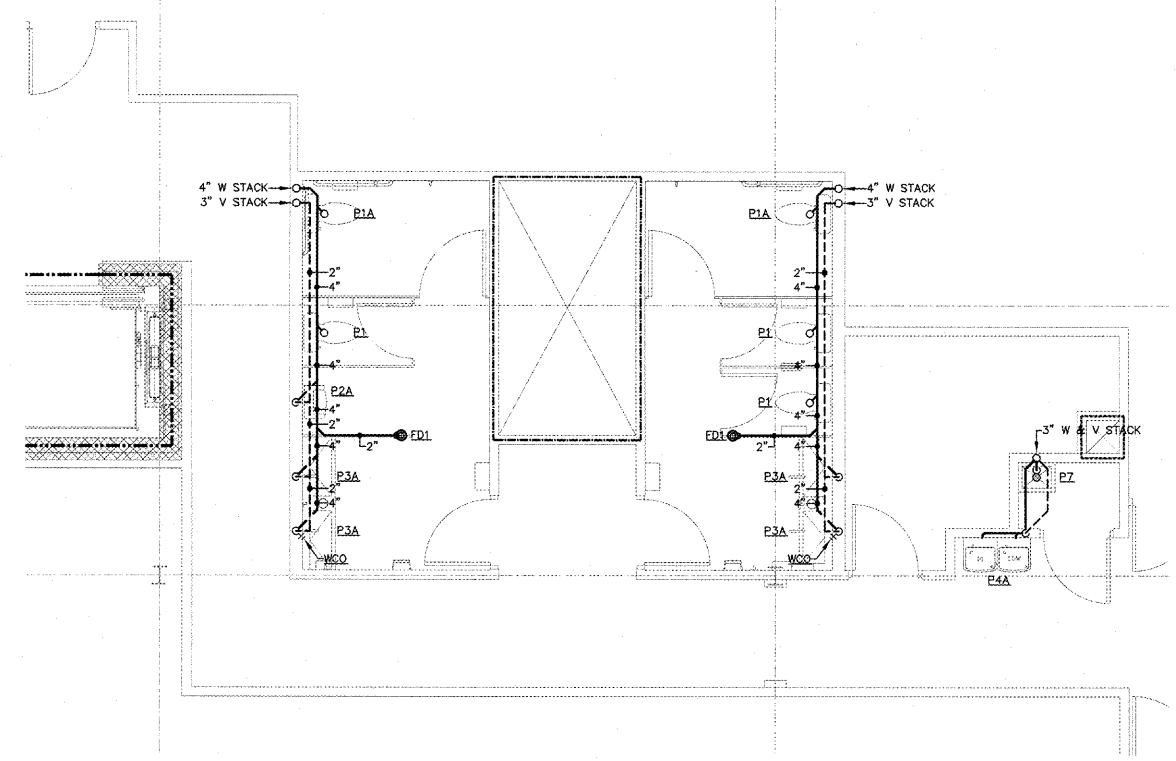

③ THIRD AND FOURTH FLOOR RESTROOMS - GRAVITY PIPING
1/4" = 1'-0"

WALL LEGEND

	1-HR RATED WALL
	2-HR RATED WALL

Order Plans @ www.LDOnline.com

WWW.LDOnline.com

WESTPOINT 2
DURHAM, NC

REVISIONS

PROJECT: 1342
DATE: 11/1/16
DRAWN BY: GCF
CHECKED BY: GCF
ENLARGED
PLUMBING PLAN
P2.1
9 OF 9