


FINLEY DESIGN PA
 7806 NC Hwy 751
 SUITE 110
 DURHAM, NC 27713
 P 919-493-8200
 F 919-493-8113
 FINLEYDESIGNARCH.COM

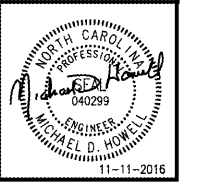


GENERAL NOTES:

1. REFER TO SHEET E0.1 FOR SYMBOLS, ABBREVIATIONS AND GENERAL NOTES.
2. CONTRACTOR SHALL COORDINATE ALL ELECTRICAL DEVICE AND LIGHT FIXTURE LOCATIONS WITH OTHER TRADES PRIOR TO INSTALLATION.
3. ALL EXIT SIGNS, NIGHT LIGHTS AND EMERGENCY EGRESS LIGHTS SHALL BE CONNECTED TO THE NEAREST LIGHTING CIRCUIT UNLESS NOTED.
4. CONTRACTOR SHALL COORDINATE MOUNTING HEIGHTS OF ALL LIGHT FIXTURES PRIOR TO INSTALLATION.

KEYED NOTES: ⓧ

- ① MOUNT FIXTURE 16 INCHES ABOVE STAIR STRINGER.
- ② PROVIDE 375VA CENTRAL INVERTER ABOVE ACCESSIBLE CEILING WITH TEST SWITCH.

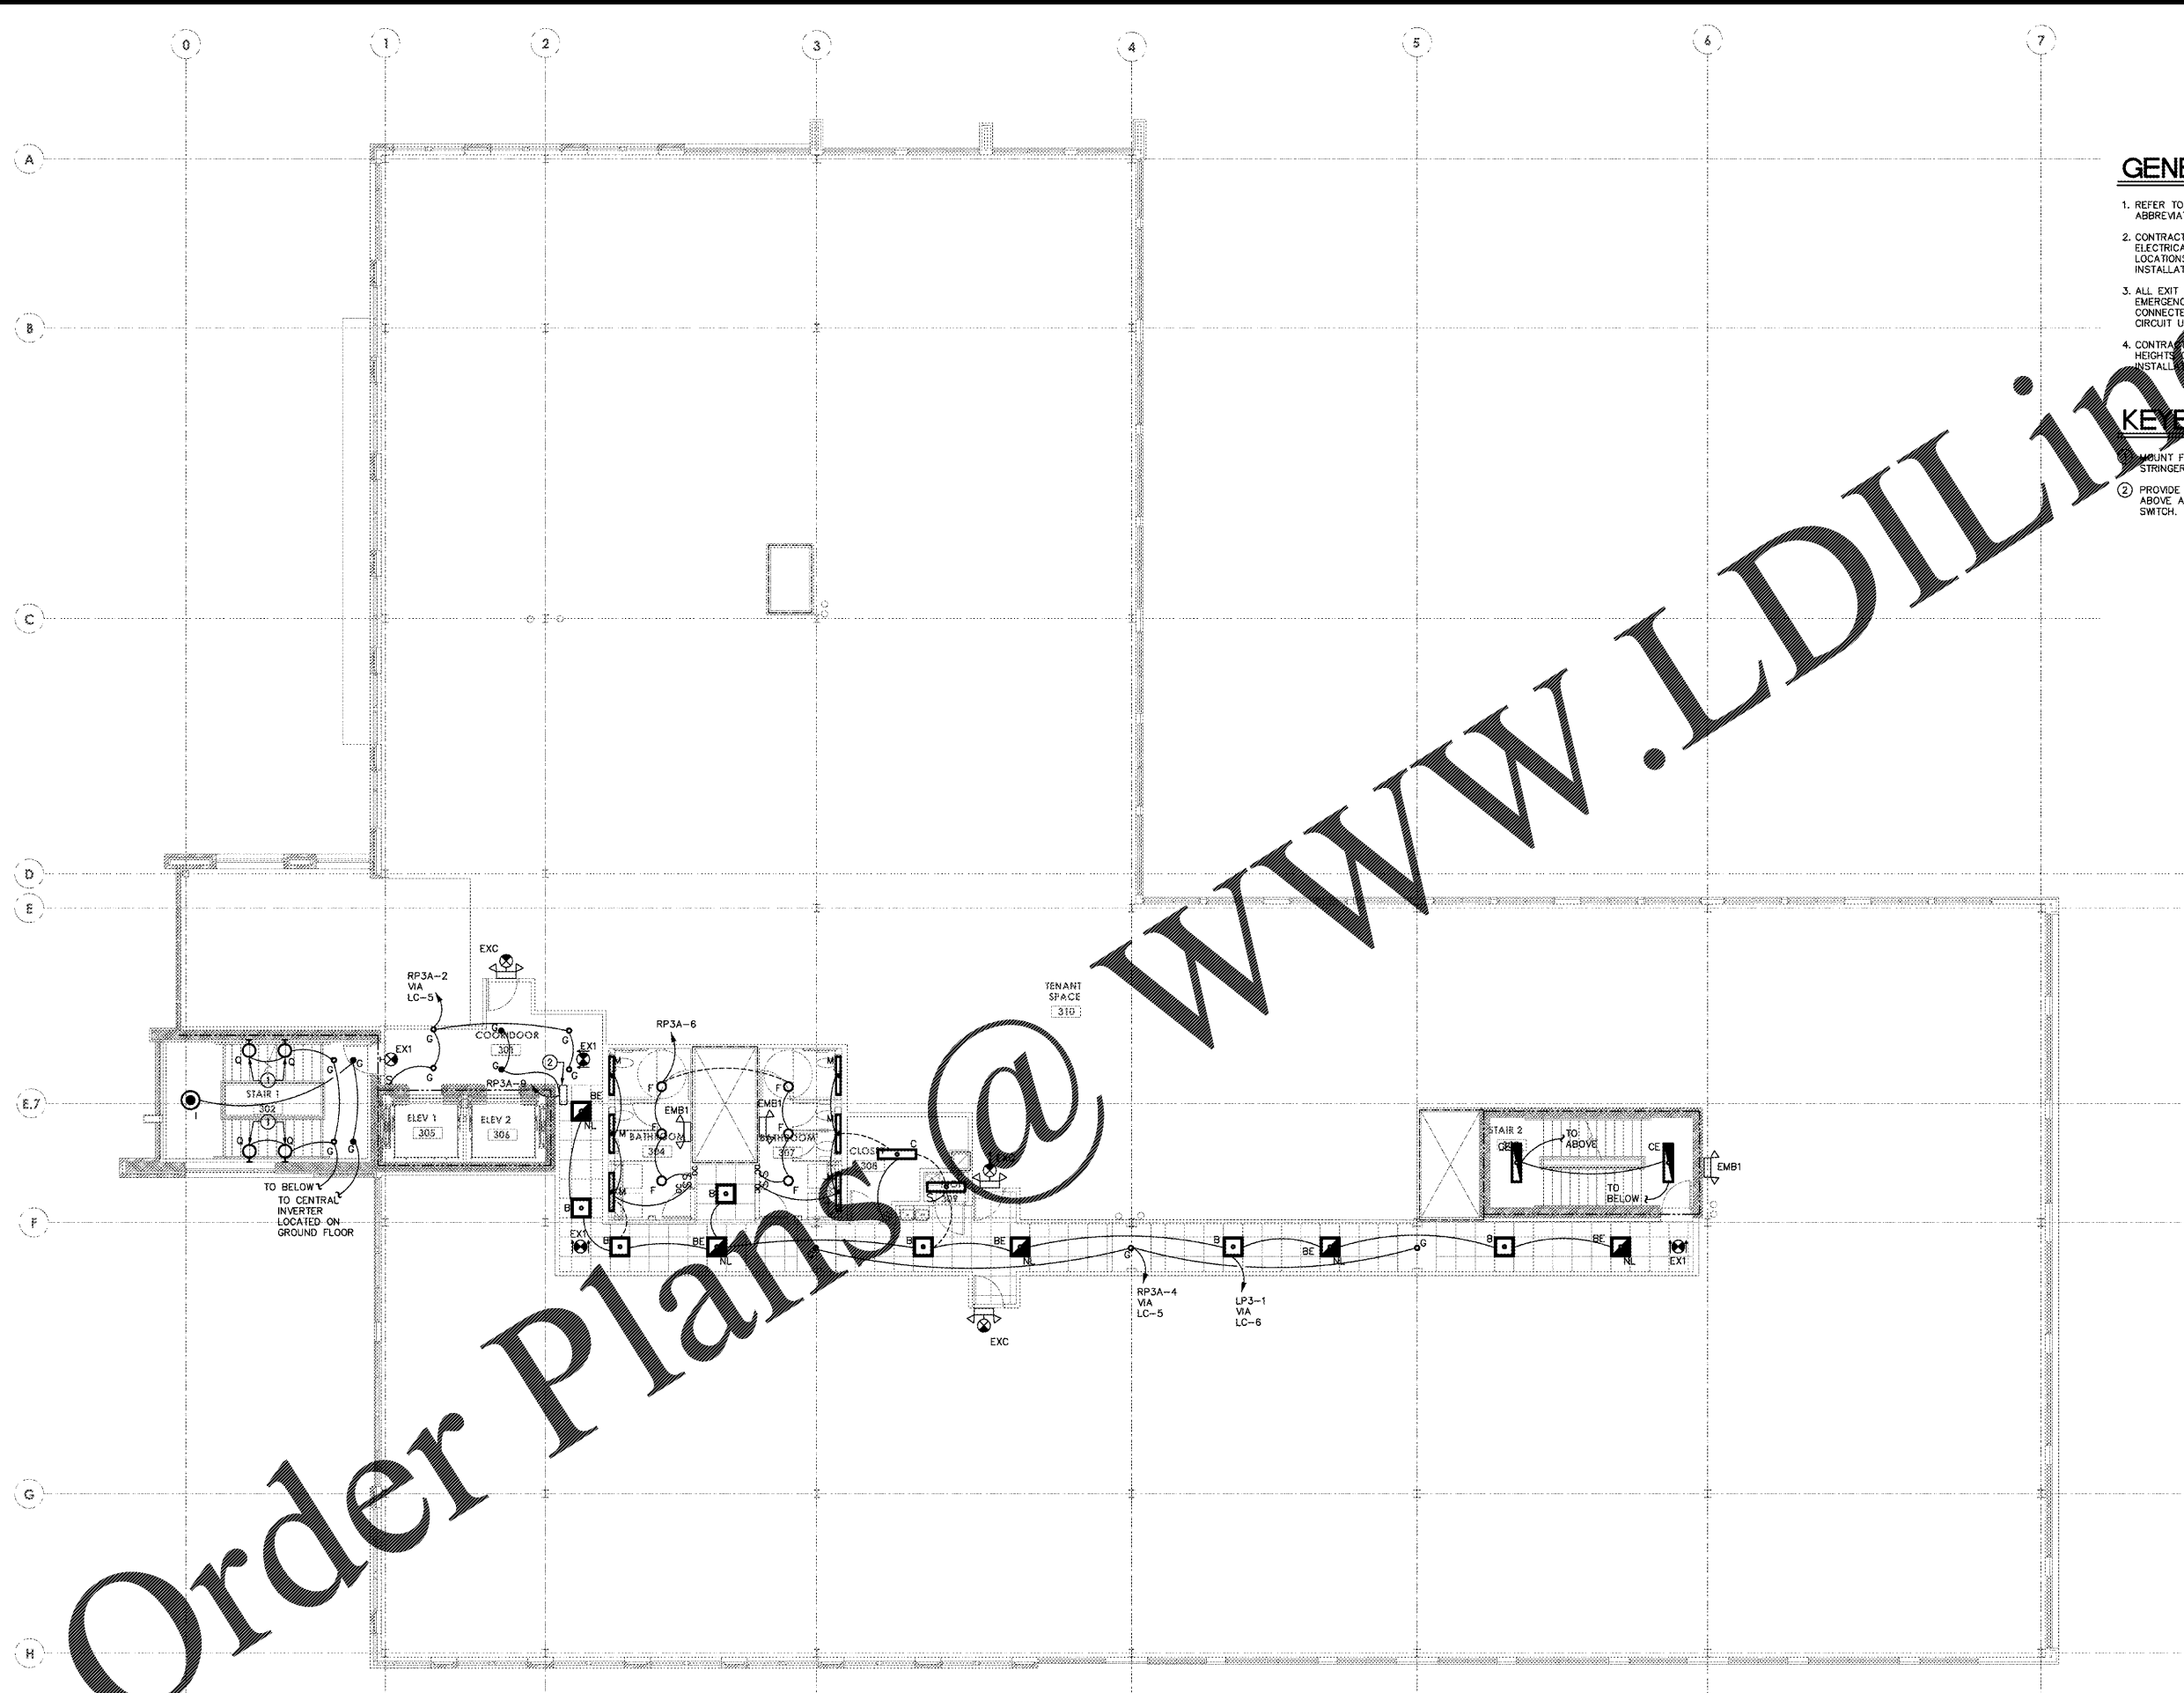

① ELECTRICAL - THIRD FLOOR LIGHTING PLAN
 1/8" = 1'-0"

**WESTPOINT 2
 DURHAM, NC**

REVISIONS

NO.	DESCRIPTION

PROJECT: 1342
 DATE: 11/11/16
 DRAWN BY: ASA
 CHECKED BY: MDH

electrical
 third floor
 lighting plan

E1.3
 13 OF 24

L:\2016-R114-0194\AETIG.DWG