


**FINLEY DESIGN PA**  
 7806 NC HWY 751  
 SUITE 110  
 DURHAM, NC 27713  
 P 919-493-8200  
 F 919-493-8113  
 FINLEYDESIGNARCH.COM

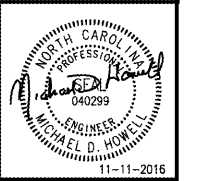


**GENERAL NOTES:**

1. REFER TO SHEET E0.1 FOR SYMBOLS, ABBREVIATIONS AND GENERAL NOTES.
2. CONTRACTOR SHALL COORDINATE ALL ELECTRICAL DEVICE AND LIGHT FIXTURE LOCATIONS WITH OTHER TRADES PRIOR TO INSTALLATION.
3. ALL EXIT SIGNS, NIGHT LIGHTS AND EMERGENCY EGRESS LIGHTS SHALL BE CONNECTED TO THE NEAREST LIGHT CIRCUIT UNSWITCHED.
4. CONTRACTOR SHALL COORDINATE MOUNTING HEIGHTS OF ALL LIGHT FIXTURES PRIOR TO INSTALLATION.

**KEYED NOTES: (X)**

1. MOUNT FIXTURE 16 INCHES ABOVE STAIR SPRINGER.
2. PROVIDE 375VA CENTRAL INVERTER ABOVE ACCESSIBLE CEILING WITH TEST SWITCH.

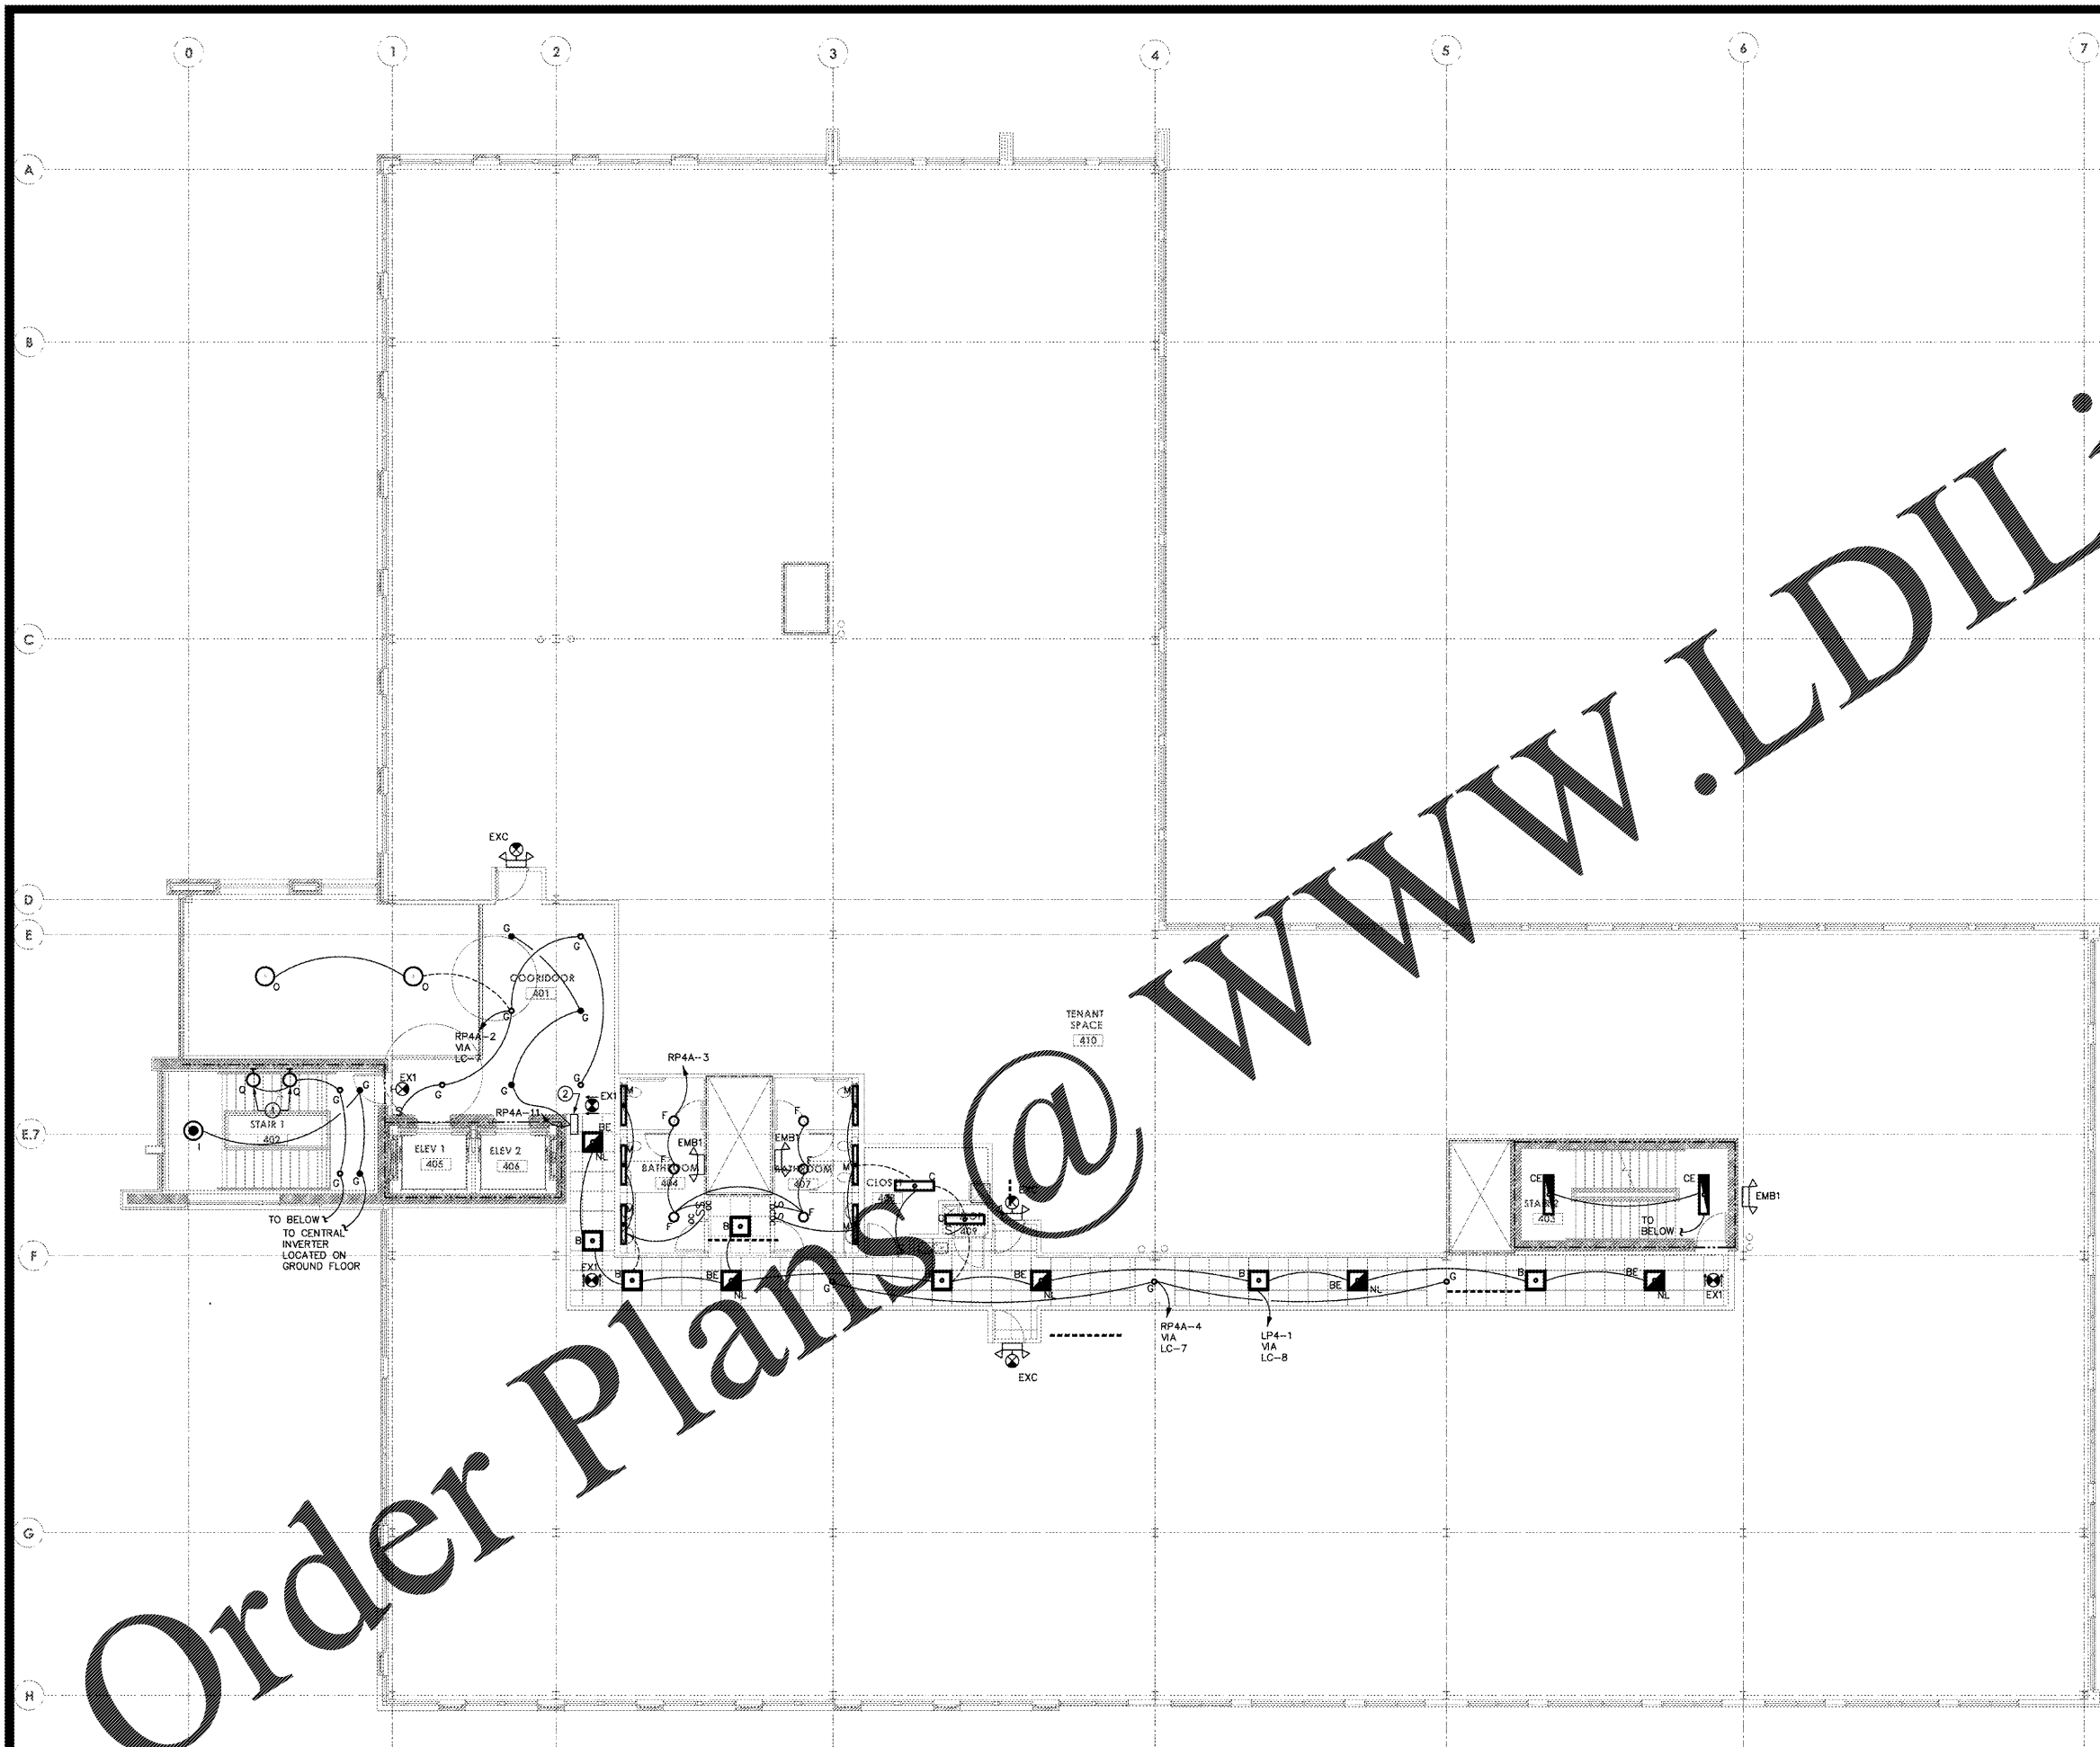

**1 ELECTRICAL - FOURTH FLOOR LIGHTING PLAN**  
 1/8" = 1'-0"

Order Plans @ WWW.LDILLING.COM

**WESTPOINT 2  
 DURHAM, NC**

**REVISIONS**

NO.	DATE	DESCRIPTION

PROJECT: 1342  
 DATE: 11/11/16  
 DRAWN BY: ASA  
 CHECKED BY: MDH

electrical  
 fourth floor  
 lighting plan

**E1.4**  
 14 OF 24