





FINLEY DESIGN PA
 7806 NC HWY 751
 SUITE 110
 DURHAM, NC 27713
 P 919-493-8200
 F 919-493-8113
 FINLEYDESIGNARCH.COM

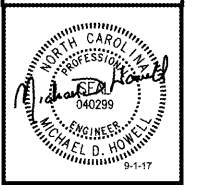

GENERAL NOTES:

1. REFER TO SHEET E0.1 FOR SYMBOLS, ABBREVIATIONS AND GENERAL NOTES.
2. CONTRACTOR SHALL COORDINATE ALL ELECTRICAL DEVICE AND LIGHT FIXTURE LOCATIONS WITH OTHER TRADES PRIOR TO INSTALLATION.
3. REFER TO MECHANICAL SCHEDULES ON SHEET E0.07 FOR DISCONNECT SIZES.

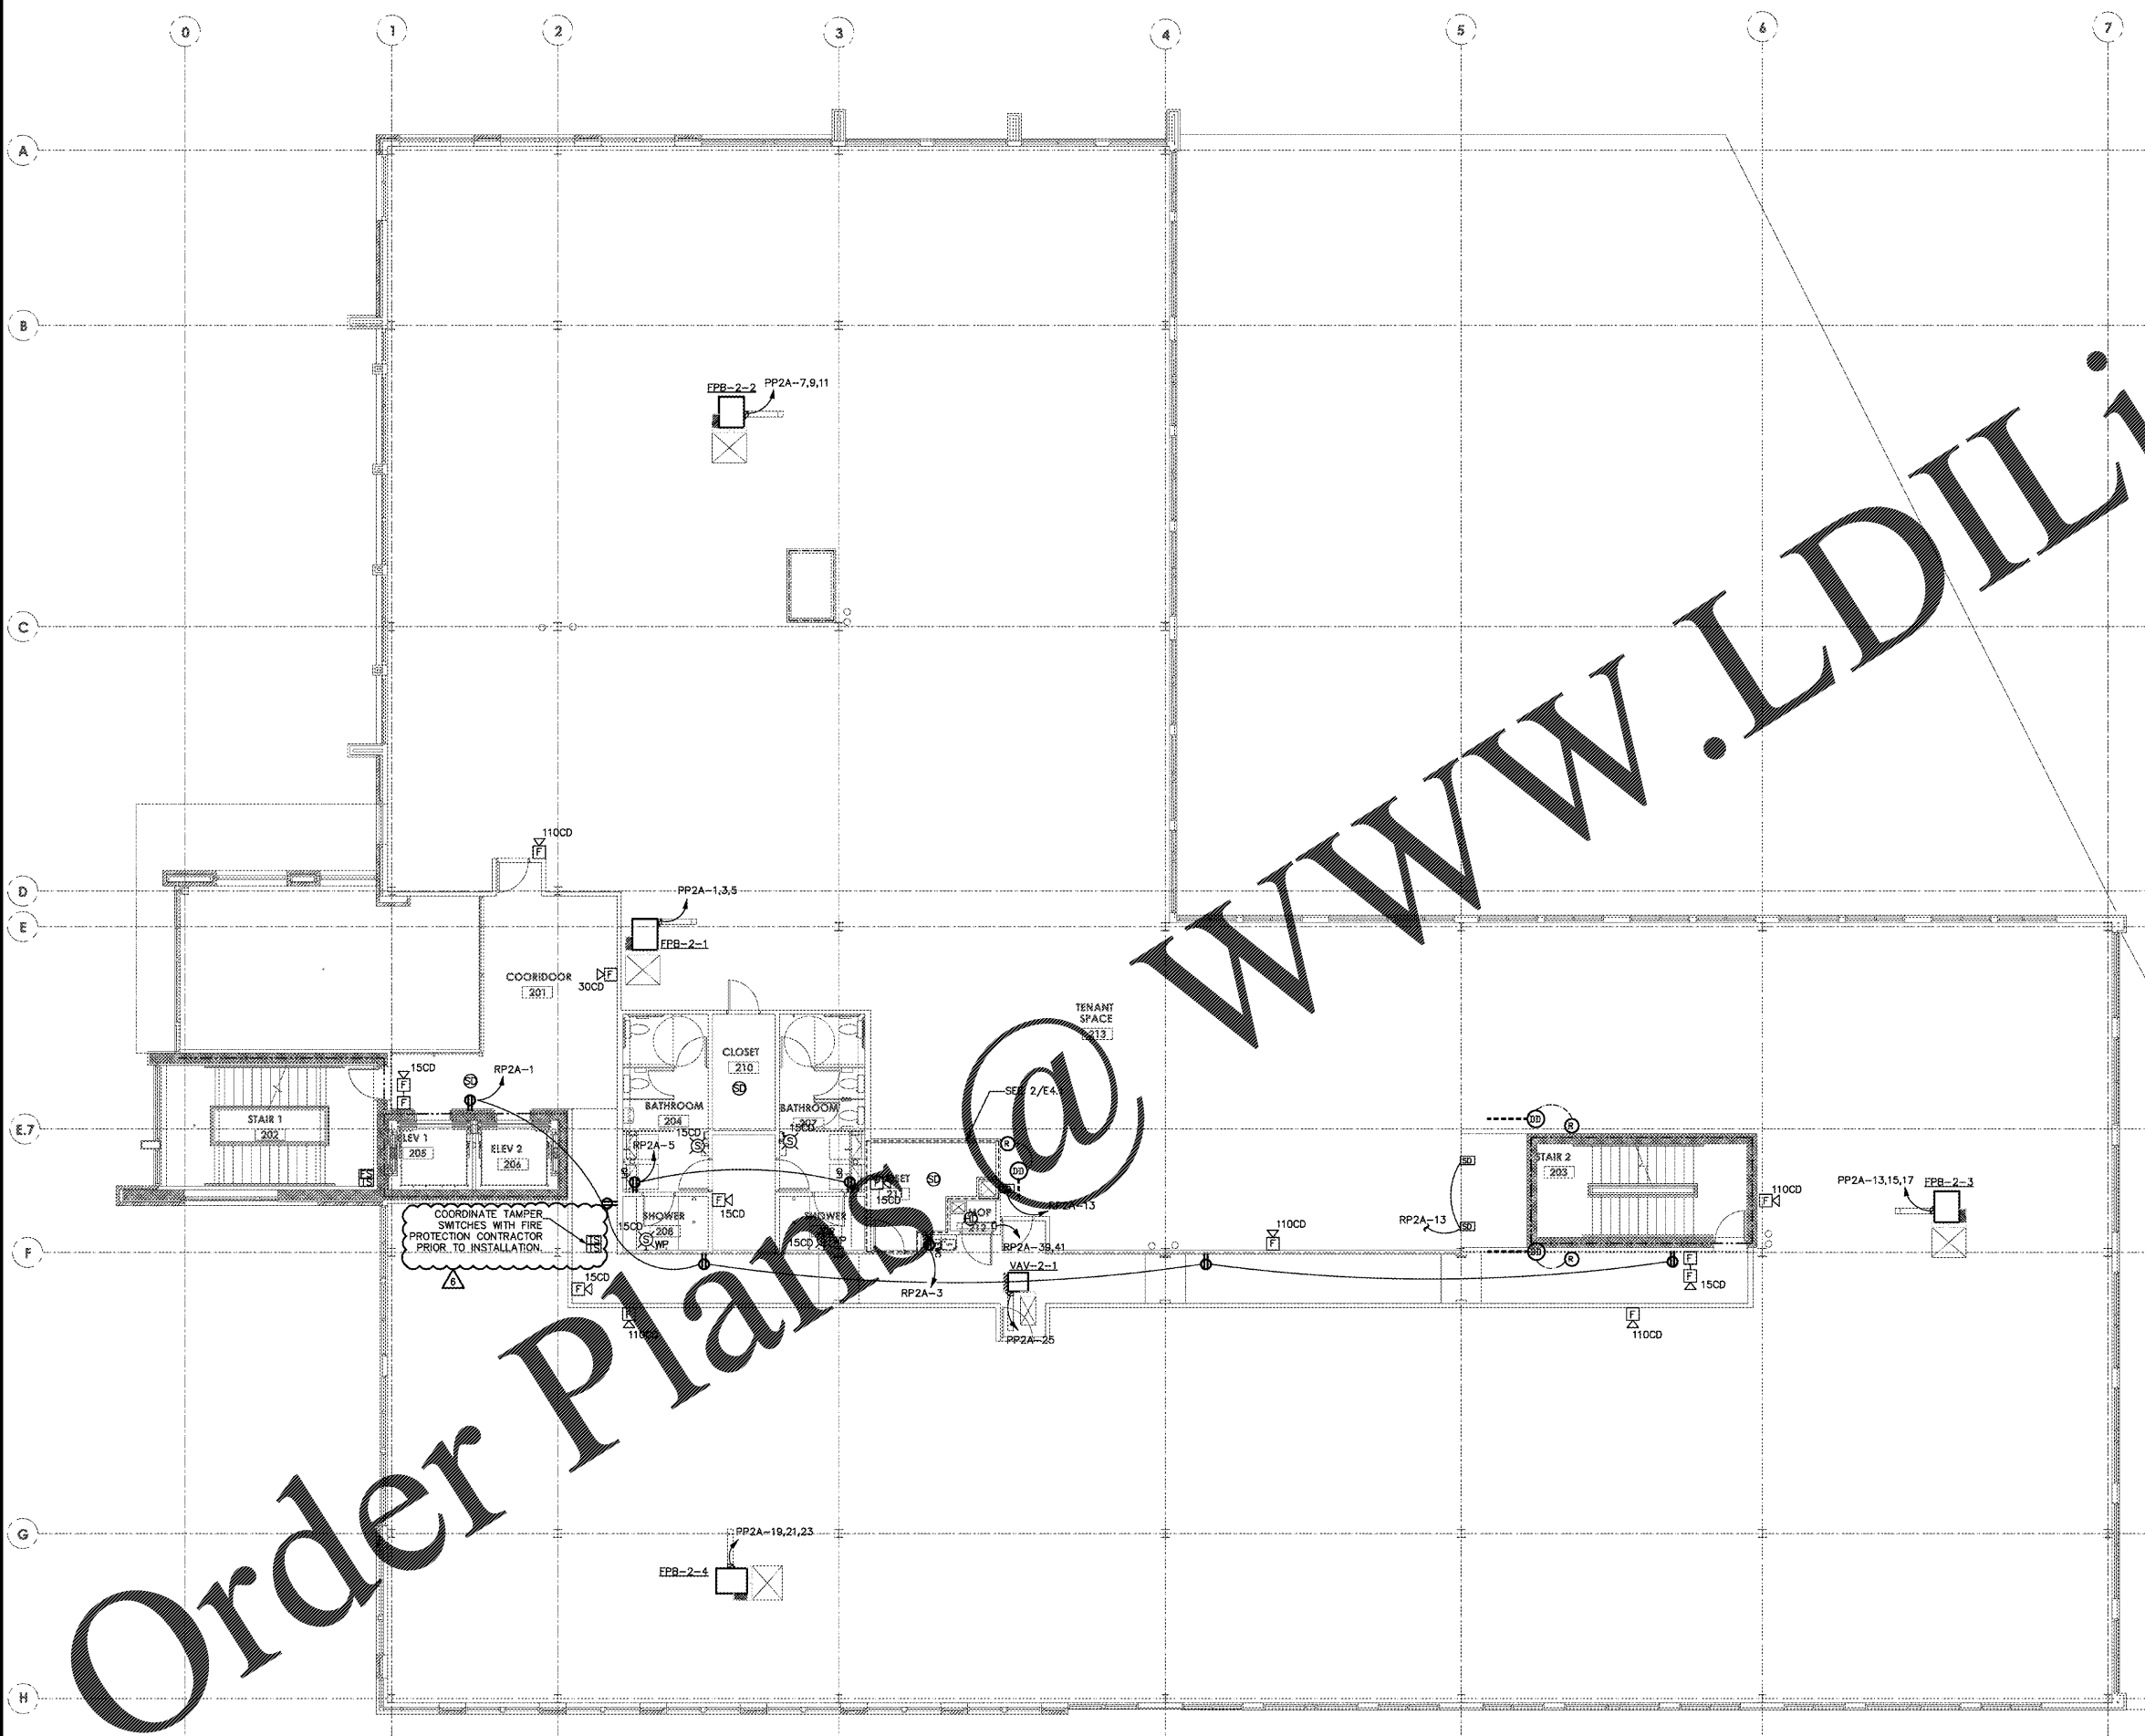

WWW.LDIDLine.com

Order Plans @

1 ELECTRICAL - SECOND FLOOR POWER PLAN
 1/8" = 1'-0"

REVISIONS

NO.	DATE	DESCRIPTION
1	2017-09-01	PERMIT COMMENTS

PROJECT: 1342
 DATE: 11/11/16
 DRAWN BY: ABA
 CHECKED BY: MDH

**ELECTRICAL
 SECOND FLOOR
 POWER PLAN**

E2.2
 17 OF 24