

**GENERAL NOTES:**

1. REFER TO SHEET E0.1 FOR SYMBOLS, ABBREVIATIONS AND GENERAL NOTES.
2. CONTRACTOR SHALL COORDINATE ALL ELECTRICAL DEVICE AND EQUIPMENT LOCATIONS WITH OTHER TRADES PRIOR TO INSTALLATION.
3. REFER TO MECHANICAL SCHEDULES SHEET E0.7 FOR DISCONNECT SIZES.



**FINLEY DESIGN PA**  
7806 NC HWY 751  
SUITE 110  
DURHAM, NC 27713  
P 919-493-8200  
F 919-493-8113  
FINLEYDESIGNARCH.COM



**WESTPOINT 2**  
**DURHAM, NC**


**REVISIONS**

NO.	DESCRIPTION

PROJECT: 1342  
DATE: 11/11/16  
DRAWN BY: ASA  
CHECKED BY: MDH

electrical  
fourth floor  
power plan

**E2.5**  
20 OF 24

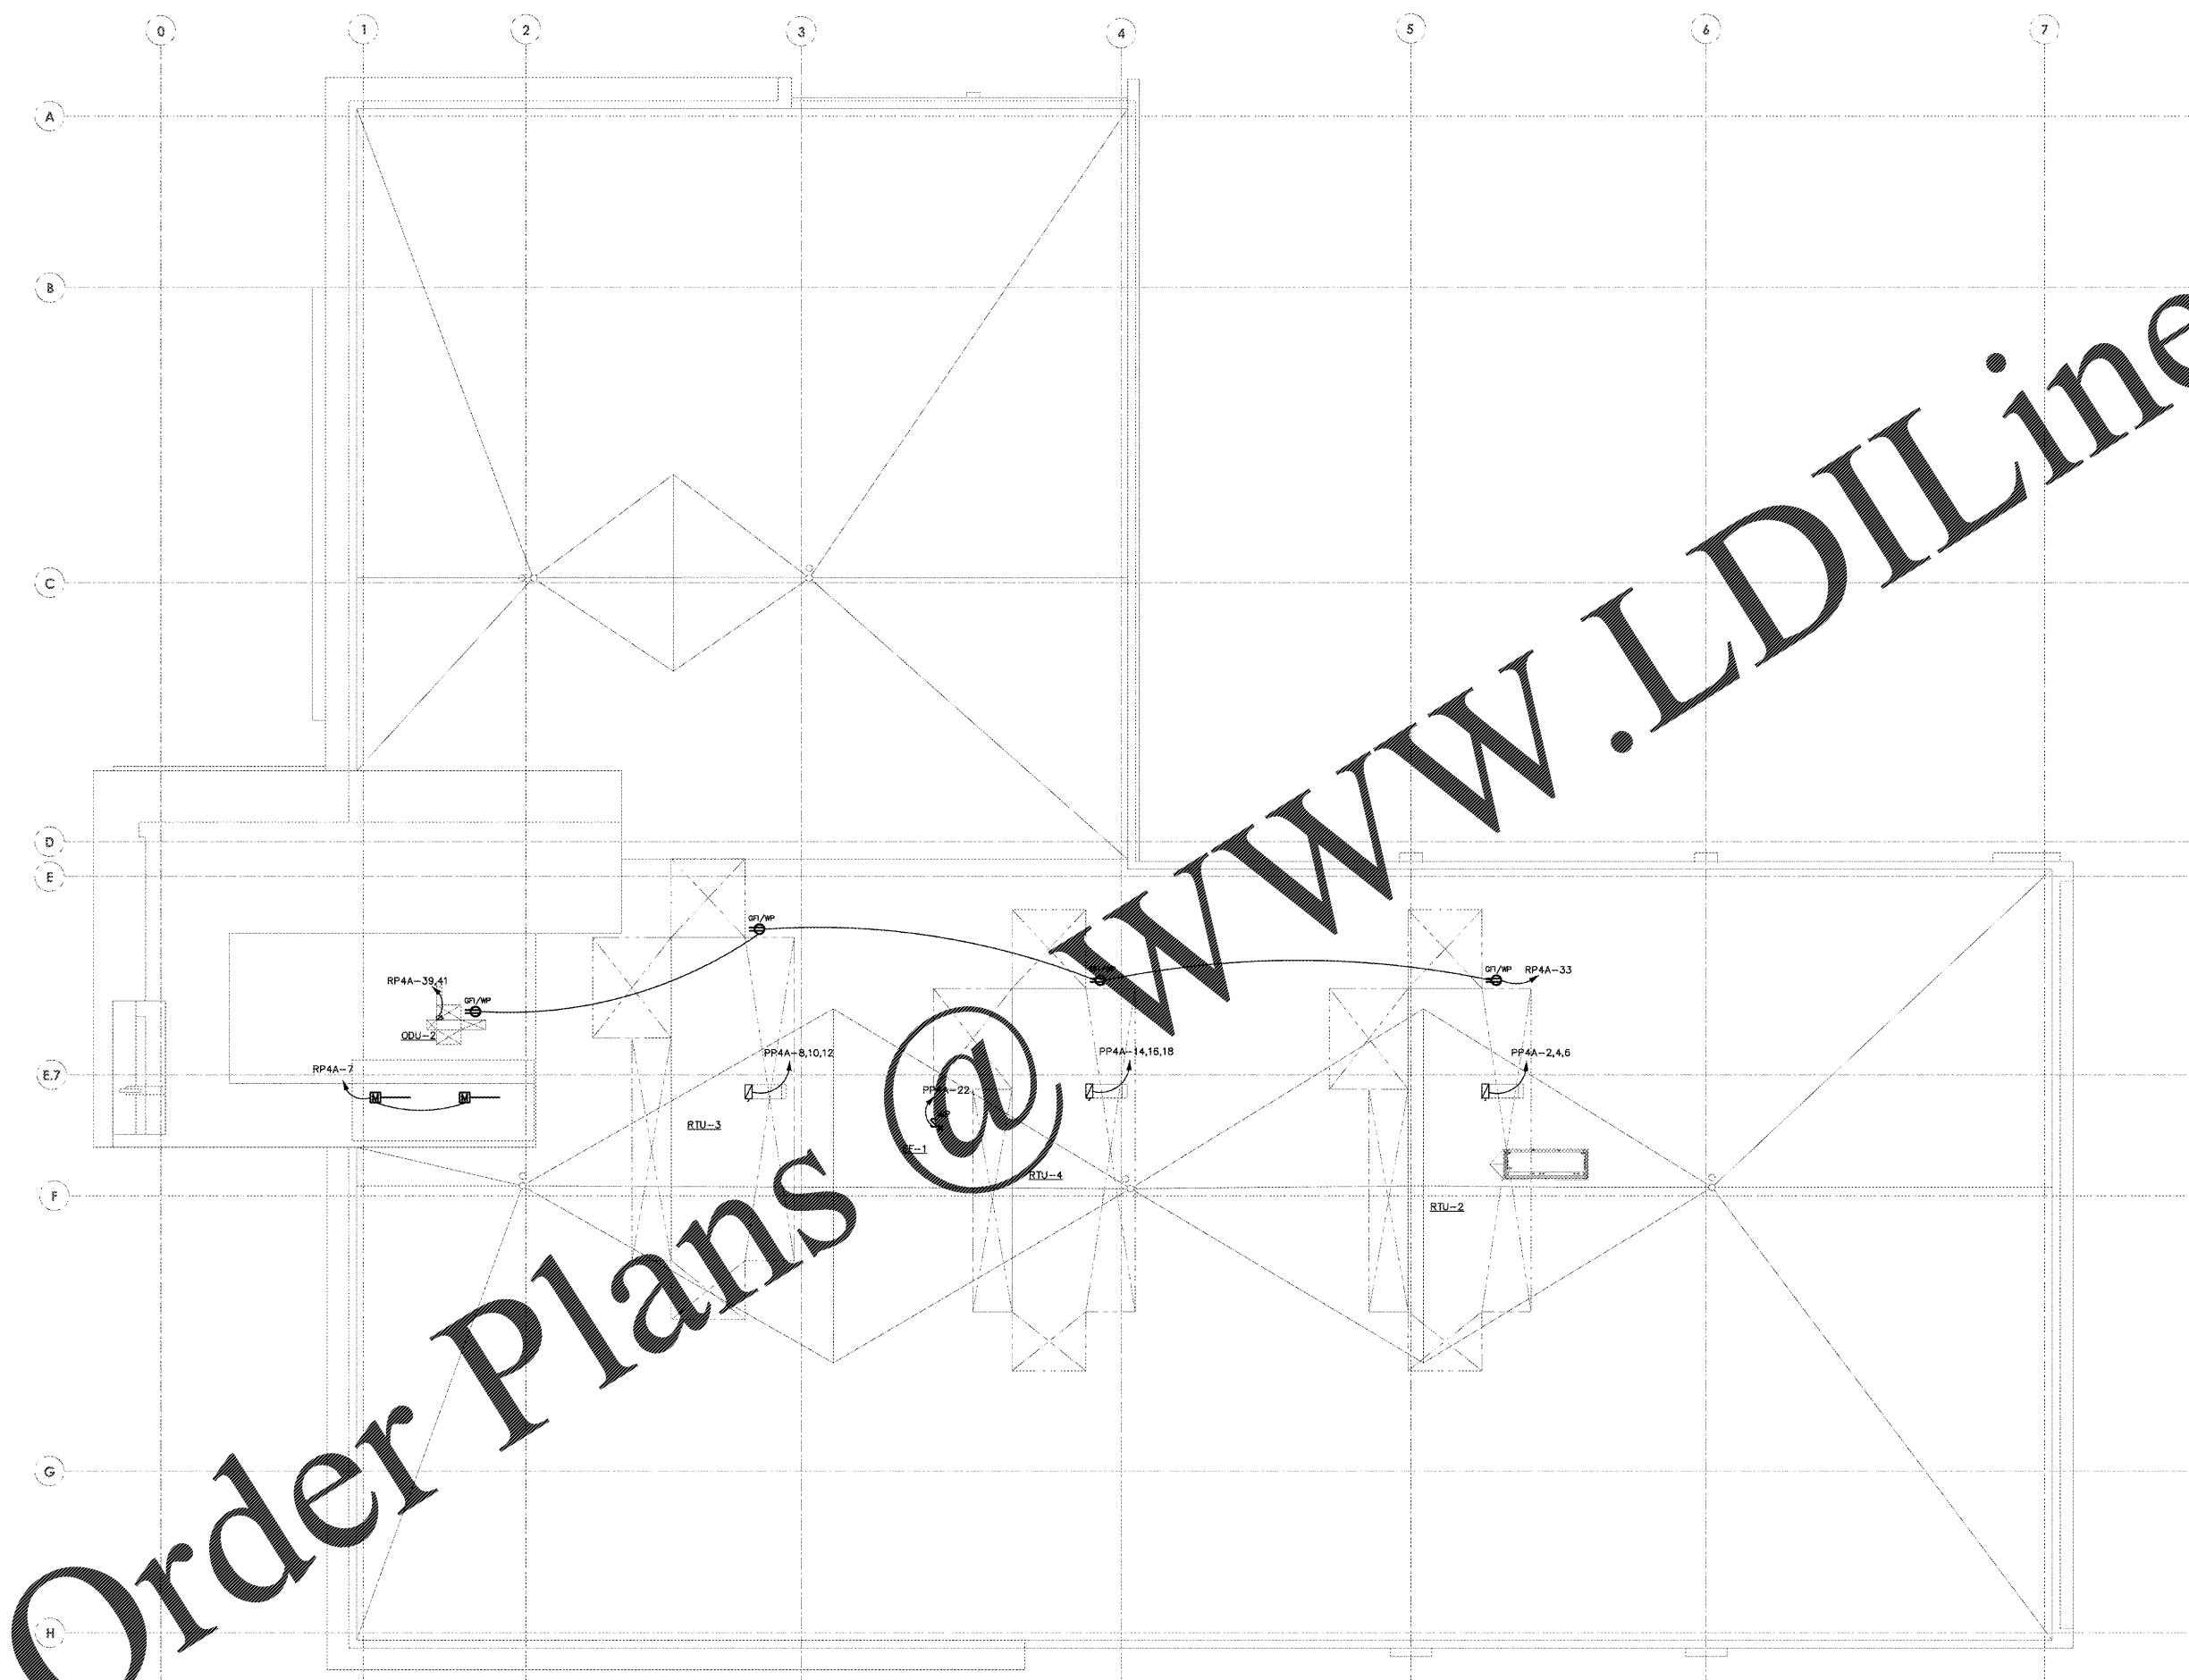

Order Plans @

**1 ELECTRICAL - ROOF POWER PLAN**  
1/8" = 1'-0"