

**WESTPOINT 2  
DURHAM, NC**


**REVISIONS**

2017-09-01	PERMIT COMMENTS

PROJECT:	1342
DATE:	11/1/16
DRAWN BY:	CCC
CHECKED BY:	GCF

**GROUND FLOOR  
FIRE PROTECTION**

**F1.0**  
2 OF 6  
OPTIMA # 16-0194

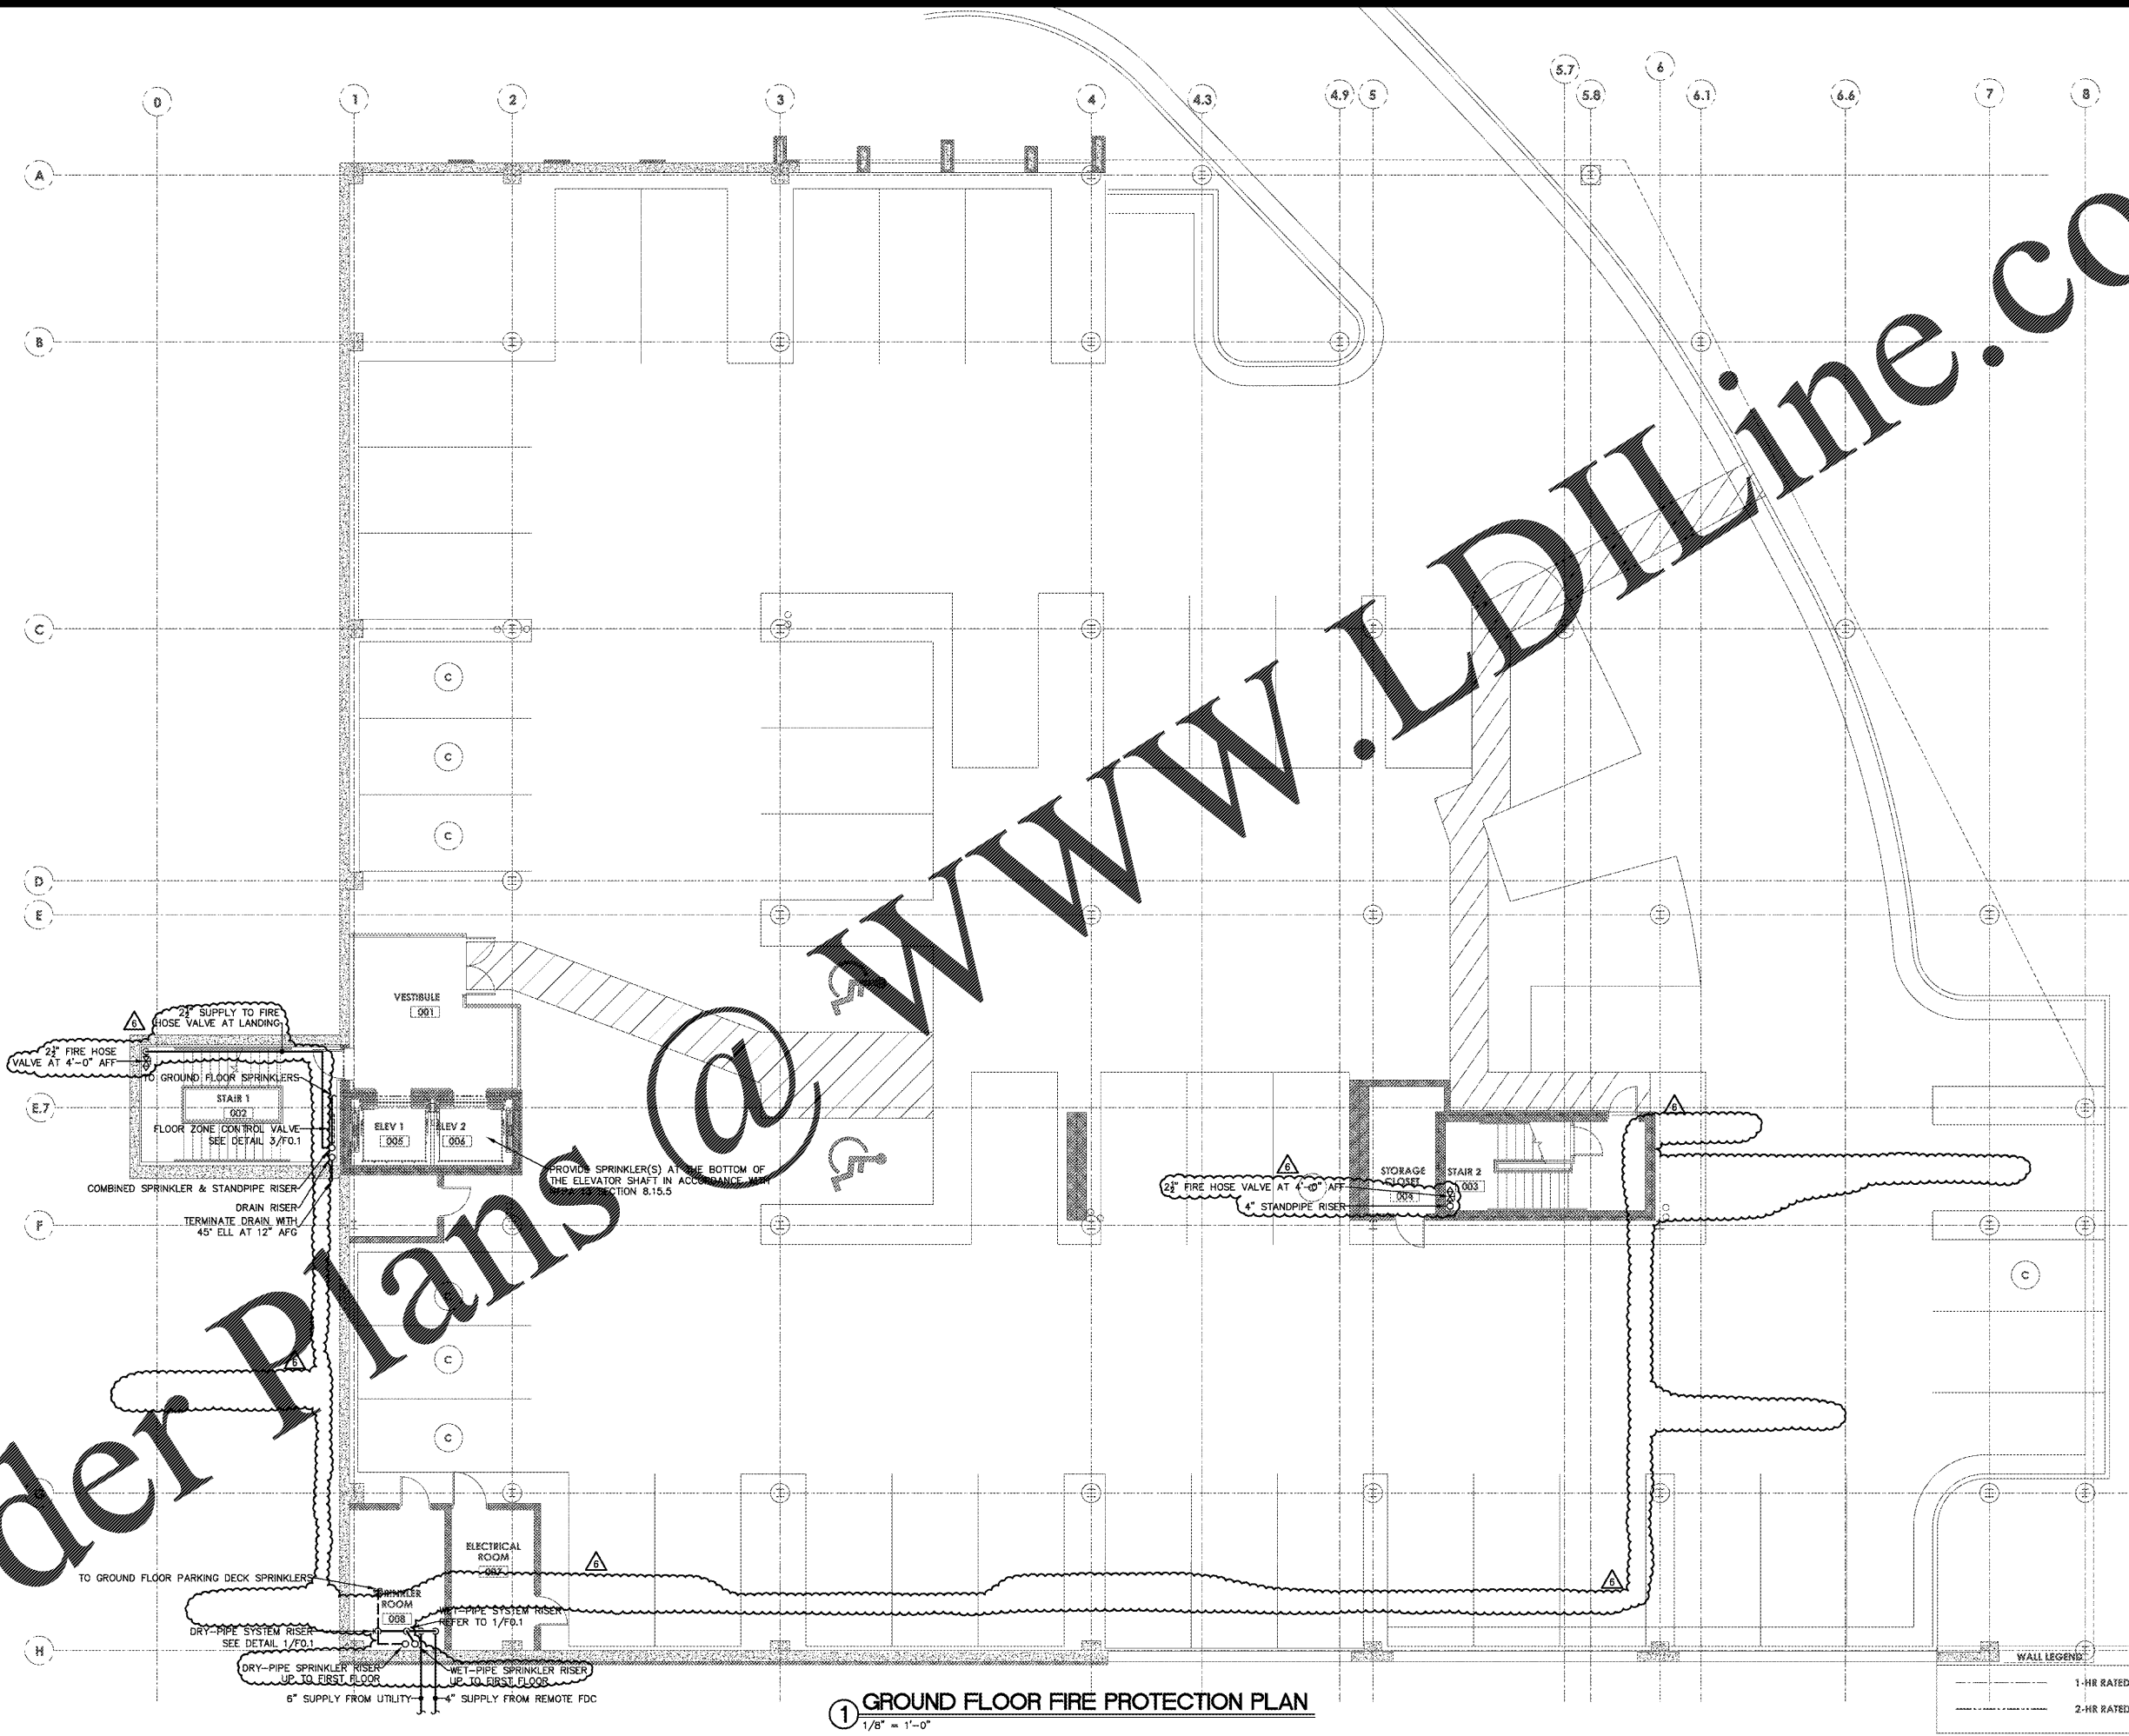

**1 GROUND FLOOR FIRE PROTECTION PLAN**  
1/8" = 1'-0"

Order Plans @ [WWW.LDOnline.com](http://WWW.LDOnline.com)