


**WESTPOINT 2  
DURHAM, NC**

REVISIONS

2017-09-01	PERMIT COMMENTS
------------	-----------------

PROJECT: 1342  
DATE: 11/1/16  
DRAWN BY: GCF  
CHECKED BY: GCF

**FIRST FLOOR  
FIRE PROTECTION**

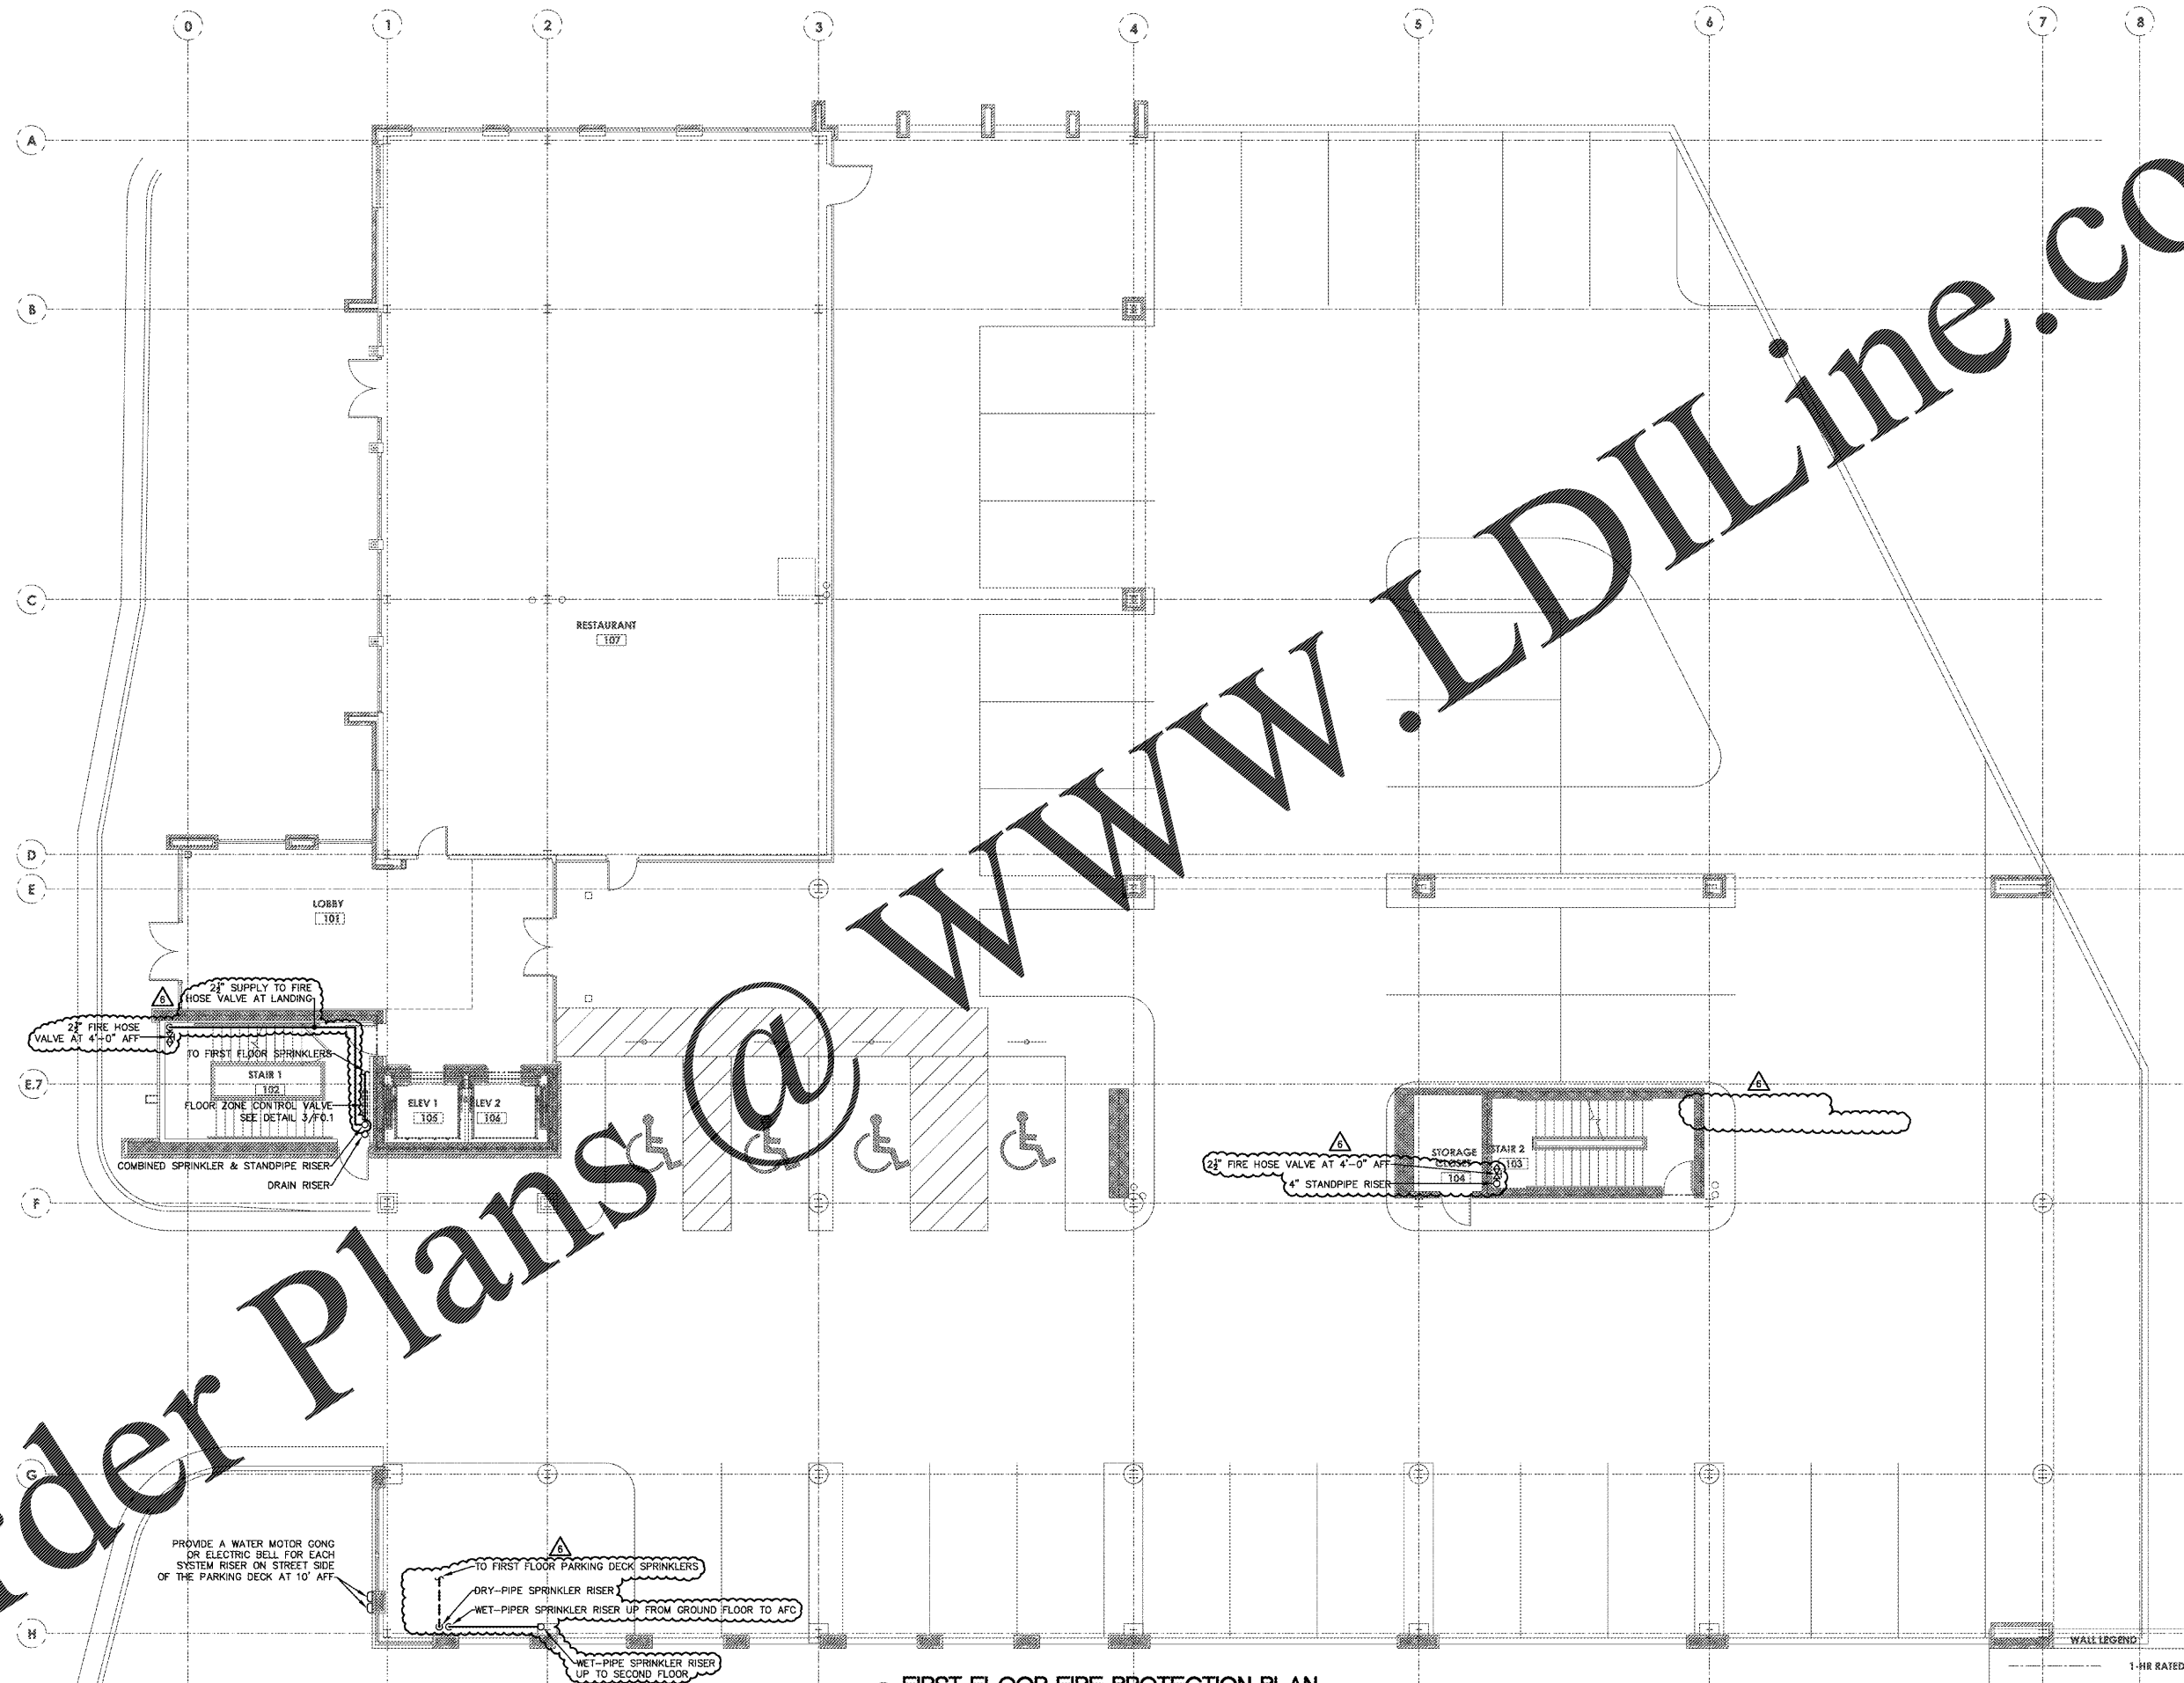

**1 FIRST FLOOR FIRE PROTECTION PLAN**  
1/8" = 1'-0"

WALL LEGEND

(Solid line)	1-HR RATED WALL
(Dashed line)	2-HR RATED WALL

**Order Plans @**

**WWW.LDILine.com**