

**WESTPOINT 2**  
**DURHAM, NC**


REVISIONS

2017-09-01	PERMIT COMMENTS

PROJECT: 1342  
DATE: 11/1/16  
DRAWN BY: GCF  
CHECKED BY: GCF

**SECOND FLOOR**  
**FIRE PROTECTION**

**F1.2**  
4 OF 6

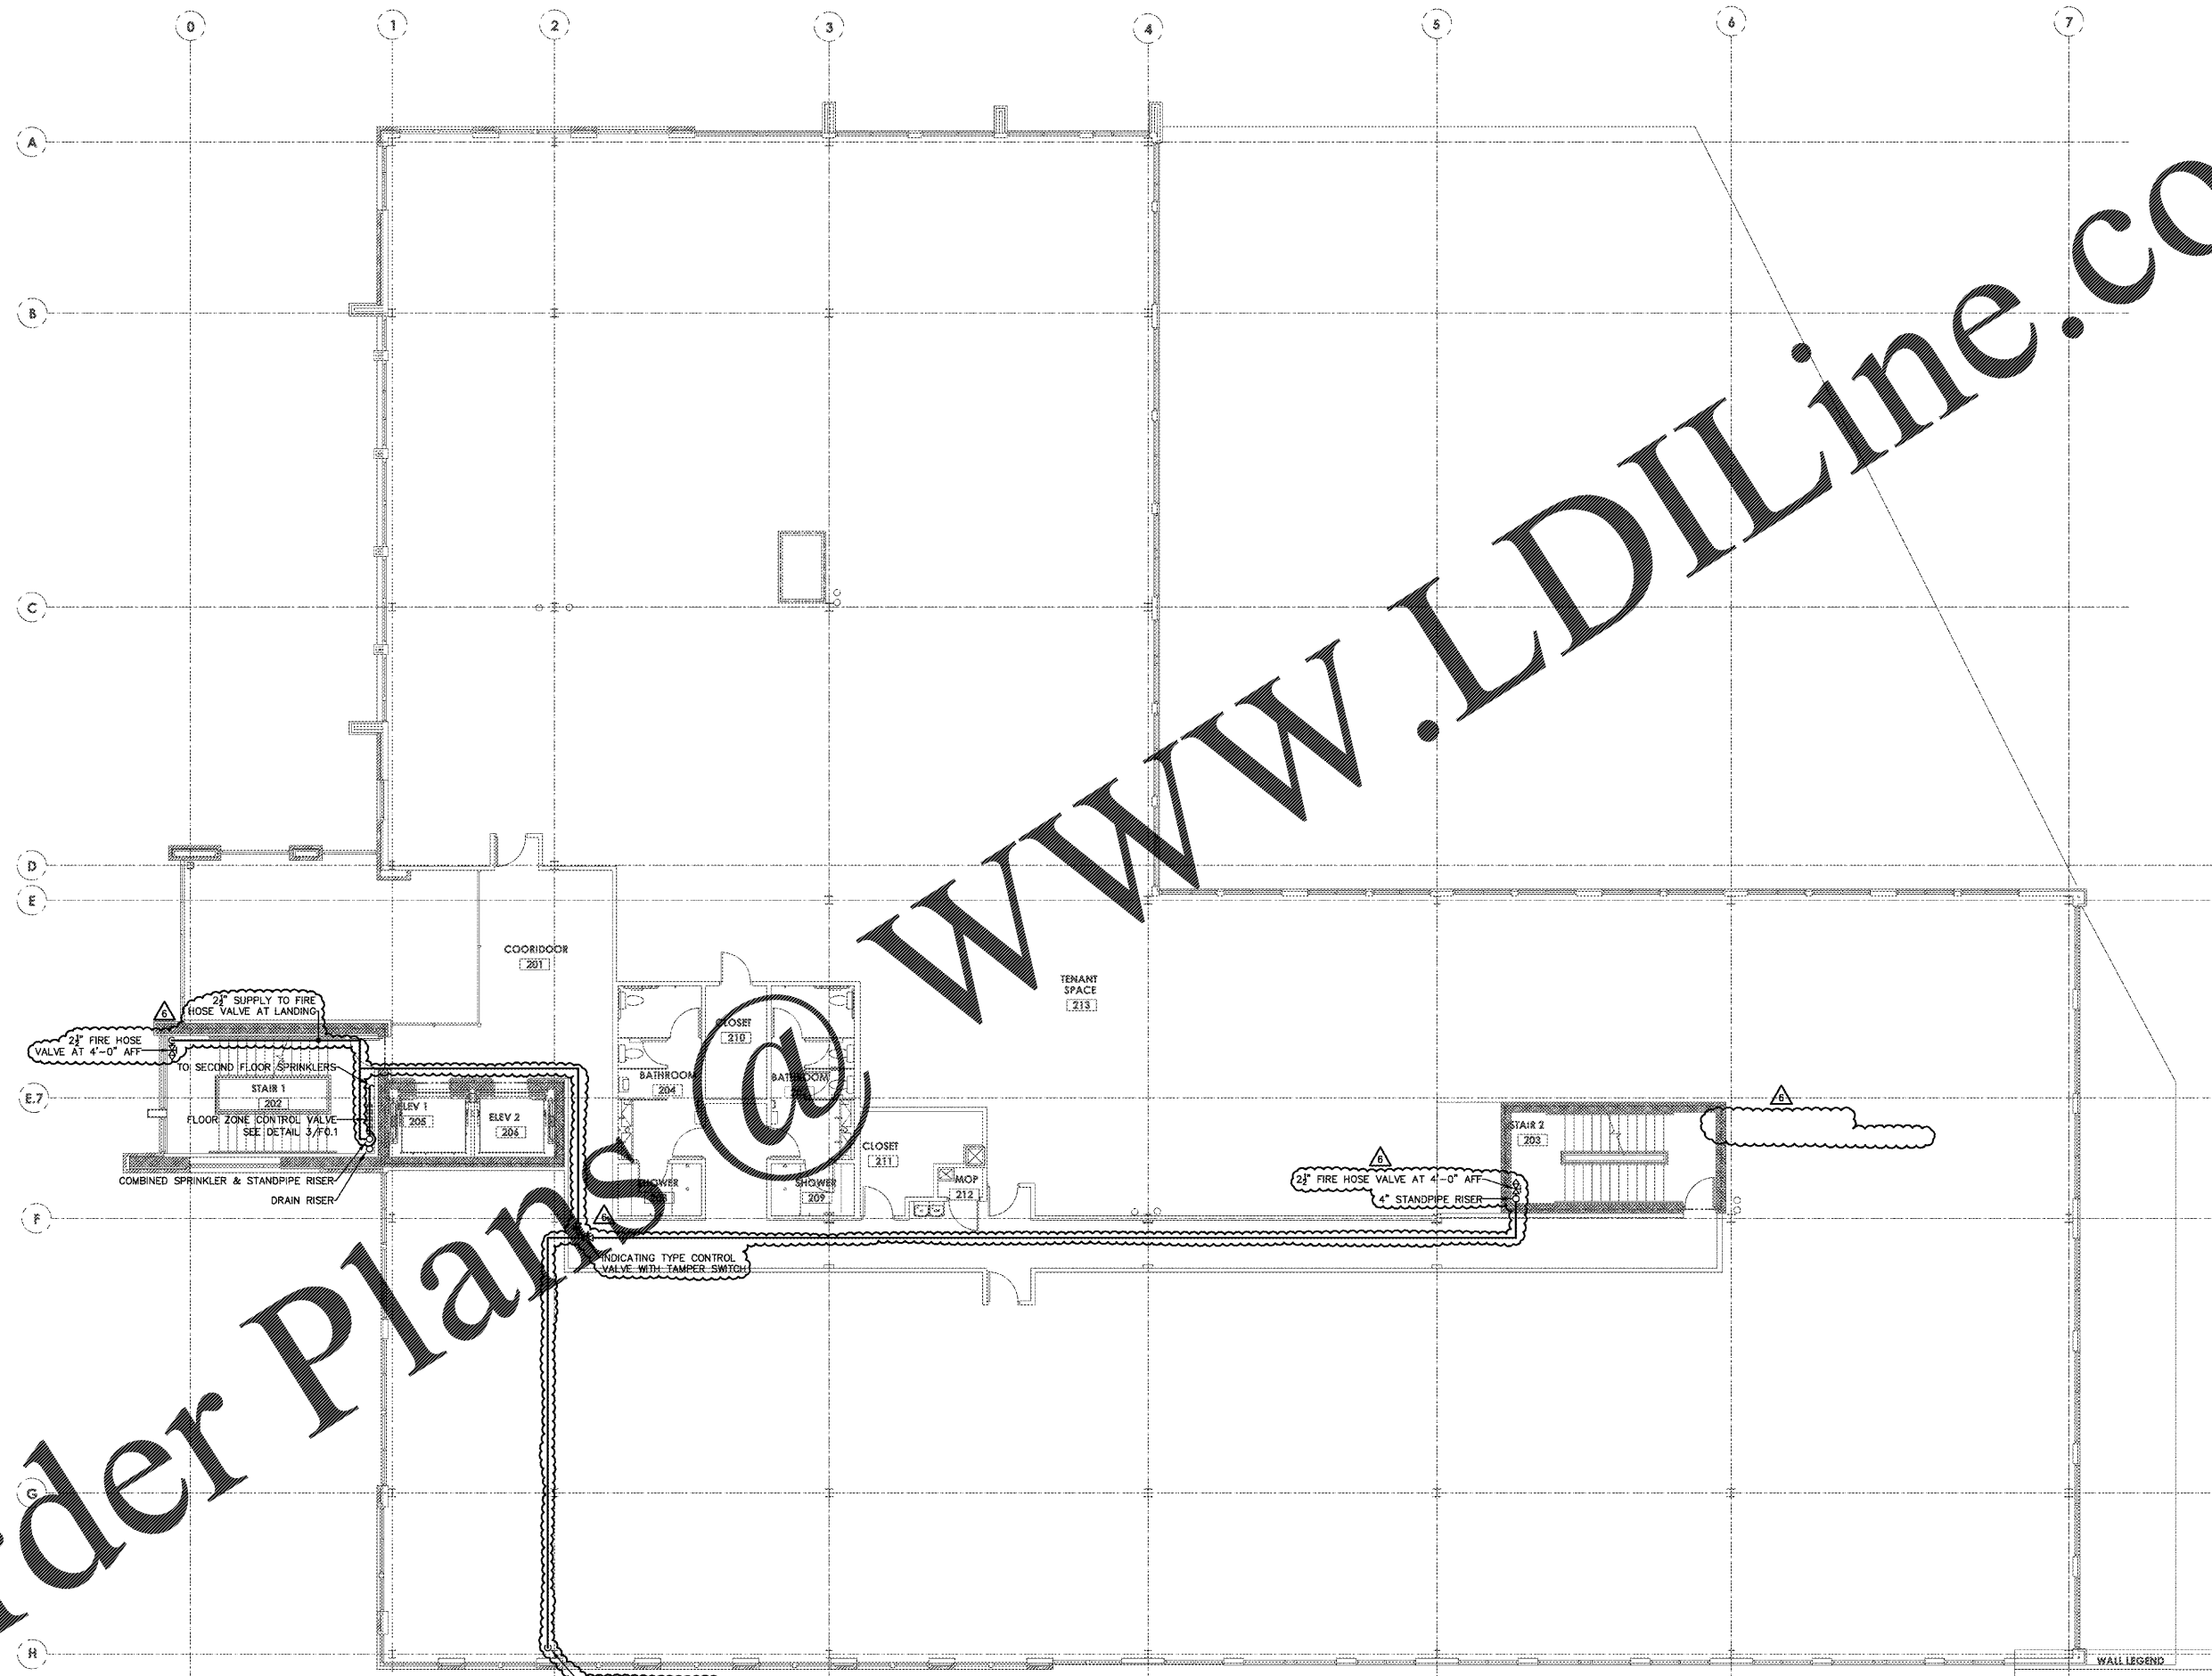

**1 SECOND FLOOR FIRE PROTECTION PLAN**  
1/8" = 1'-0"

WALL LEGEND

---	1-HR RATED WALL
---	2-HR RATED WALL

Order Plans @

WWW.LDILine.com