

**WESTPOINT 2  
DURHAM, NC**


REVISIONS

2017-09-01	PERMIT COMMENTS

PROJECT: 1342  
DATE: 11/1/16  
DRAWN BY: GCF  
CHECKED BY: GCF

**THIRD FLOOR  
FIRE PROTECTION**

**F1.3**  
5 OF 6

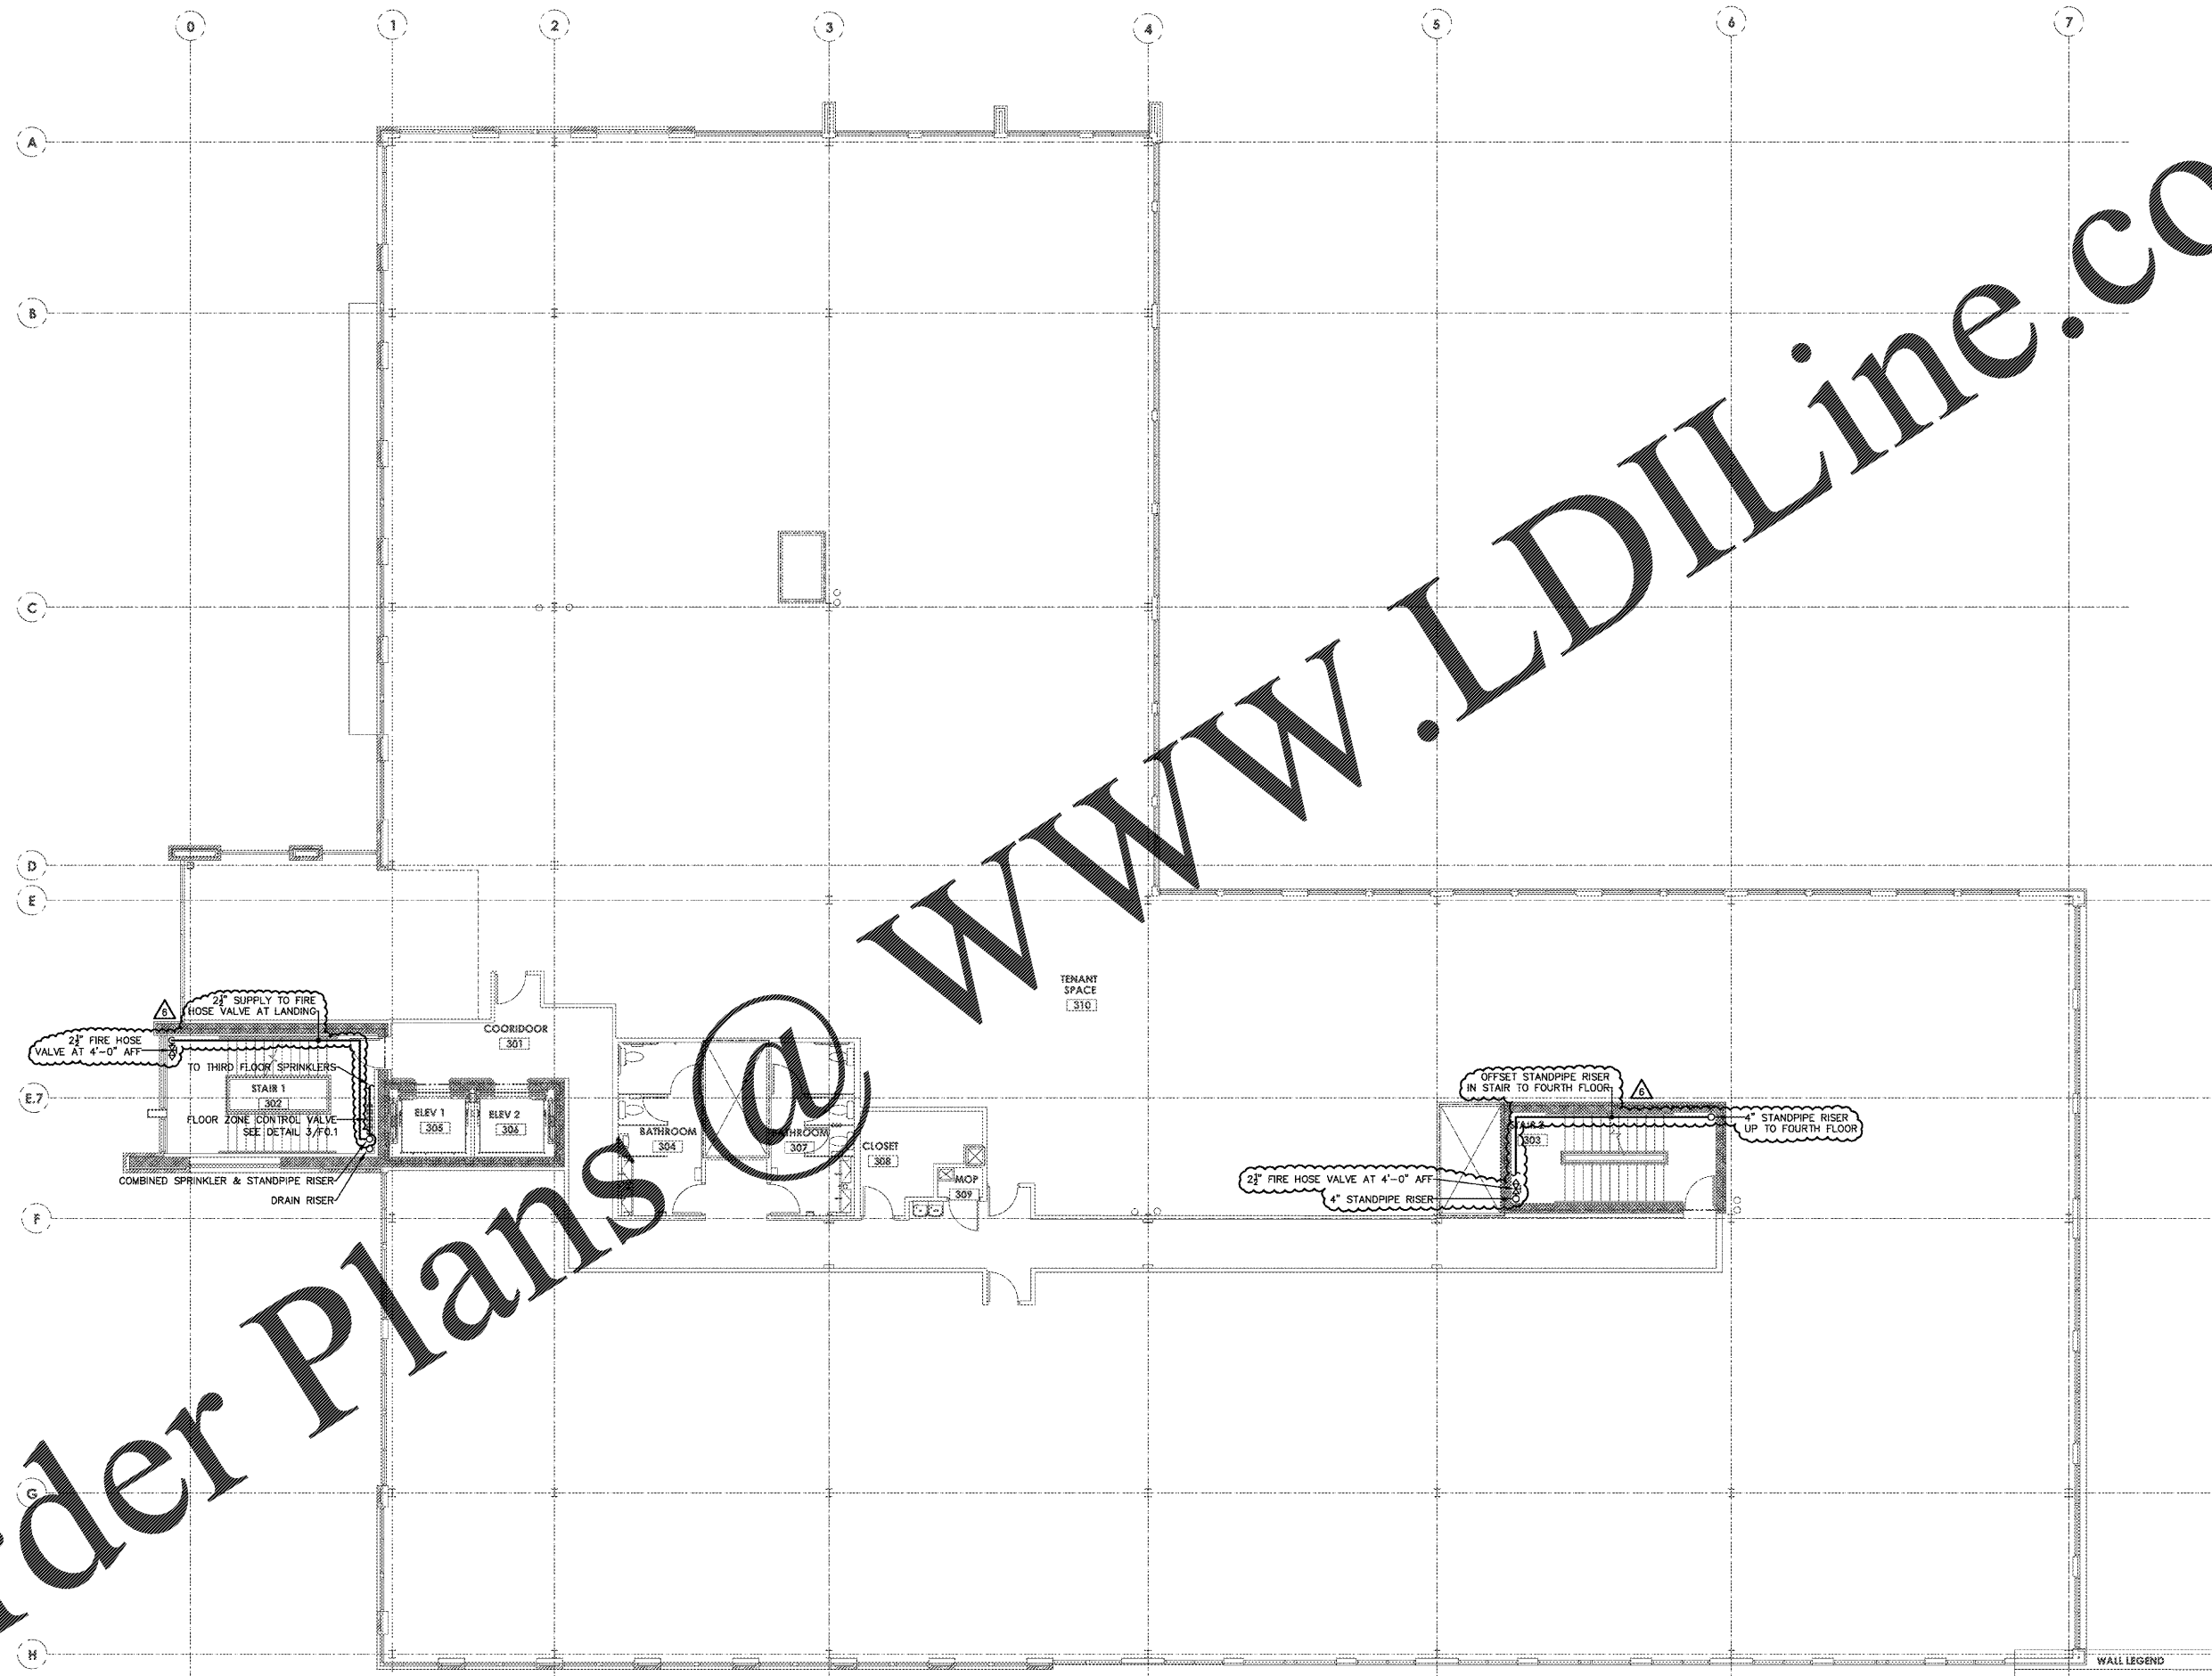

**1 THIRD FLOOR FIRE PROTECTION PLAN**  
1/8" = 1'-0"

Order Plans @ [www.LDILine.com](http://www.LDILine.com)