

**WESTPOINT 2
DURHAM, NC**


REVISIONS

△	2017-09-01	PERMIT COMMENTS

PROJECT: 1342
DATE: 11/1/16
DRAWN BY: CCC
CHECKED BY: GCF

**FOURTH FLOOR
FIRE PROTECTION**

F1.4
6 OF 6

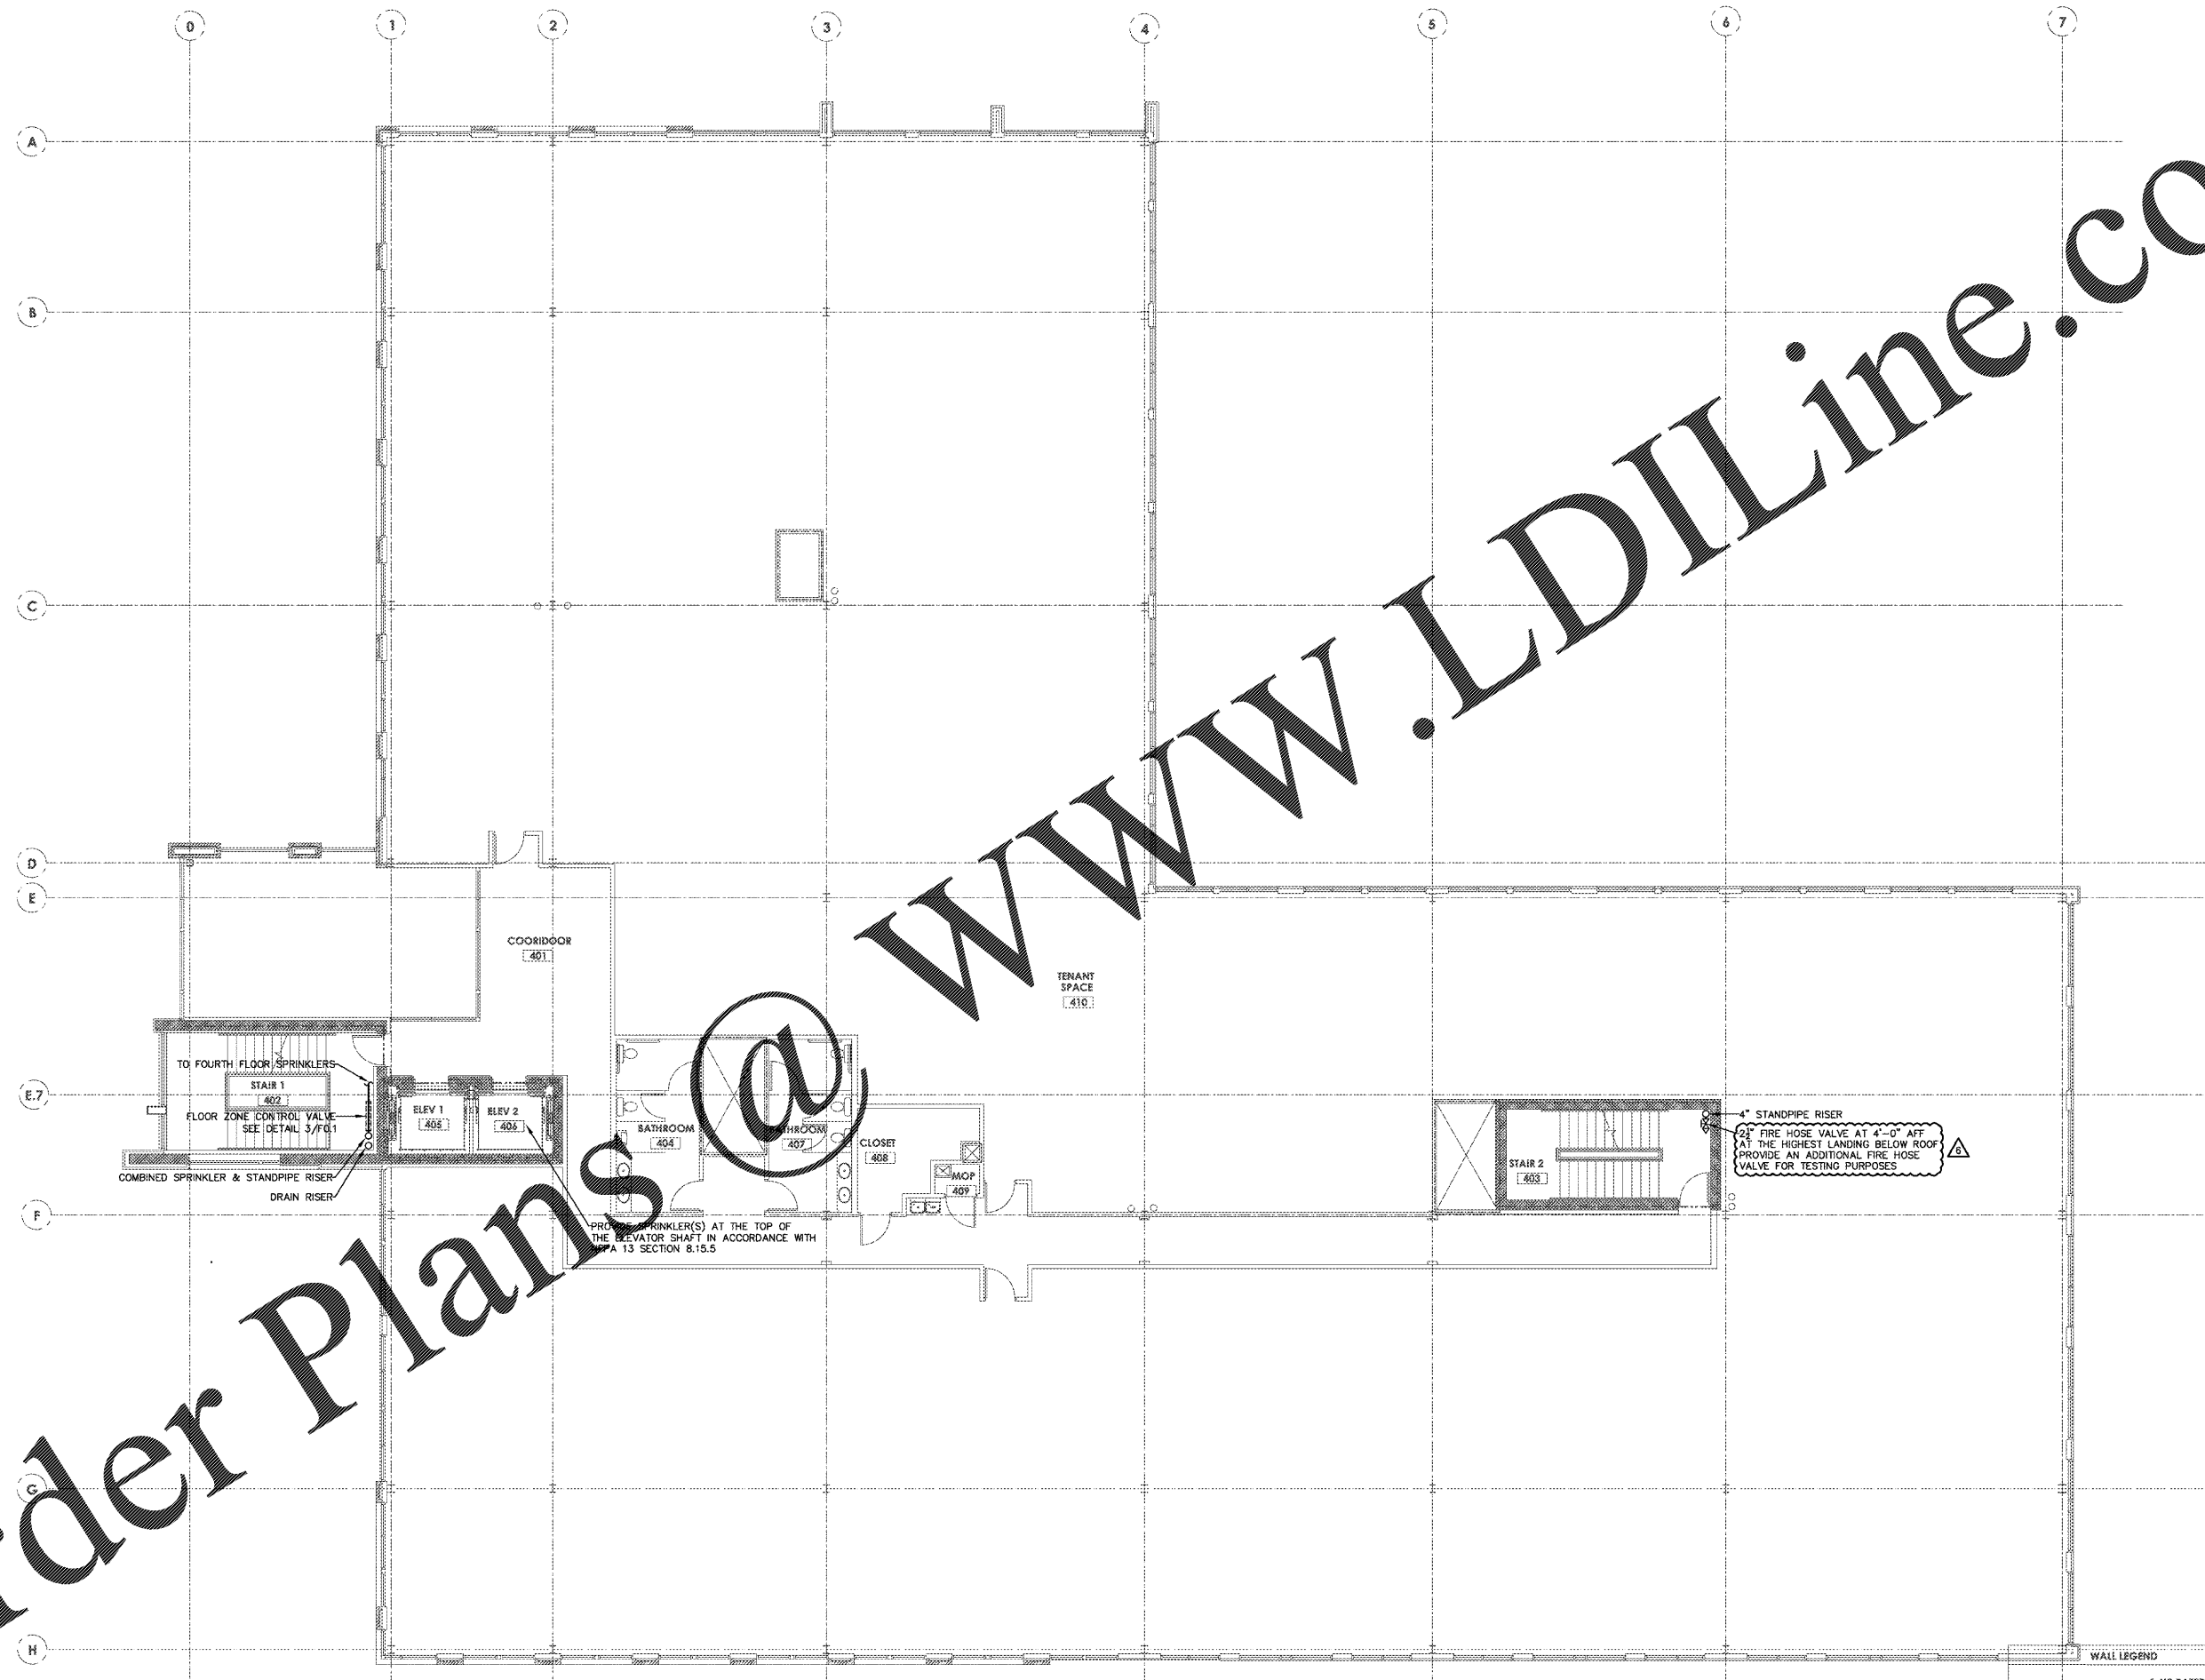

1 FOURTH FLOOR FIRE PROTECTION PLAN
1/8" = 1'-0"

WALL LEGEND

---	1-HR RATED WALL
---	2-HR RATED WALL

Order Plans @ www.LDILine.com