



ECP LABELING
 LABEL EACH ECP PER O'REILLY TERMINOLOGY WITH EXACTLY THE SAME UNIQUE IDENTIFYING "CODE" AS SHOWN ON THE "HVAC PLAN" ON SHEET M1 (FOR EXAMPLE: RTU-1, RTU-2, ETC... OR FURN-1, FURN-2, ETC...)

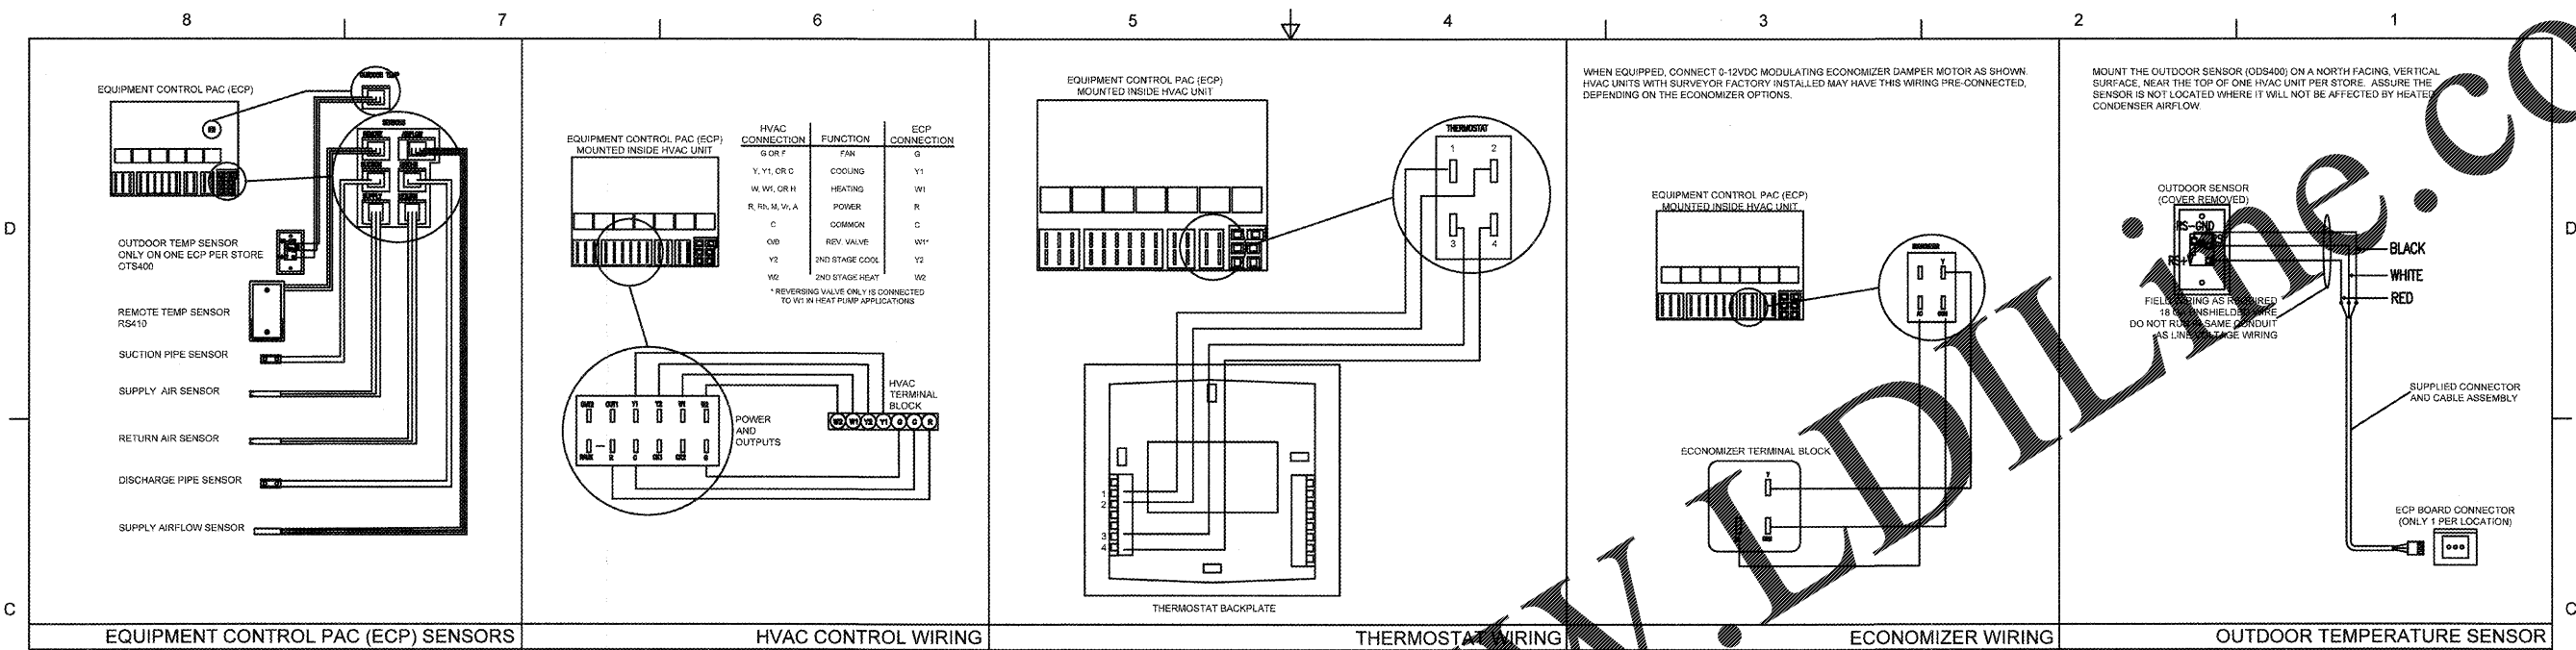

REVISIONS:

O'Reilly AUTO PARTS

CORPORATE OFFICES
 233 SOUTH PATTERSON
 SPRINGFIELD, MISSOURI 65802
 417-882-2674 PHONE

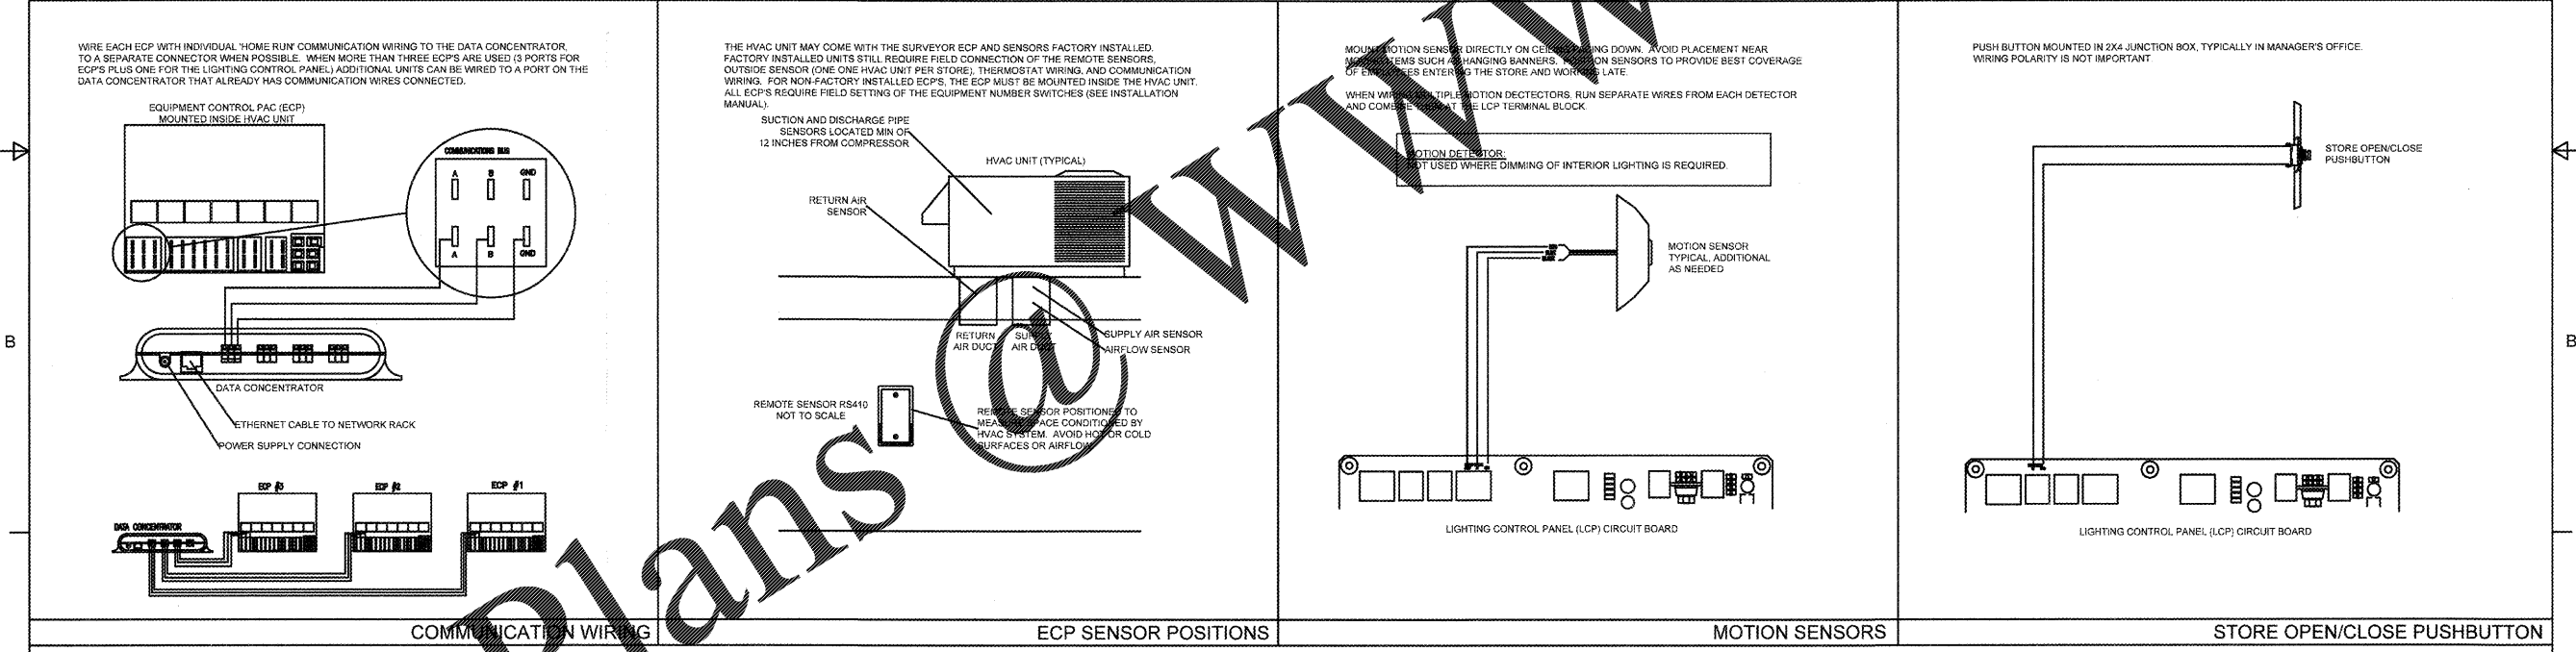

GENERAL NOTES:

- DRAWING FOR GENERAL INFORMATION ONLY.
- LOCAL BUILDING CODES AND BUILDING PLANS AND STORE TAKE PRECEDENCE OVER THIS DOCUMENT.
- REFER TO THE SURVEYOR MANUAL AND INSTALLATION INSTRUCTIONS FOR EACH COMPONENT FOR ADDITIONAL CRITICAL INFORMATION.
- SOME HVAC UNITS ARE AVAILABLE WITH THE SURVEYOR ECP AND SENSORS PRE-INSTALLED. THE REMOTE SENSOR AND OUTSIDE SENSOR PER STORE WILL NEED TO BE CONNECTED BY THE FIELD TO THE ECP.
- ALL ECPs REQUIRE SETTING OF THE EQUIPMENT NUMBER DIP SWITCHES, AND HEAT PUMP NUMBERS AS APPROPRIATE. REFER TO THE EQUIPMENT CONTROL PAC INSTALLATION INSTRUCTIONS FOR FURTHER INFORMATION.
- ALL WIRING IS TO BE UNBUNDLED, OR TWISTED PAIR.
- WIRING MAY BE RUN IN CONDUIT OR WIRE TIED IN BUNDLES.
- DO NOT RUN COMMUNICATION AND SENSOR WIRES IN THE SAME CONDUIT OR BUNDLE WITH CONTROL AND LINE VOLTAGE WIRING.
- CAUTION! INSTALLATION REQUIRES REMOVAL OF SAFETY COVERS AND EXPOSE THE INSTALLER TO ELECTRICAL HAZARDS. USE OF A LICENSED ELECTRICIAN IS REQUIRED. FOLLOW ALL APPROPRIATE SAFETY PRECAUTIONS. ADDITIONAL SAFETY INFORMATION IS IN THE SURVEYOR INSTALLATION MANUALS.

VENSTAR INC.			
SURVEYOR			
O'REILLY INSTALLATION DETAILS			
DATE	9-13-13	DWG NO	S13-002
SCALE	NONE	DRAWN	C. GODWIN
SHEET	1 OF 1	REV	-

PROJECT:
RE-MODEL O'REILLY AUTO PARTS STORE
 523 NORTH MILITARY STREET
 LORETTO, TN 38469
ENERGY SYSTEM

FOR REFERENCE ONLY

Professional of Record

DRAWN:
 CHECKED:
 DATE: 2-15-2018
 JOB NO.: 319287 (LTO)
 SHEET:

VS2