



PUCCIANO & ENGLISH, INC.
ARCHITECTS, AIA
 3084 MERCER UNIVERSITY DRIVE, SUITE 110
 ATLANTA, GA 30341
 PH 770-457-0623, FAX 770-451-0092
 web@pucciano-english.com



JOB No: 1701
 DRAWN BY: RK
 CHECK BY: RK
 JOB PROGRESS:
 ITEM DATE
 PRICING SET 07-14-2017
 PERMIT SET 02-26-2018


REVISIONS:
 DATE NO.

This drawing, as an instrument of service, is and shall remain the property of the architect and shall not be reproduced, published or used in any way without the permission of the architect.


Legacy at Jones Farm Phase 2
 HUNTSVILLE, ALABAMA
 AN APARTMENT COMMUNITY FOR
RBJ BAILEY, LLC

PLUMBING
 UNIT PLANS
 SHEET NO.


P-1

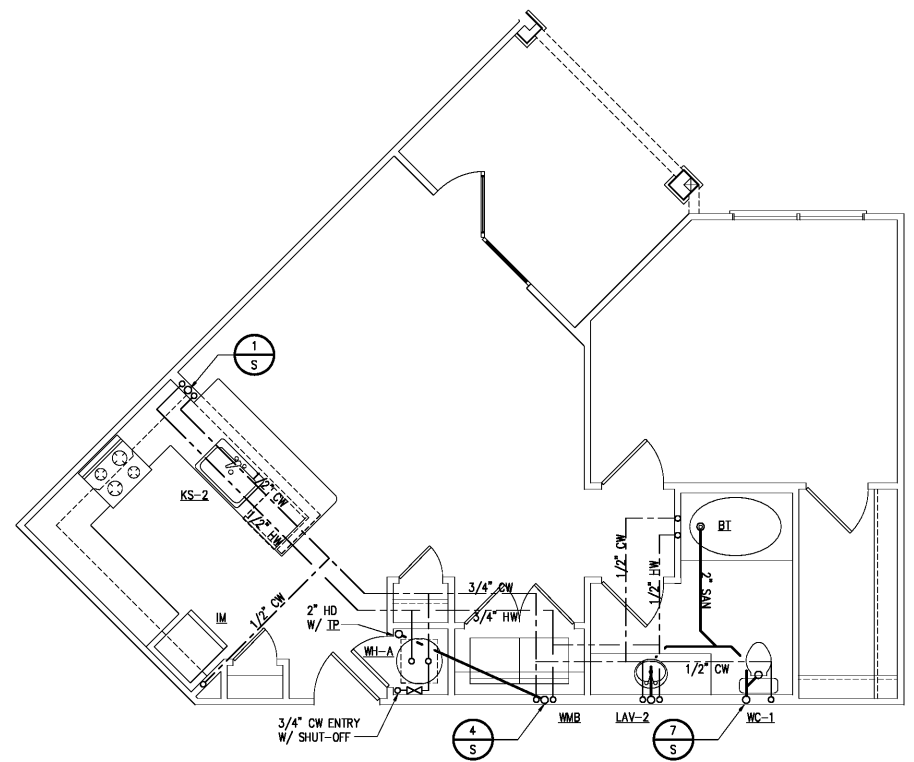


UNIT A3 FLOOR PLAN
 P-1 1/4" = 1'-0"

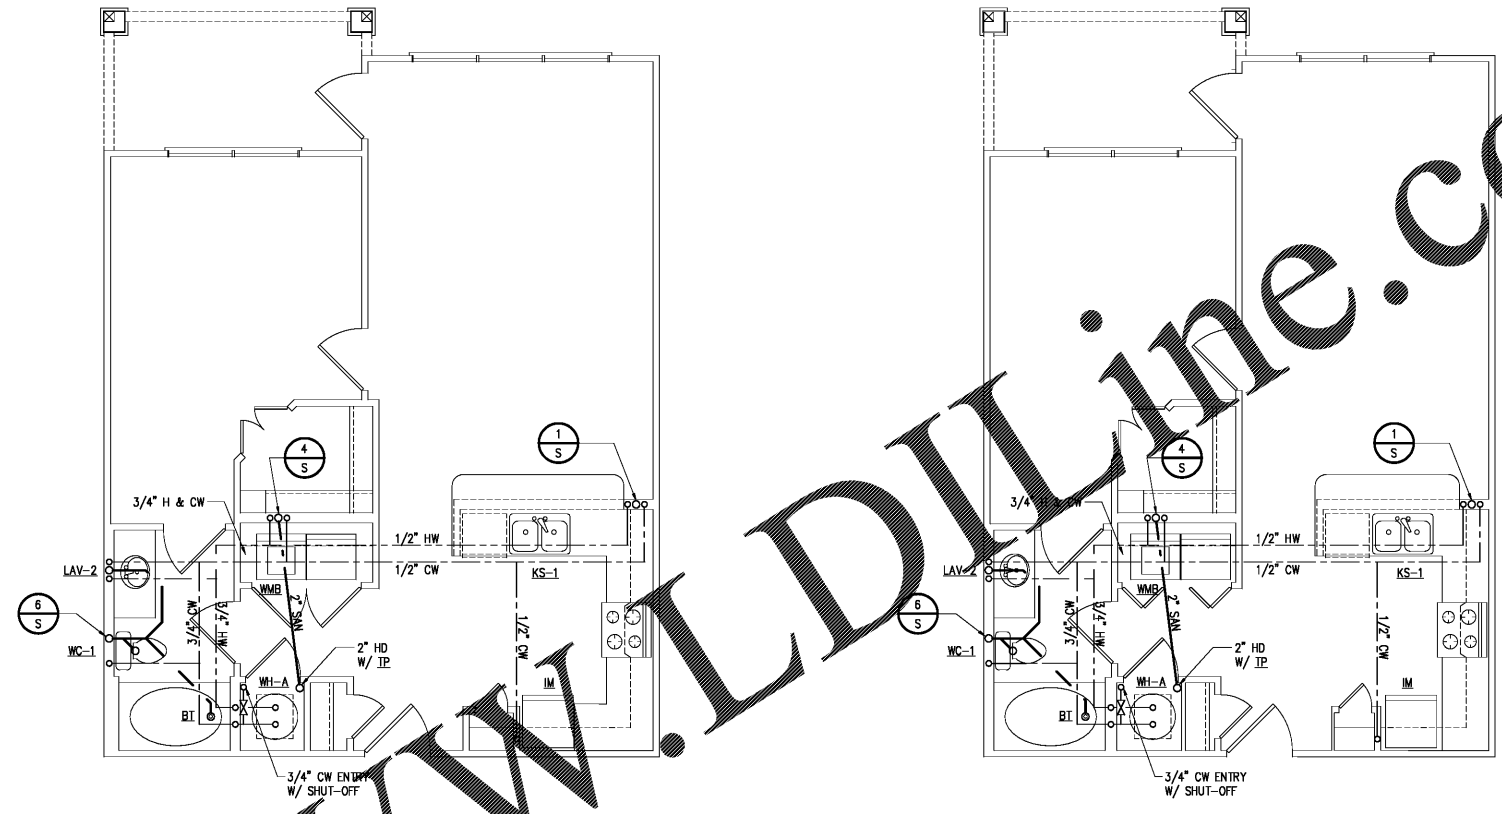


UNIT A2 FLOOR PLAN
 P-1 1/4" = 1'-0"

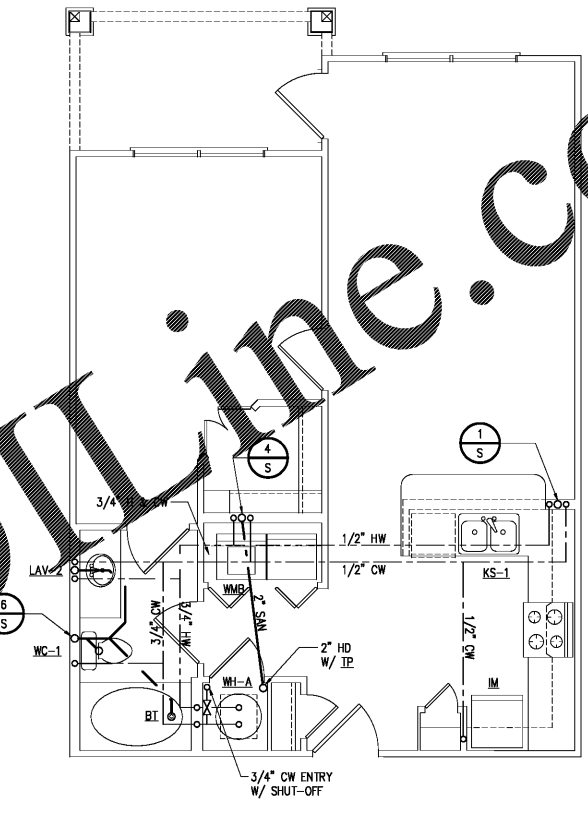

UNIT A1 FLOOR PLAN
 P-1 1/4" = 1'-0"

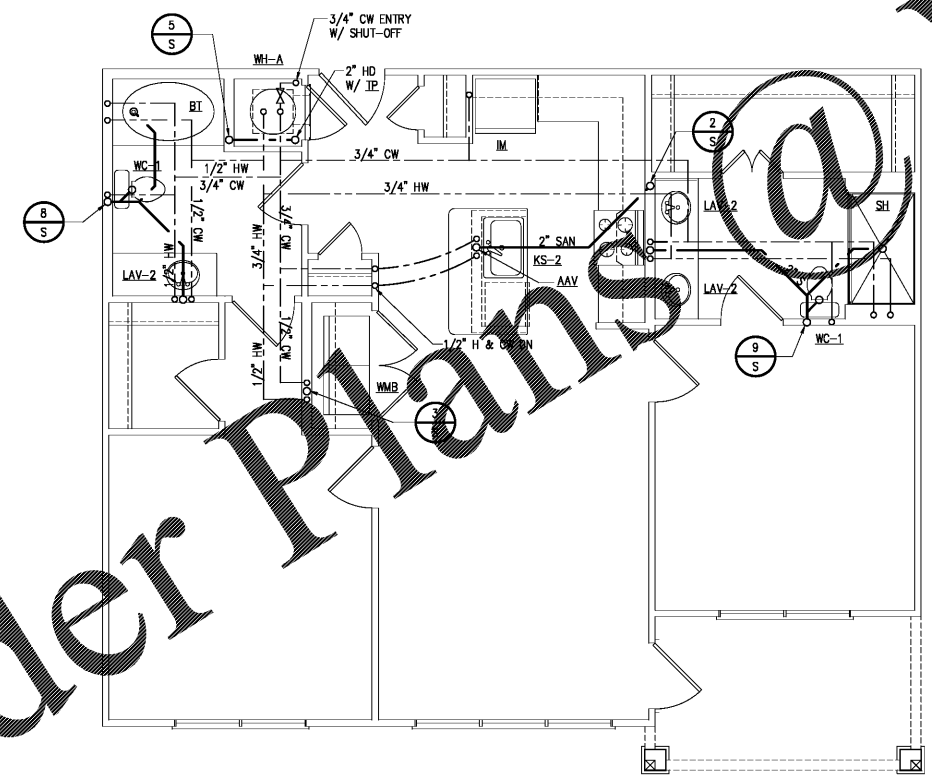

UNIT B1 FLOOR PLAN
 P-1 1/4" = 1'-0"

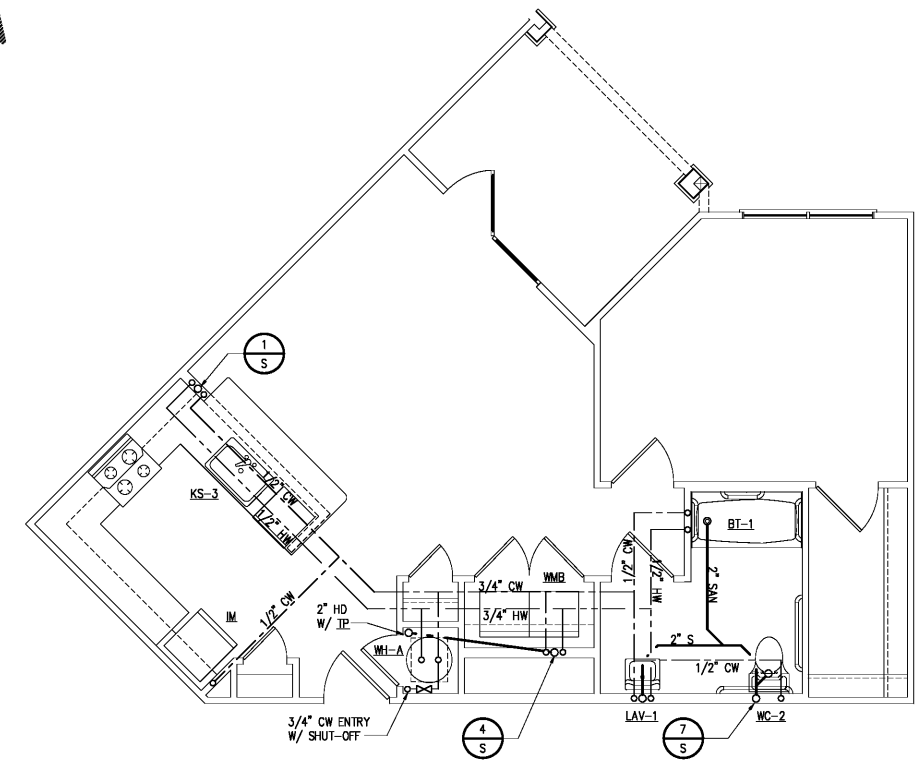

UNIT A3 HC FLOOR PLAN
 P-1 1/4" = 1'-0"

Order Plans @ www.LDLine.com