



**PUCCIANO & ENGLISH, INC.**  
**ARCHITECTS, AIA**  
 3084 MERCER UNIVERSITY DRIVE, SUITE 110  
 ATLANTA, GA 30341  
 PH 770-457-0623, FAX 770-451-0092  
 web@pucciano-english.com



JOB No: 1701  
 DRAWN BY: RK  
 CHECK BY: RK  
 JOB PROGRESS:  
 ITEM DATE  
 PRICING SET 07-14-2017  
 PERMIT SET 02-26-2018


REVISIONS:  
 DATE NO.

This drawing, as an instrument of service, is and shall remain the property of the Architect and shall not be reproduced, published or used in any way without the permission of the Architect.

**Legacy at Jones Farm Phase 2**  
 HUNTSVILLE, ALABAMA  
 AN APARTMENT COMMUNITY FOR  
 RBJ BAILEY, LLC


PLUMBING  
 RISER DIAGRAMS  
 SHEET NO.

P-3

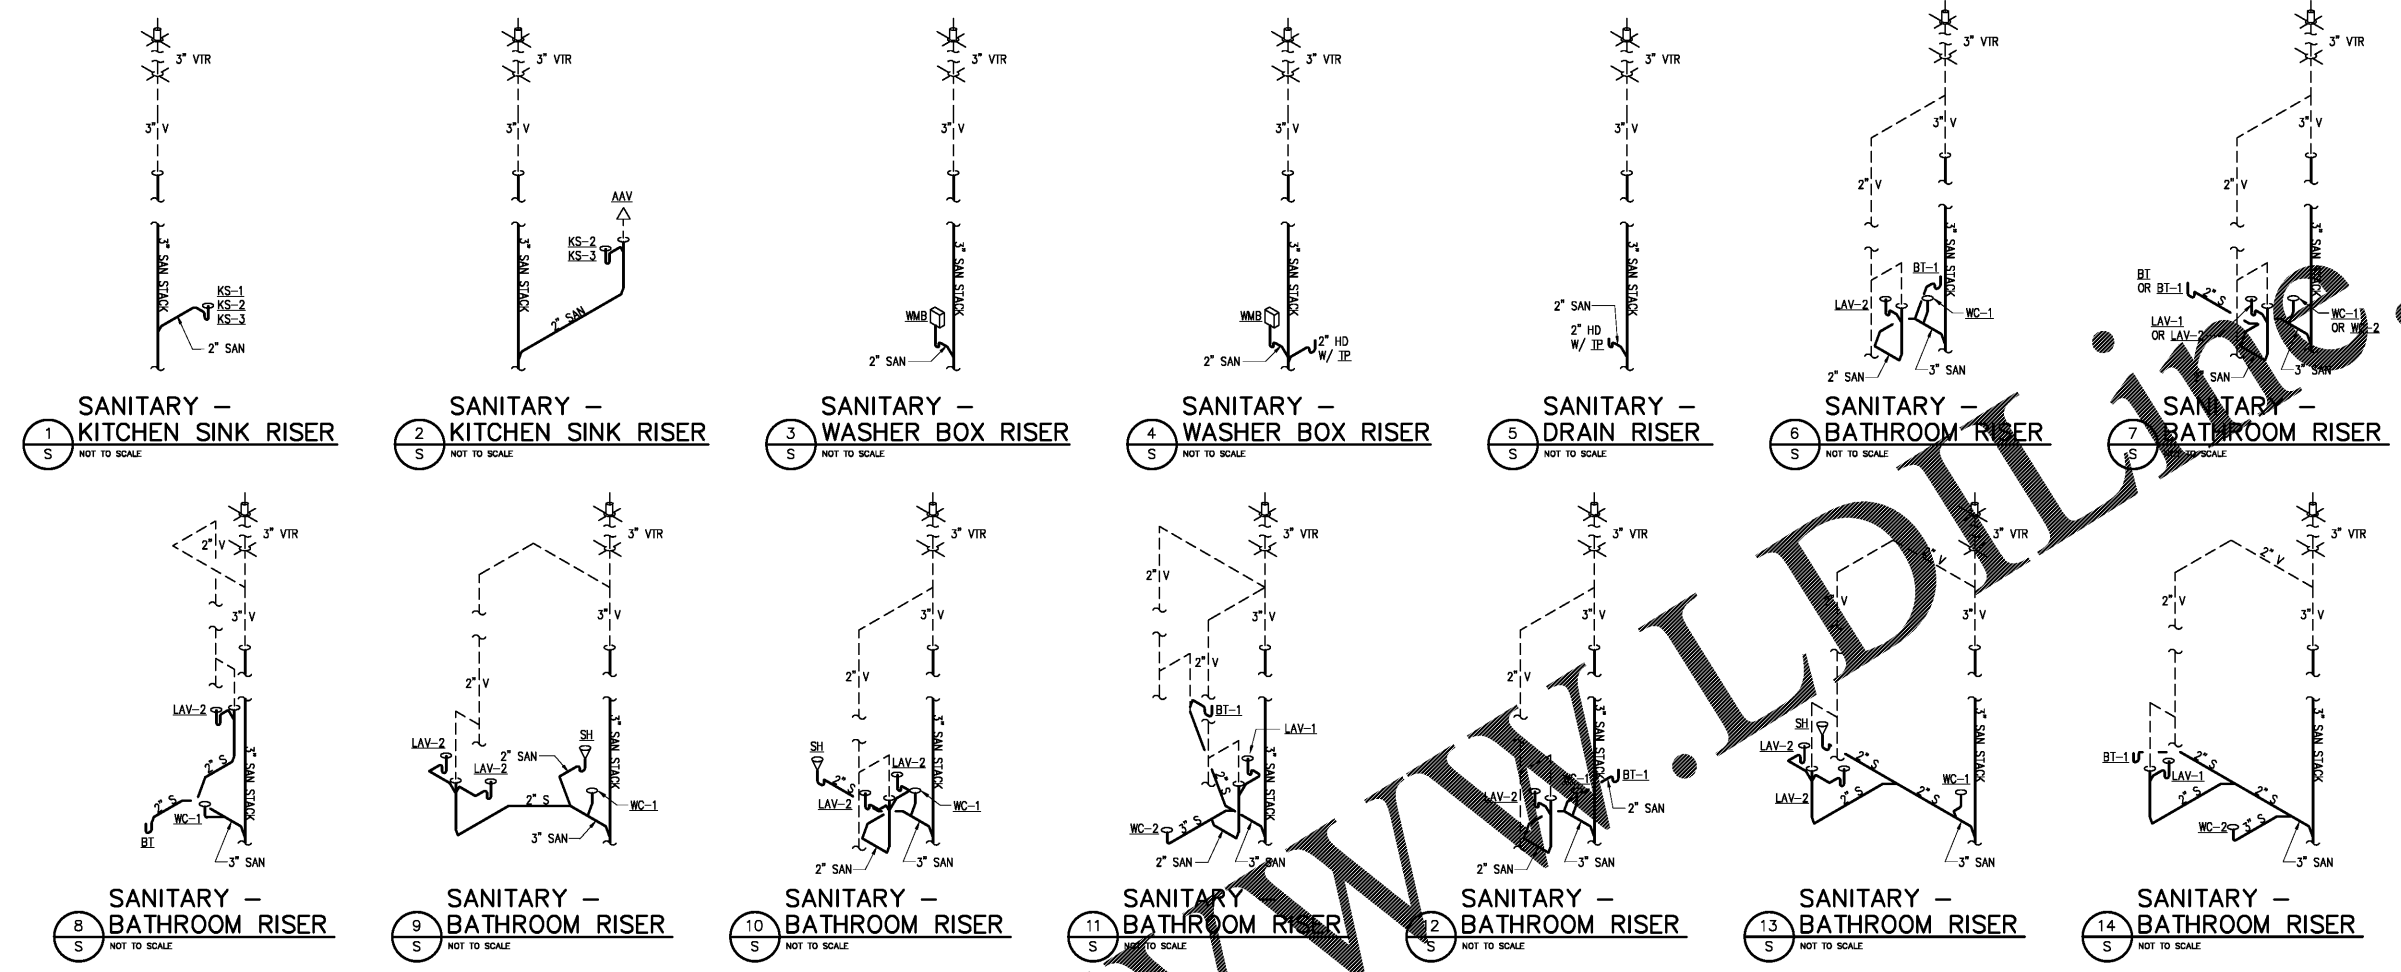

**SANITARY RISER DIAGRAMS**

NOTE: RISERS THAT ARE BACK-TO-BACK MAY BE COMBINED.

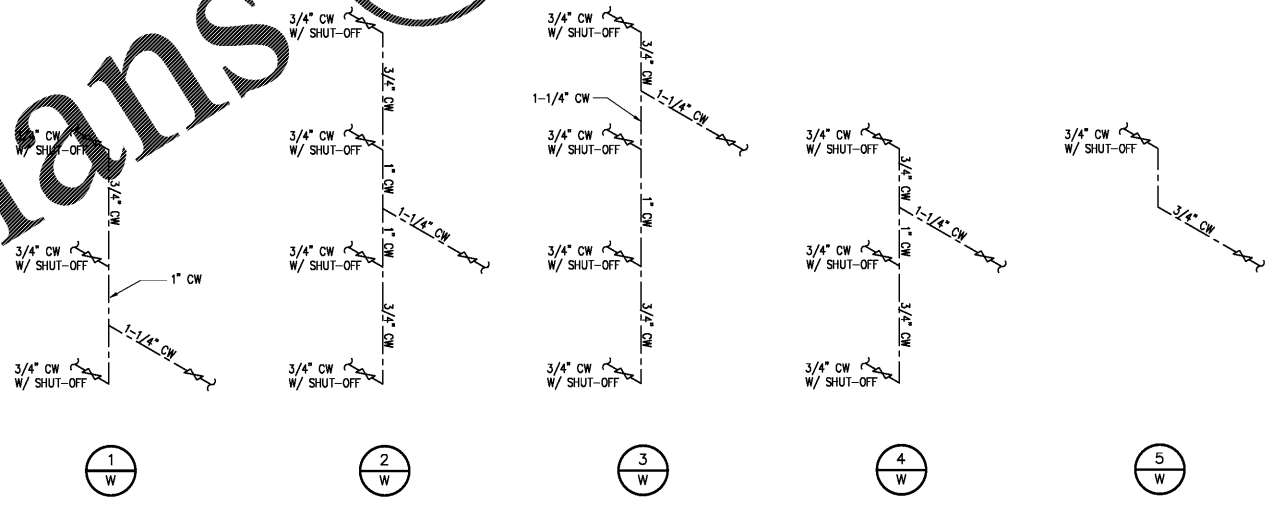

**DOMESTIC SUPPLY RISERS**

2 P-3 NOT TO SCALE

Order Plans @