

PUCCIAND & ENGLISH, INC.
ARCHITECTS, AIA
 3084 MERCER UNIVERSITY DRIVE, SUITE 110
 ATLANTA, GA 30341
 PH 770-457-0623, FAX 770-451-0092
 web@pucciano-english.com



JOB No: 1701
 DRAWN BY: RK
 CHECK BY: RK

JOB PROGRESS:

ITEM	DATE
PRICING SET	07-14-2017
PERMIT SET	02-26-2018


REVISIONS:
 DATE NO.

This drawing, as an instrument of service, is and shall remain the property of the Architect and shall not be reproduced, published or used in any way without the permission of the Architect.


Legacy at Jones Farm Phase 2
 HUNTSVILLE, ALABAMA
 AN APARTMENT COMMUNITY FOR
 RBJ BAILEY, LLC

PLUMBING
 BUILDING PLANS
 SHEET NO.


P-4

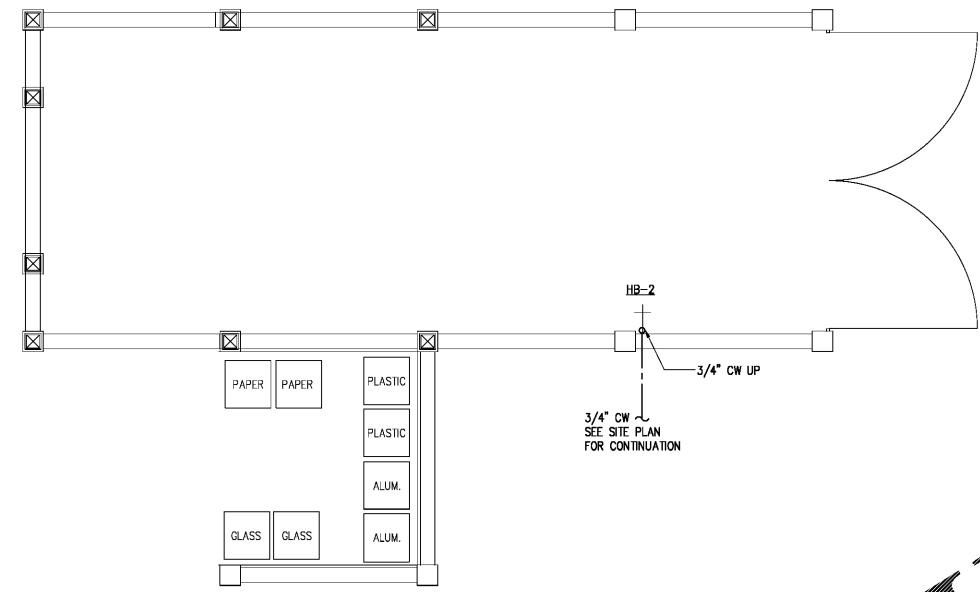

2
COMPACTOR FLOOR PLAN
 P-4 1/4" = 1'-0"

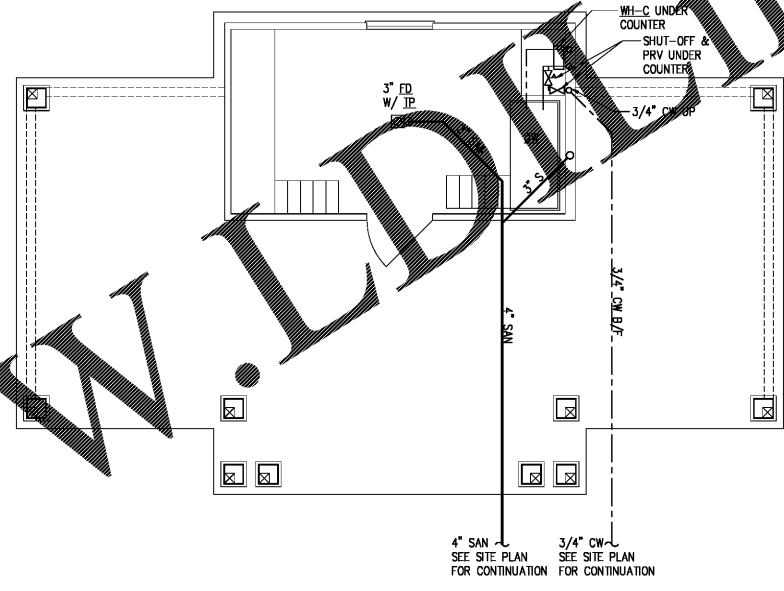

1
DOG WASH FLOOR PLAN
 P-4 1/4" = 1'-0"

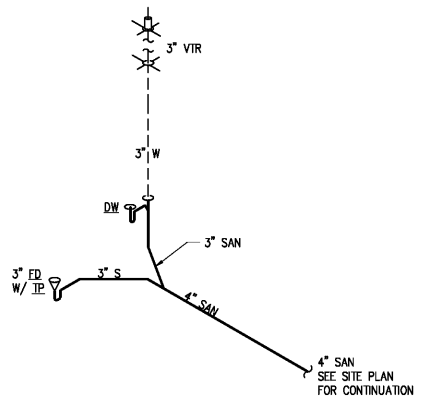

3
DOG WASH SANITARY PLAN
 P-4 NOT TO SCALE

Order Plans @ www.LDOnline.com