


1
E-12
6 CAR HC GARAGE ELECTRICAL PLAN
SCALE: 1/4" = 1'-0"

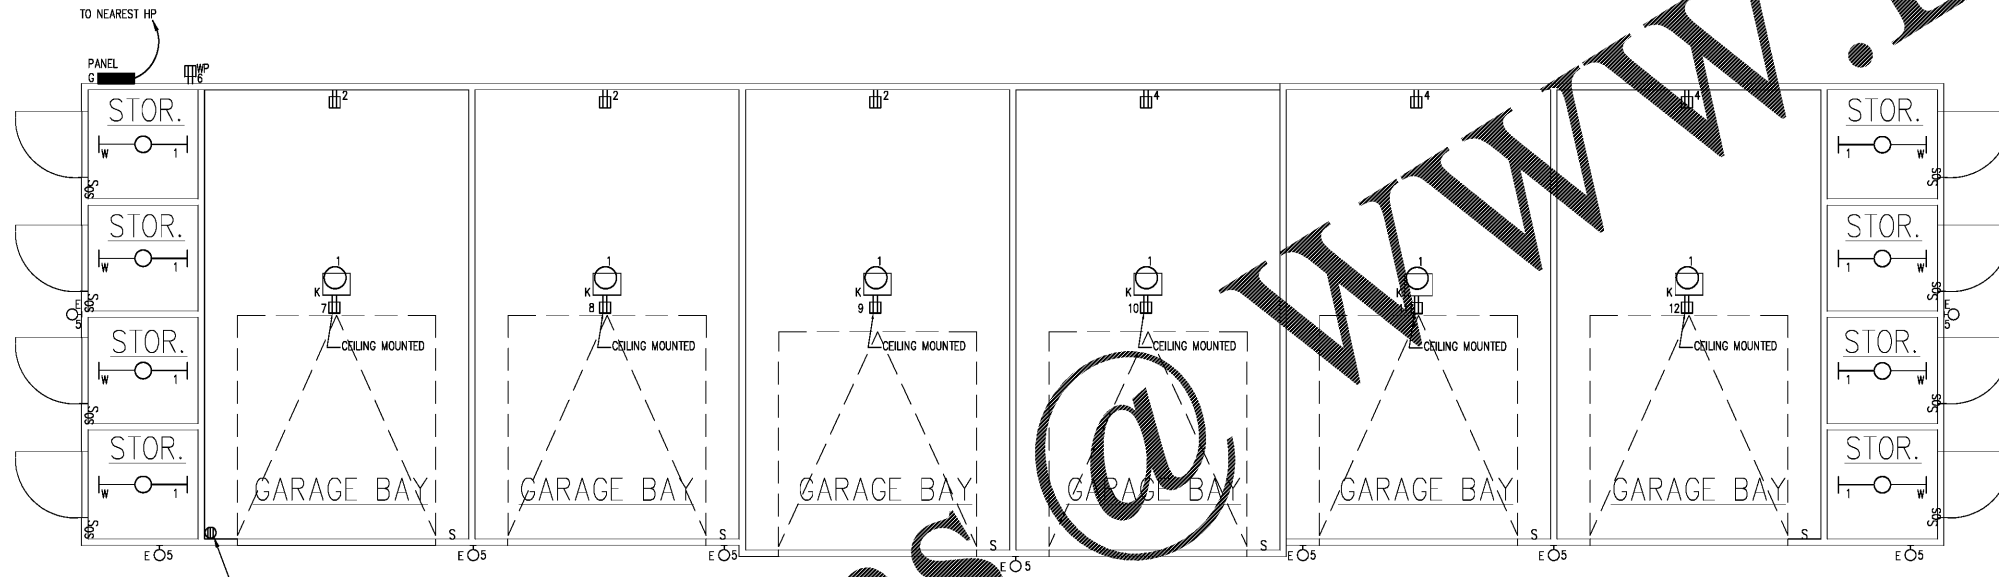

2
E-12
6 CAR GARAGE ELECTRICAL PLAN
SCALE: 1/4" = 1'-0"

Order Plans

WWW.LDILine.com



PUCCIANO & ENGLISH, INC.
ARCHITECTS, AIA
3084 MERCER UNIVERSITY DRIVE, SUITE 110
ATLANTA, GA 30341
PH 770-457-0823 FAX 770-451-0092
denglish@pucciano-english.com



JOB No: 1701
DRAWN BY:
CHECK BY:
JOB PROGRESS:
ITEM DATE
PRICING SET 07-14-2017
PERMIT SET 02-28-2018

REVISIONS:
DATE NO.

This drawing, as an instrument of service, is and shall remain the property of the Architect and shall not be reproduced, published or used in any way without the permission of the Architect.

Legacy at Jones Farm Phase 2
HUNTSVILLE, ALABAMA
AN APARTMENT COMMUNITY FOR
RBJ BAILEY, LLC

6 CAR GARAGE &
6 CAR HC GARAGE
ELECTRICAL PLANS
SHEET NO.

E-12