



1 TRASH COMPACTOR ELECTRICAL PLAN  
E-12.1 SCALE: 1/4" = 1'-0"

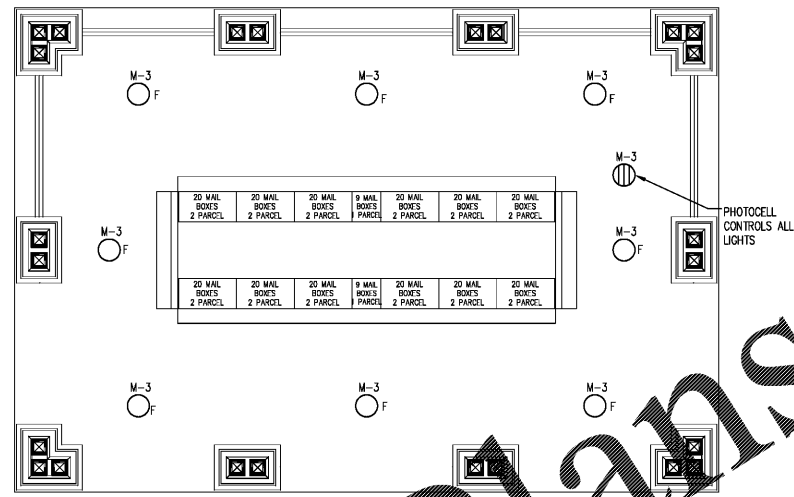

3 MAIL KIOSK ELECTRICAL PLAN  
E-12.1 SCALE: 1/4" = 1'-0"

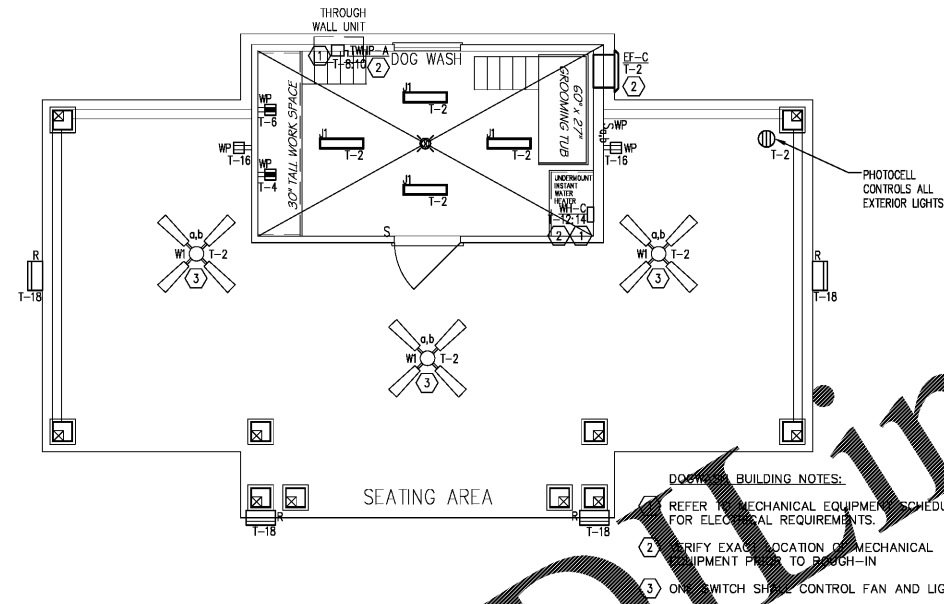

2 DOG WASH ELECTRICAL PLAN  
E-12.1 SCALE: 1/4" = 1'-0"



**PUCCIANO & ENGLISH, INC.**  
ARCHITECTS, AIA  
3084 MERCER UNIVERSITY DRIVE, SUITE 110  
ATLANTA, GA 30341  
PH 770-457-4823 FAX 770-451-0092  
denGLISH@pucciano-english.com



JOB No: 1701  
DRAWN BY:  
CHECK BY:  
JOB PROGRESS:  
ITEM DATE  
PRICING SET 07-14-2017  
PERMIT SET 02-28-2018

REVISIONS:  
DATE NO.  
  
This drawing, as an instrument of service, is and shall remain the property of the Architect and shall not be reproduced, published or used in any way without the permission of the Architect.

*Legacy at Jones Farm Phase 2*  
HUNTSVILLE, ALABAMA  
AN APARTMENT COMMUNITY FOR  
RBJ BAILEY, LLC

TRASH COMPACTOR,  
DOG WASH & MAIL KIOSK  
ELECTRICAL PLANS  
SHEET NO.

E-12.1

Order Plans @ WWW.LDOnline.com