

**PRICE, P.C.**  
CONSULTING ENGINEERS  
CIVIL, ELECTRICAL, MECHANICAL, PLUMBING, AND  
1850 Woodstone Drive, Suite 200, Huntsville, AL 35892 | Telephone: 256-838-0200 | Fax: 256-838-0206

**LEGACY AT JONES FARM  
PHASE 2**


CLIENT  
RBJ BAILEY, LLC  
PO BOX 2545  
HUNTSVILLE, AL 35804

SITE ADDRESS  
1 LEGACY FARM DR SE  
HUNTSVILLE, AL 35802

REVISIONS


SHEET TITLE  
**LAYOUT AND PAVING PLAN**

SCALE: 1"=20'  
APPROVED BY: JRI  
PROJECT NO: 17-105  
DATE: 12/28/17  
SHEET NUMBER  
C2.4 OF C2.4

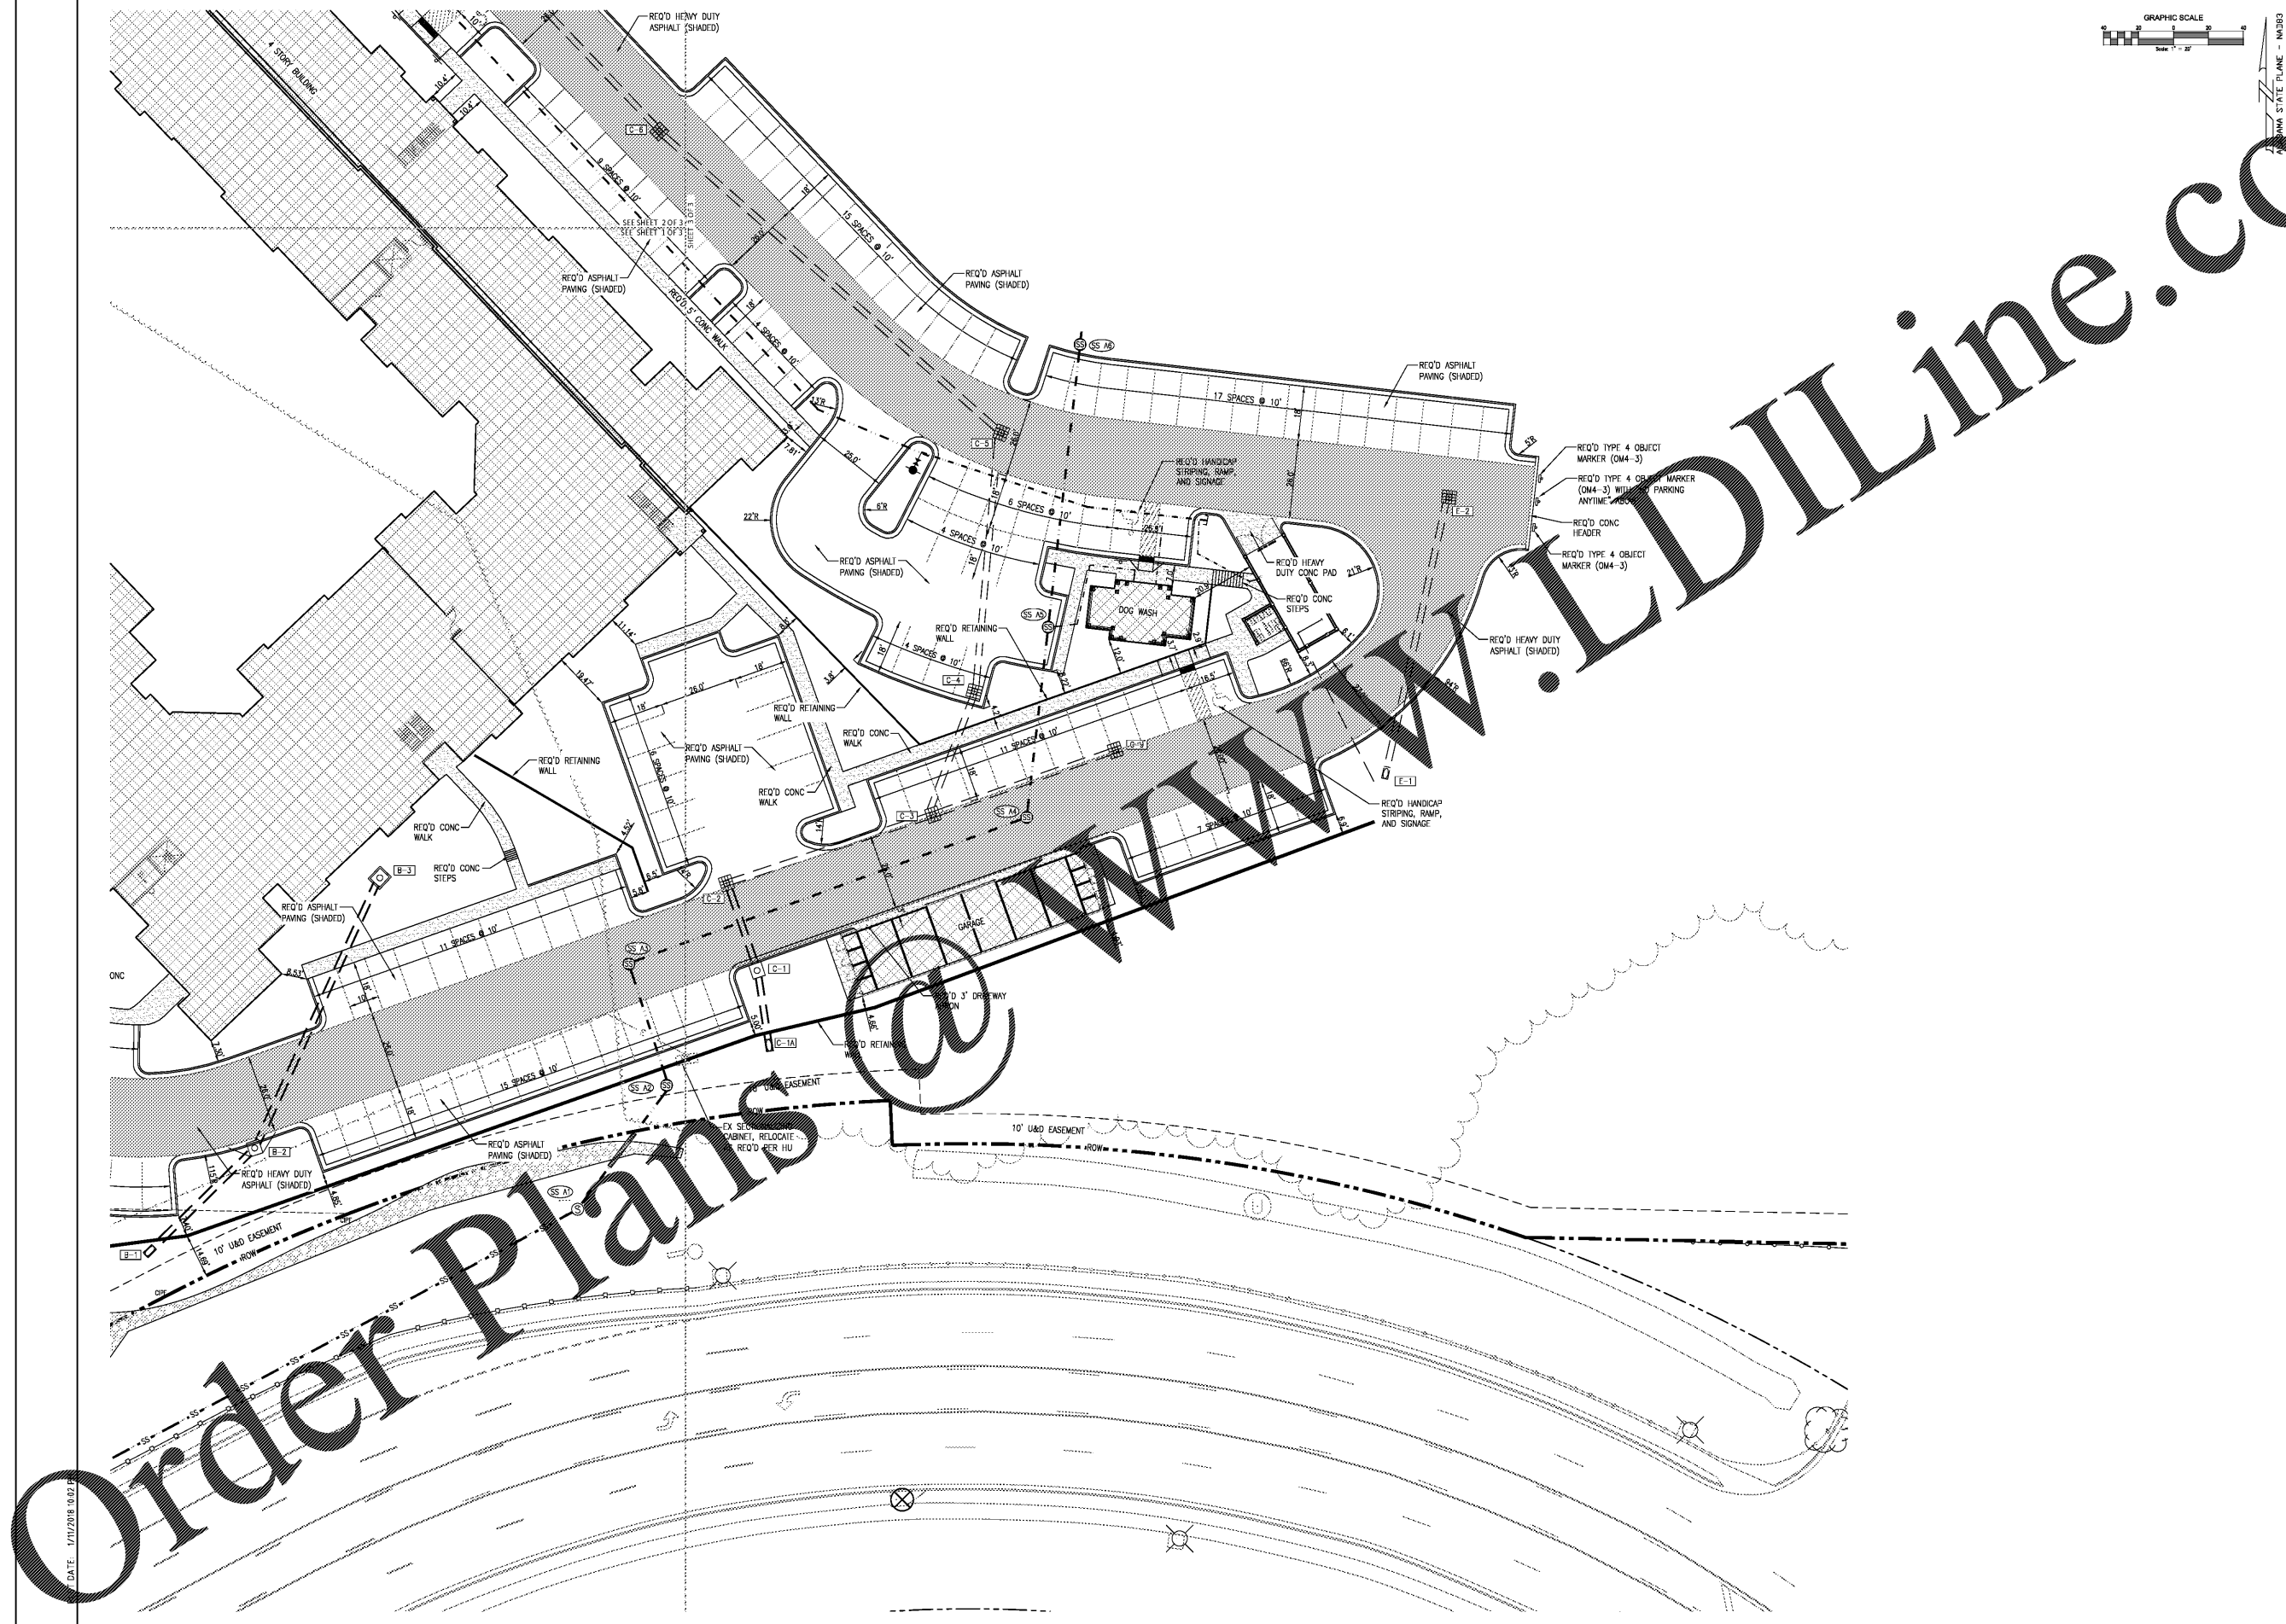

Order Plans @

DATE: 1/11/2018 10:02 PM