




Chick-fil-A
5200 Buffington Road
Atlanta, Georgia 30349-2998

INTERPLAN
ARCHITECTURE
ENGINEERING
INTERIOR DESIGN
PROJECT MANAGEMENT

604 COURTLAND STREET
SUITE 100
ORLANDO, FLORIDA 32804
PH 407.645.5008
FX 407.629.9124

SEAL:
THIS DOCUMENT IS NOT FOR CONSTRUCTION
UNLESS THE ARCHITECT OR ENGINEER'S
SIGNATURE AND SEAL APPEAR BELOW.

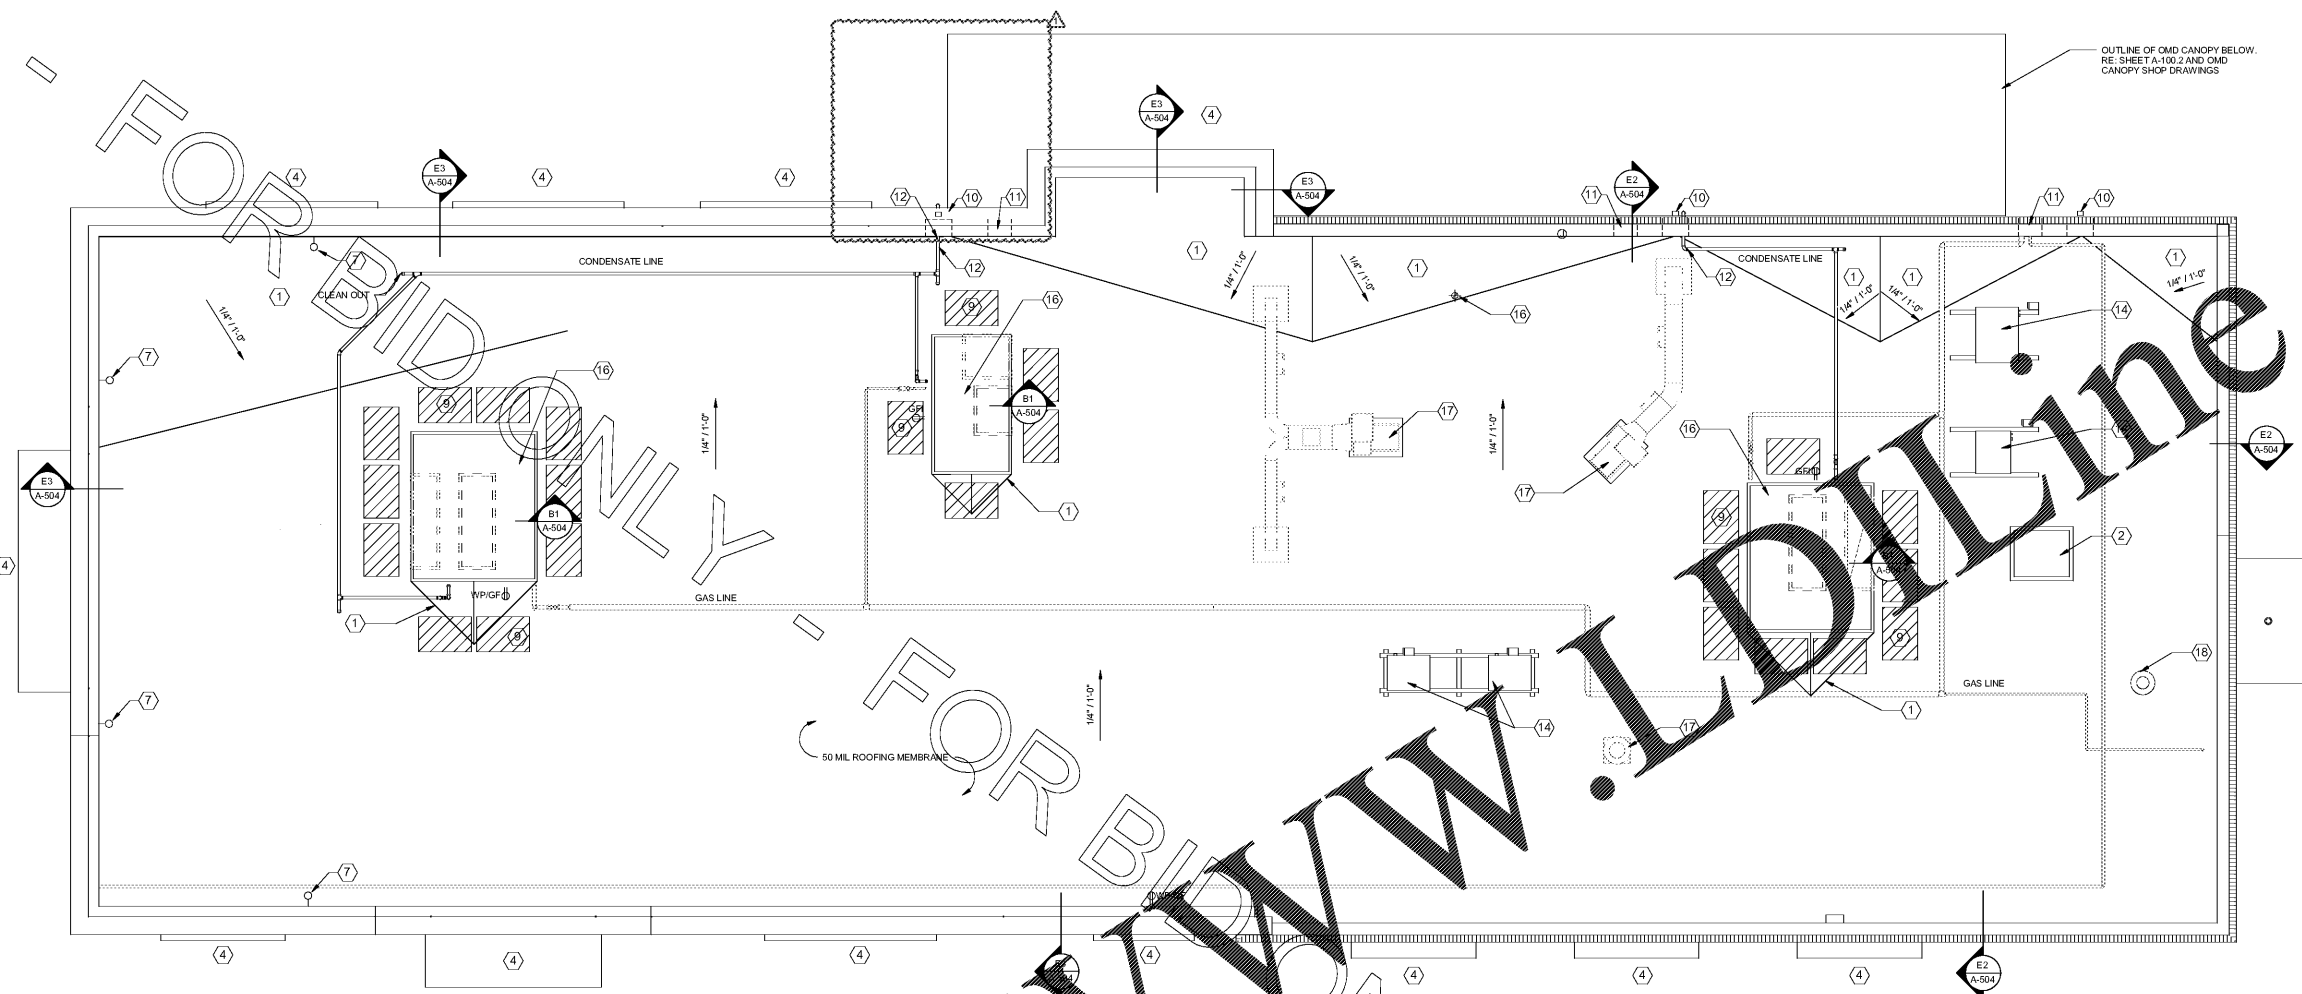

C1 ROOF PLAN-LRG
1/4" = 1'-0"

| ROOFPLAN KEYNOTES - LRG | |
|-------------------------|---|
| 1 | CRICKET CONSTRUCTED OF ROOF MEMBRANE ON RIGID INSULATION - SLOPE AT 1/4" PER FT MIN |
| 2 | 2'-0" X 3'-0" ROOF HATCH. BELCO OR EQUAL. |
| 4 | CANOPY BELOW BY FABRICATOR. |
| 7 | 3/8" X 4 1/2" EYE SCREW ANCHORS (INSTALL 2x SOLID BLOCKING BETWEEN STUDS FOR ATTACH ANCHORS). LOCATIONS APPROXIMATE. VERIFY WITH OWNER AND CONSTRUCTION MANAGER. RE: DETAIL D2/A504. |
| 9 | GRAY WALK PAD MEMBRANES, TYP. |
| 10 | 4"x10" SCUPPER, LEADER HEAD & DOWNSPOUT. RE: DETAIL. RE: EXTERIOR ELEVATION FOR LOCATION. |
| 11 | 4"x16" OVERFLOW SCUPPER. RE: DETAIL. INSTALL WITH BOTTOM EDGE 2" ABOVE ROOF SURFACE. |
| 12 | DISCHARGE CONDENSATE INTO DOWNSPOUT. RE: PLUMBING ROOF DRAWING. |
| 14 | ALUMINUM EQUIPMENT STAND SUPPORTS MANUFACTURED BY AVCO CORPORATION OF FORT LAUDERDALE, FLORIDA OR APPROVED EQUAL. 4 RAILS AT 5'-0" EACH AND 2 RAILS AT 9'-0" WITH 3 SUPPORTS EACH RAIL (CENTER MIDDLE LEG). 5'-0" RAILS TO BE 31" APART AT COOLER FREEZER CONDENSERS AND 9'-0" RAILS TO BE 24" APART AT ICE MACHINE CONDENSERS. STANDS SHALL PROVIDE 18" MINIMUM CLEARANCE (48" O.C. AT ICE MAKER CONDENSERS) AND SHALL BE SIZED AND INSTALLED ACCORDING TO THE MANUFACTURER'S LOAD CHARTS AND PRINTED INSTALLATION DETAILS. CONTACT: 800-266-7212. |
| 16 | AIR CONDITIONING UNIT. RE: MECHANICAL. |
| 17 | EXHAUST FAN. RE: MECHANICAL. |
| 18 | COMBINATION AIR VENT. RE: MECHANICAL & PLUMBING. |

| ROOF PLAN GENERAL NOTES | |
|-------------------------|---|
| A.1 | R-VALUE OF RIGID INSULATION MAY VARY DEPENDING ON MANUFACTURER. GC SHALL BE RESPONSIBLE FOR VERIFYING APPROPRIATE THICKNESS TO MEET R-VALUE REQUIREMENTS. |
| A.2 | VERTICAL ROOF MEMBRANE SURFACES ON VERTICAL BACK WALLS OF PARAPET AND KICKERS (WHERE USED) SHALL BE TAN. ALL OTHER ROOF MEMBRANE SURFACES SHALL BE WHITE. |
| A.3 | PROVIDE PIPE SUPPORTS (NOT SHOWN HERE) FOR GAS AND CONDENSATE LINES AT 4'-0" O.C. MAX. |
| A.4 | REFER TO MECHANICAL, ELECTRICAL AND PLUMBING ROOF PLANS FOR INFORMATION NOT SHOWN HERE. |
| A.5 | PAINT ALL EXPOSED GAS PIPING ON ROOF DARK BRONZE (2 COATS). |
| A.6 | ALL CONDENSATE LINES SHALL BE INSTALLED TO PROVIDE POSITIVE DRAINAGE. GENERAL CONTRACTOR SHALL PROVIDE BLOCKING AS REQUIRED TO ELIMINATE SAGGING. |
| A.7 | PROVIDE SIDEWALL MOUNTED LIGHT FIXTURE PER E1/A504. COORDINATE LOCATION WITH C.M. |
| A.8 | ROOF PENETRATIONS TO BE INSTALLED PER DETAILS C2/A504 AND D1/A504. |

CHICK-FIL-A
SAR South Cobb Drive FSR
3100 South Cobb Dr SE, Smyrna, GA 30080

FSR# 00810

| REVISION SCHEDULE | | |
|-------------------|----------|------------------------|
| NO. | DATE | DESCRIPTION |
| 1 | 11/06/17 | COORDINATION REVISIONS |

CONSULTANT PROJECT # 2017.0165
PRINTED FOR BID
DATE September 06, 2017
DRAWN BY AD

Information contained on this drawing and all digital files produced for this project shall remain the property of INTERPLAN, LLC. No part of this drawing may be reproduced or transmitted in any form or by any means, electronic or mechanical, including photocopying, recording, or by any information storage and retrieval system, without the prior written permission of INTERPLAN, LLC.

SHEET ROOF PLAN
SHEET NUMBER
A-230L

Order Plans @ WWW.LDOLINE.COM

2/5/2018 10:27:47 PM

COPYRIGHT © 2017 INTERPLAN, LLC. ALL RIGHTS RESERVED. THESE DOCUMENTS ARE THE ORIGINALS OF INTERPLAN, LLC. ANY REPRODUCTION OF THESE DOCUMENTS WITHOUT THE WRITTEN PERMISSION OF INTERPLAN, LLC IS PROHIBITED.